


**NOTES:**

- REFER TO DRAWING E01 FOR LEGEND AND GENERAL NOTES
- LIGHT SWITCH FOR LUMINAIRES MOUNTED TO ROOF PLANT DECK.

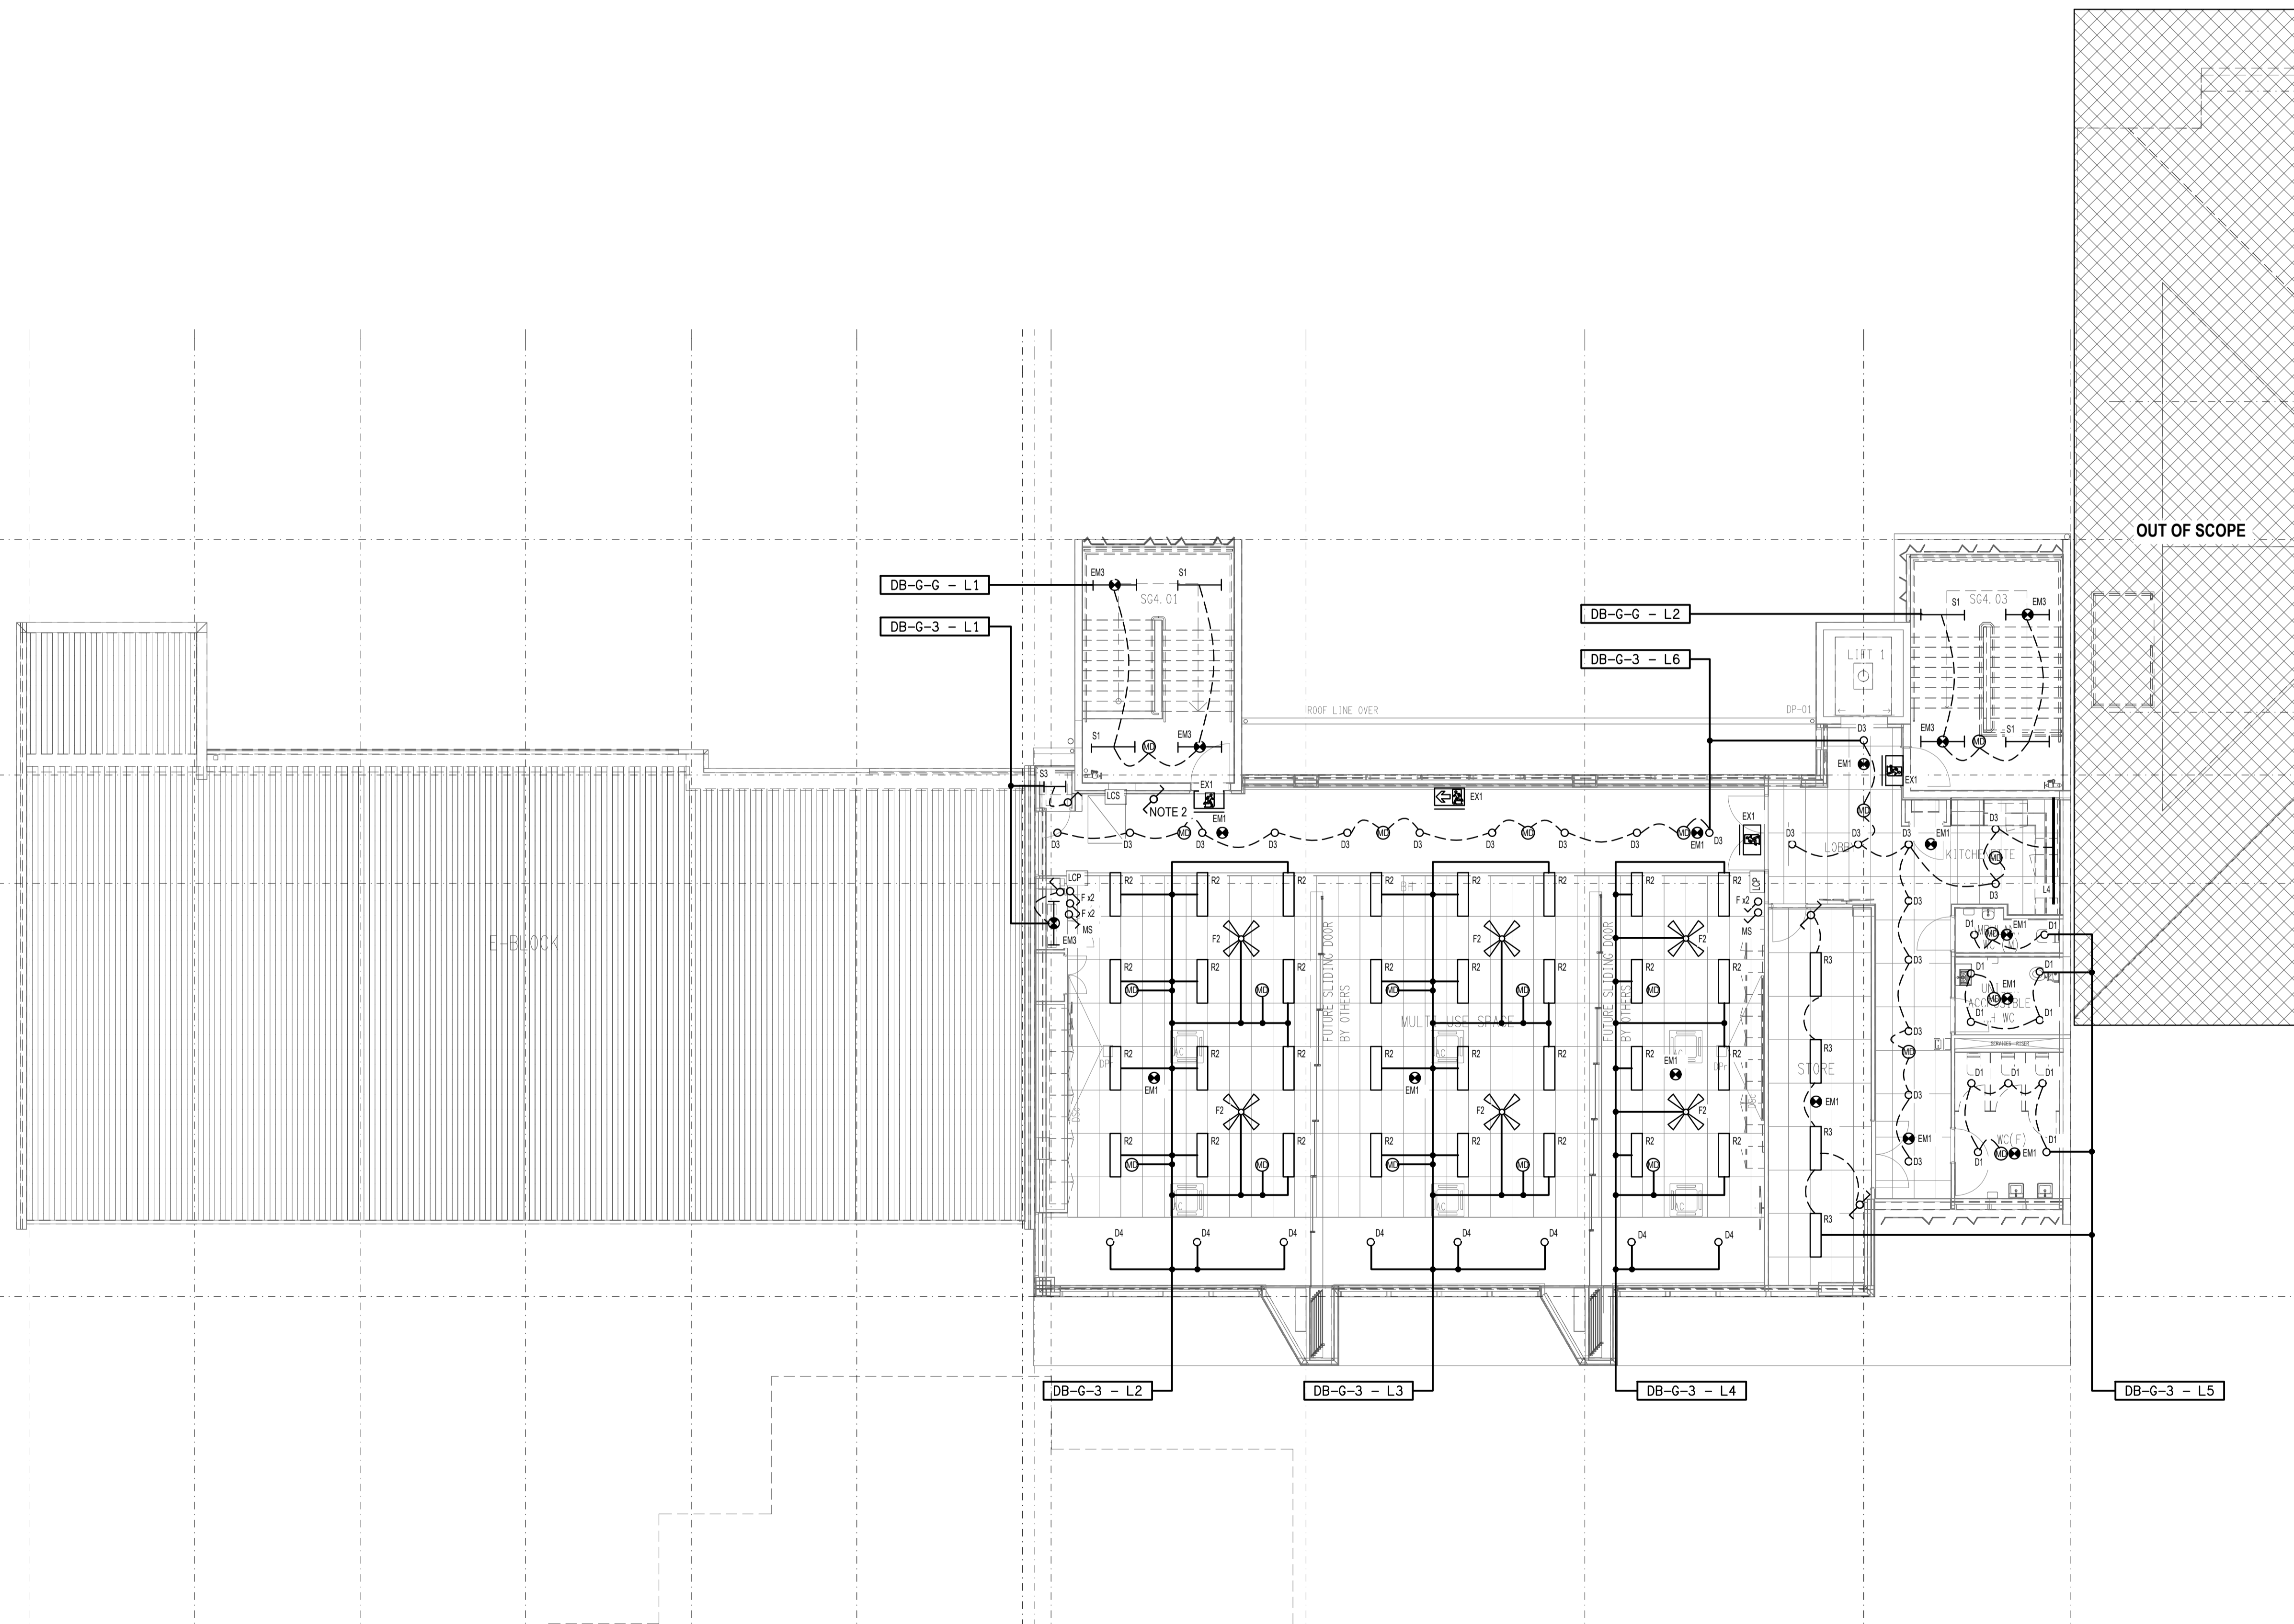

C	INFORMATION	11/12/2023
REV:	DESCRIPTION:	DATE:

**ELECTRICAL DESIGN GROUP**  
ELECTRICAL BUILDING SERVICES CONSULTANTS

BRISBANE: P.O. Box 15 Sherwood Qld 4075  
Phone: (07) 3278 4375  
Email: brisbane@edg.net.au  
Web: www.edg.net.au

ELECTRICAL DESIGN GROUP BRISBANE / TRADING AS:  
PTY LTD ACN 092 710 793 / ELECTRICAL DESIGN GROUP

PROJECT:  
**LOURDES HILL COLLEGE  
STAGE 1**

SITE ADDRESS:  
86 HAWTHORNE ROAD,  
HAWTHORNE, QUEENSLAND

SCALE: 1:100 SHEET SIZE:  
AT A1

DRAWING TITLE:  
**ELECTRICAL SERVICES  
STAGE 1A LEVEL 3  
REFLECTED CEILING PLAN**

PROJECT NO. DRAWING NO. REVISION:  
**C3134a E11 C**