


NOTES:

- REFER TO DRAWING E01 FOR LEGEND AND GENERAL NOTES
- OUTLETS TO BE MOUNTED BEHIND DISPLAY.
- SUPPLY AND INSTALL ELECTRICAL AND COMMUNICATIONS CONDUITS CAST IN SLAB FROM FLOORBOX TO NEAREST WALL FOR RETICULATION OF CABLING.

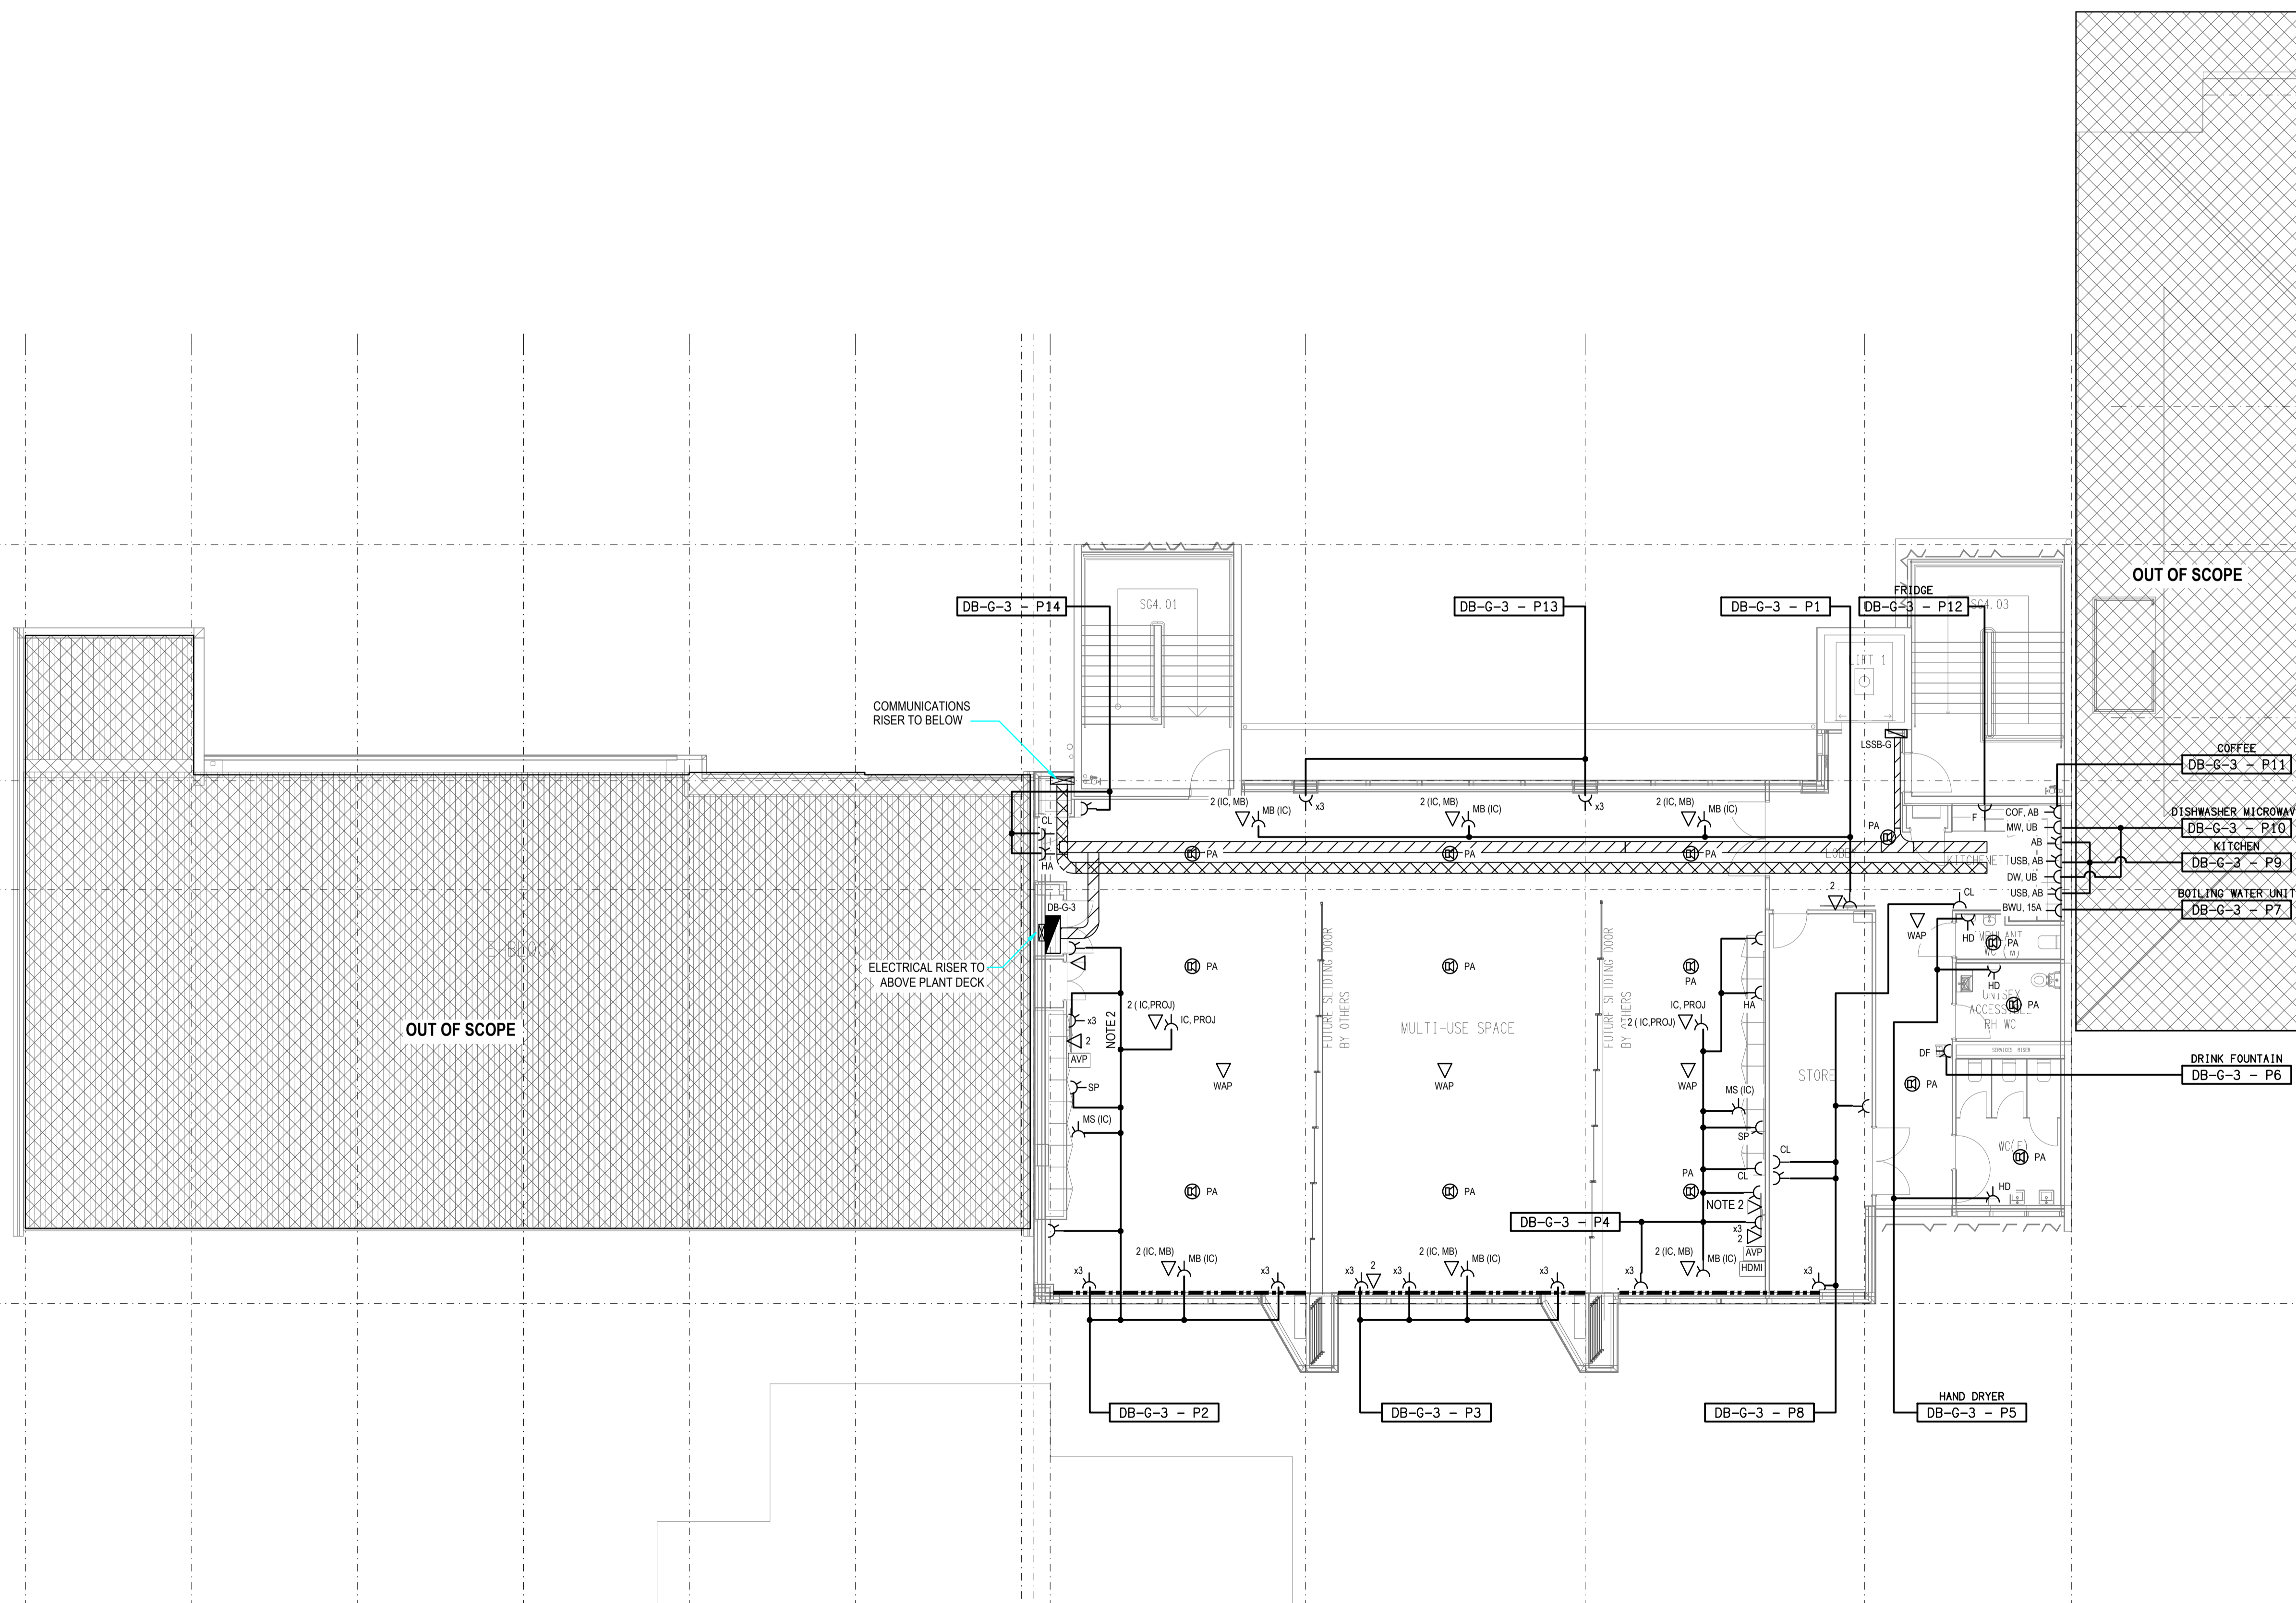

C	INFORMATION	11/12/2023
REV:	DESCRIPTION:	DATE:

ELECTRICAL DESIGN GROUP
ELECTRICAL BUILDING SERVICES CONSULTANTS

BRISBANE: P.O. Box 15 Sherwood Qld 4075
Phone: (07) 3278 4375
Email: brisbane@edg.net.au
Web: www.edg.net.au

ELECTRICAL DESIGN GROUP BRISBANE / TRADING AS: ELECTRICAL DESIGN GROUP
PTY LTD / ACN 092 710 793

PROJECT:
**LOURDES HILL COLLEGE
STAGE 1**

SITE ADDRESS:
86 HAWTHORNE ROAD,
HAWTHORNE, QUEENSLAND

SCALE: 1:100 SHEET SIZE: AT A1

DRAWING TITLE:
**ELECTRICAL SERVICES
STAGE 1A LEVEL 3
FLOOR PLAN**

PROJECT NO. DRAWING NO. REVISION:
C3134a E17 C