


**NOTES:**

1. REFER TO DRAWING E01 FOR LEGEND AND GENERAL NOTES
2. COMMUNICATIONS CABLE TRAY FOR FUTURE J BLOCK
3. ABOVE BENCH OUTLETS REQUIRE A MINIMUM DISTANCE FROM THE SINK IN ACCORDING WITH AS3000:  
 - SINK ABOVE 40L: 1m ABOVE SINK, 0.5m FROM SIDE OF SINK  
 - SINK BELOW 40L: 0.4m ABOVE SINK, 0.15m FROM SIDE OF SINK  
 - 0.6m AWAY FROM SHOWER
4. OUTLETS TO BE MOUNTED BEHIND DISPLAY.
5. CONDUITS TO COVERED WALKWAY, BUS DROP-OFF AND CARPARK LIGHTING FROM FIT.
6. CONDUITS TO TURN UP WALL INTO CEILING.
7. REMOVE ALL EXISTING POWER AND DATA OUTLETS INCLUDING CABLING IN THE UNDERCROFT WHERE THE NEW ADMIN FITOUT IS TO BE CONSTRUCTED.
8. CONTINUES ON DRAWING E23 (STAGE 1C)

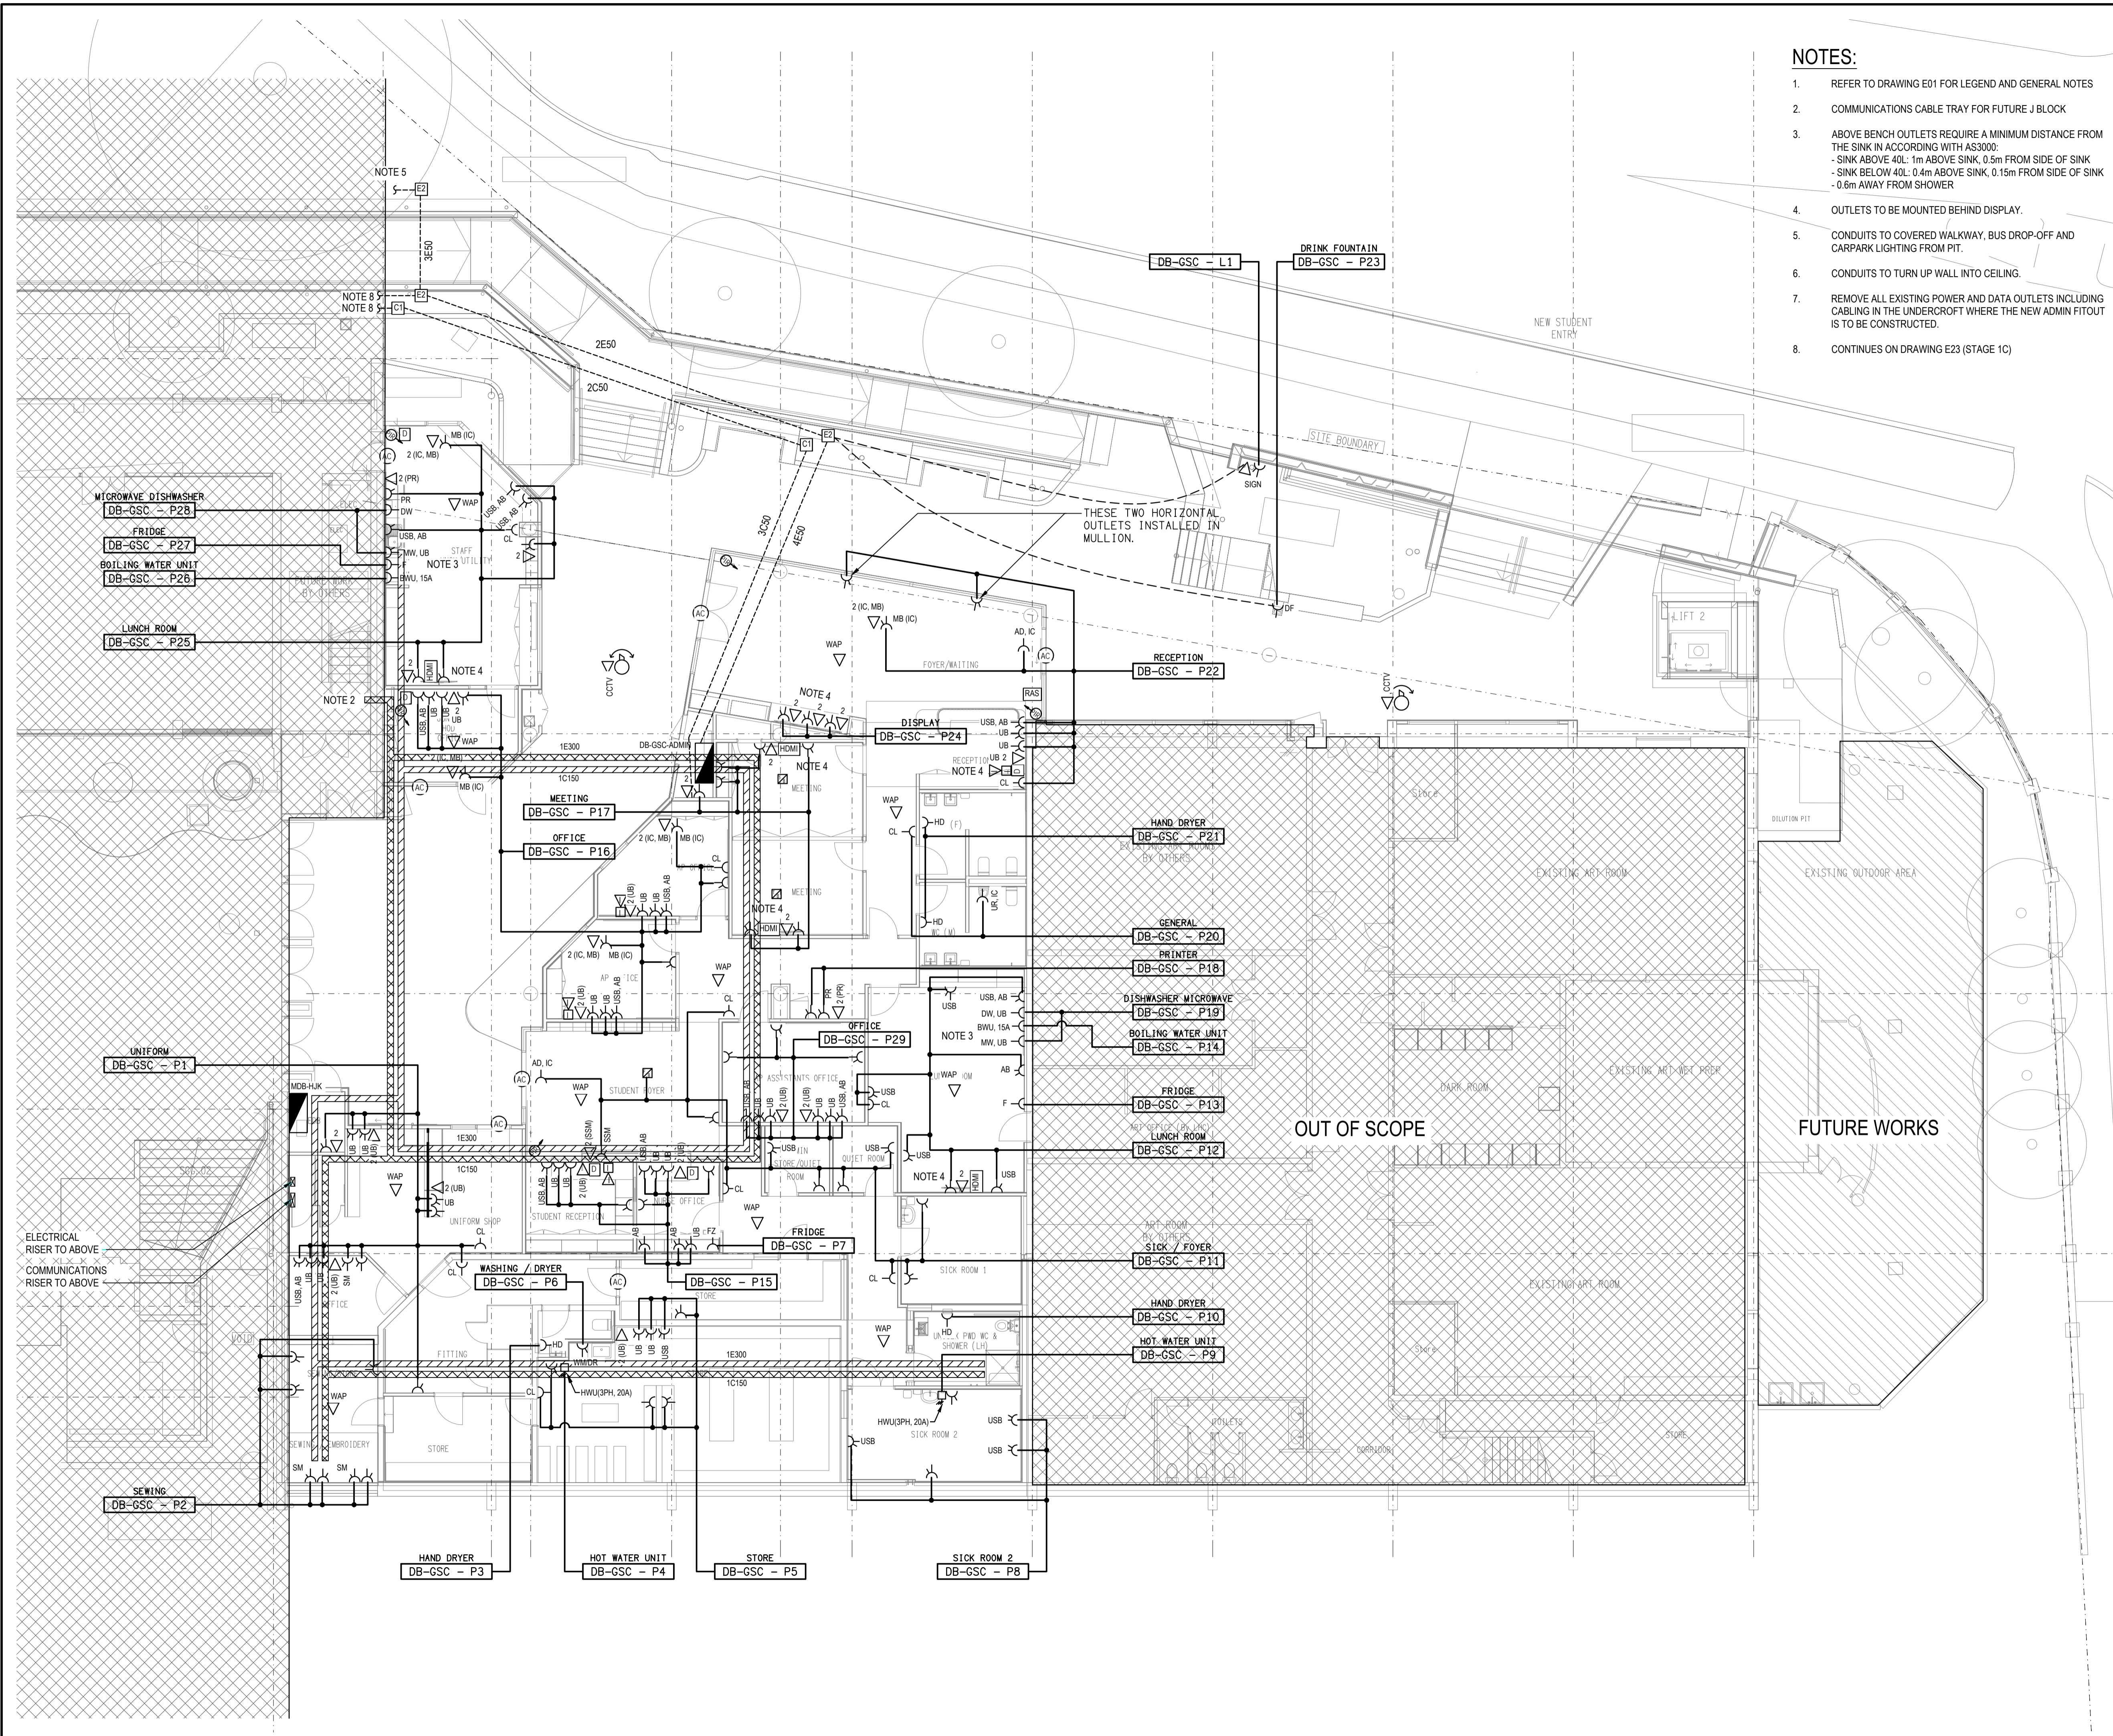

C	INFORMATION	11/12/2023
REV:	DESCRIPTION:	DATE:

**ELECTRICAL DESIGN GROUP**  
 ELECTRICAL BUILDING SERVICES CONSULTANTS

BRISBANE: P.O. Box 15 Sherwood Qld 4075  
 Phone: (07) 3278 4375  
 Email: brisbane@edg.net.au  
 Web: www.edg.net.au

ELECTRICAL DESIGN GROUP BRISBANE PTY LTD  
 ACN 092 710 793

TRADING AS:  
 ELECTRICAL DESIGN GROUP

PROJECT:  
**LOURDES HILL COLLEGE  
 STAGE 1**

SITE ADDRESS:  
 86 HAWTHORNE ROAD,  
 HAWTHORNE, QUEENSLAND

SCALE: 1:100 SHEET SIZE: AT A1

DRAWING TITLE:  
**ELECTRICAL SERVICES  
 STAGE 1B LOWER GROUND  
 FLOOR PLAN**

PROJECT NO. DRAWING NO. REVISION:  
**C3134a E21 C**