



DETAIL B
HAND DRYER CONNECTION
NOT TO SCALE

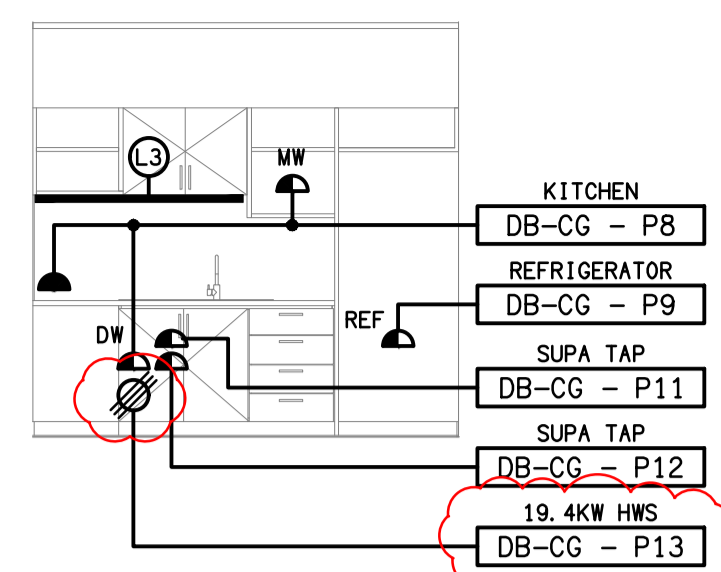

DETAIL A
ENTRY KITCHENETTE ELEVATION
NOT TO SCALE

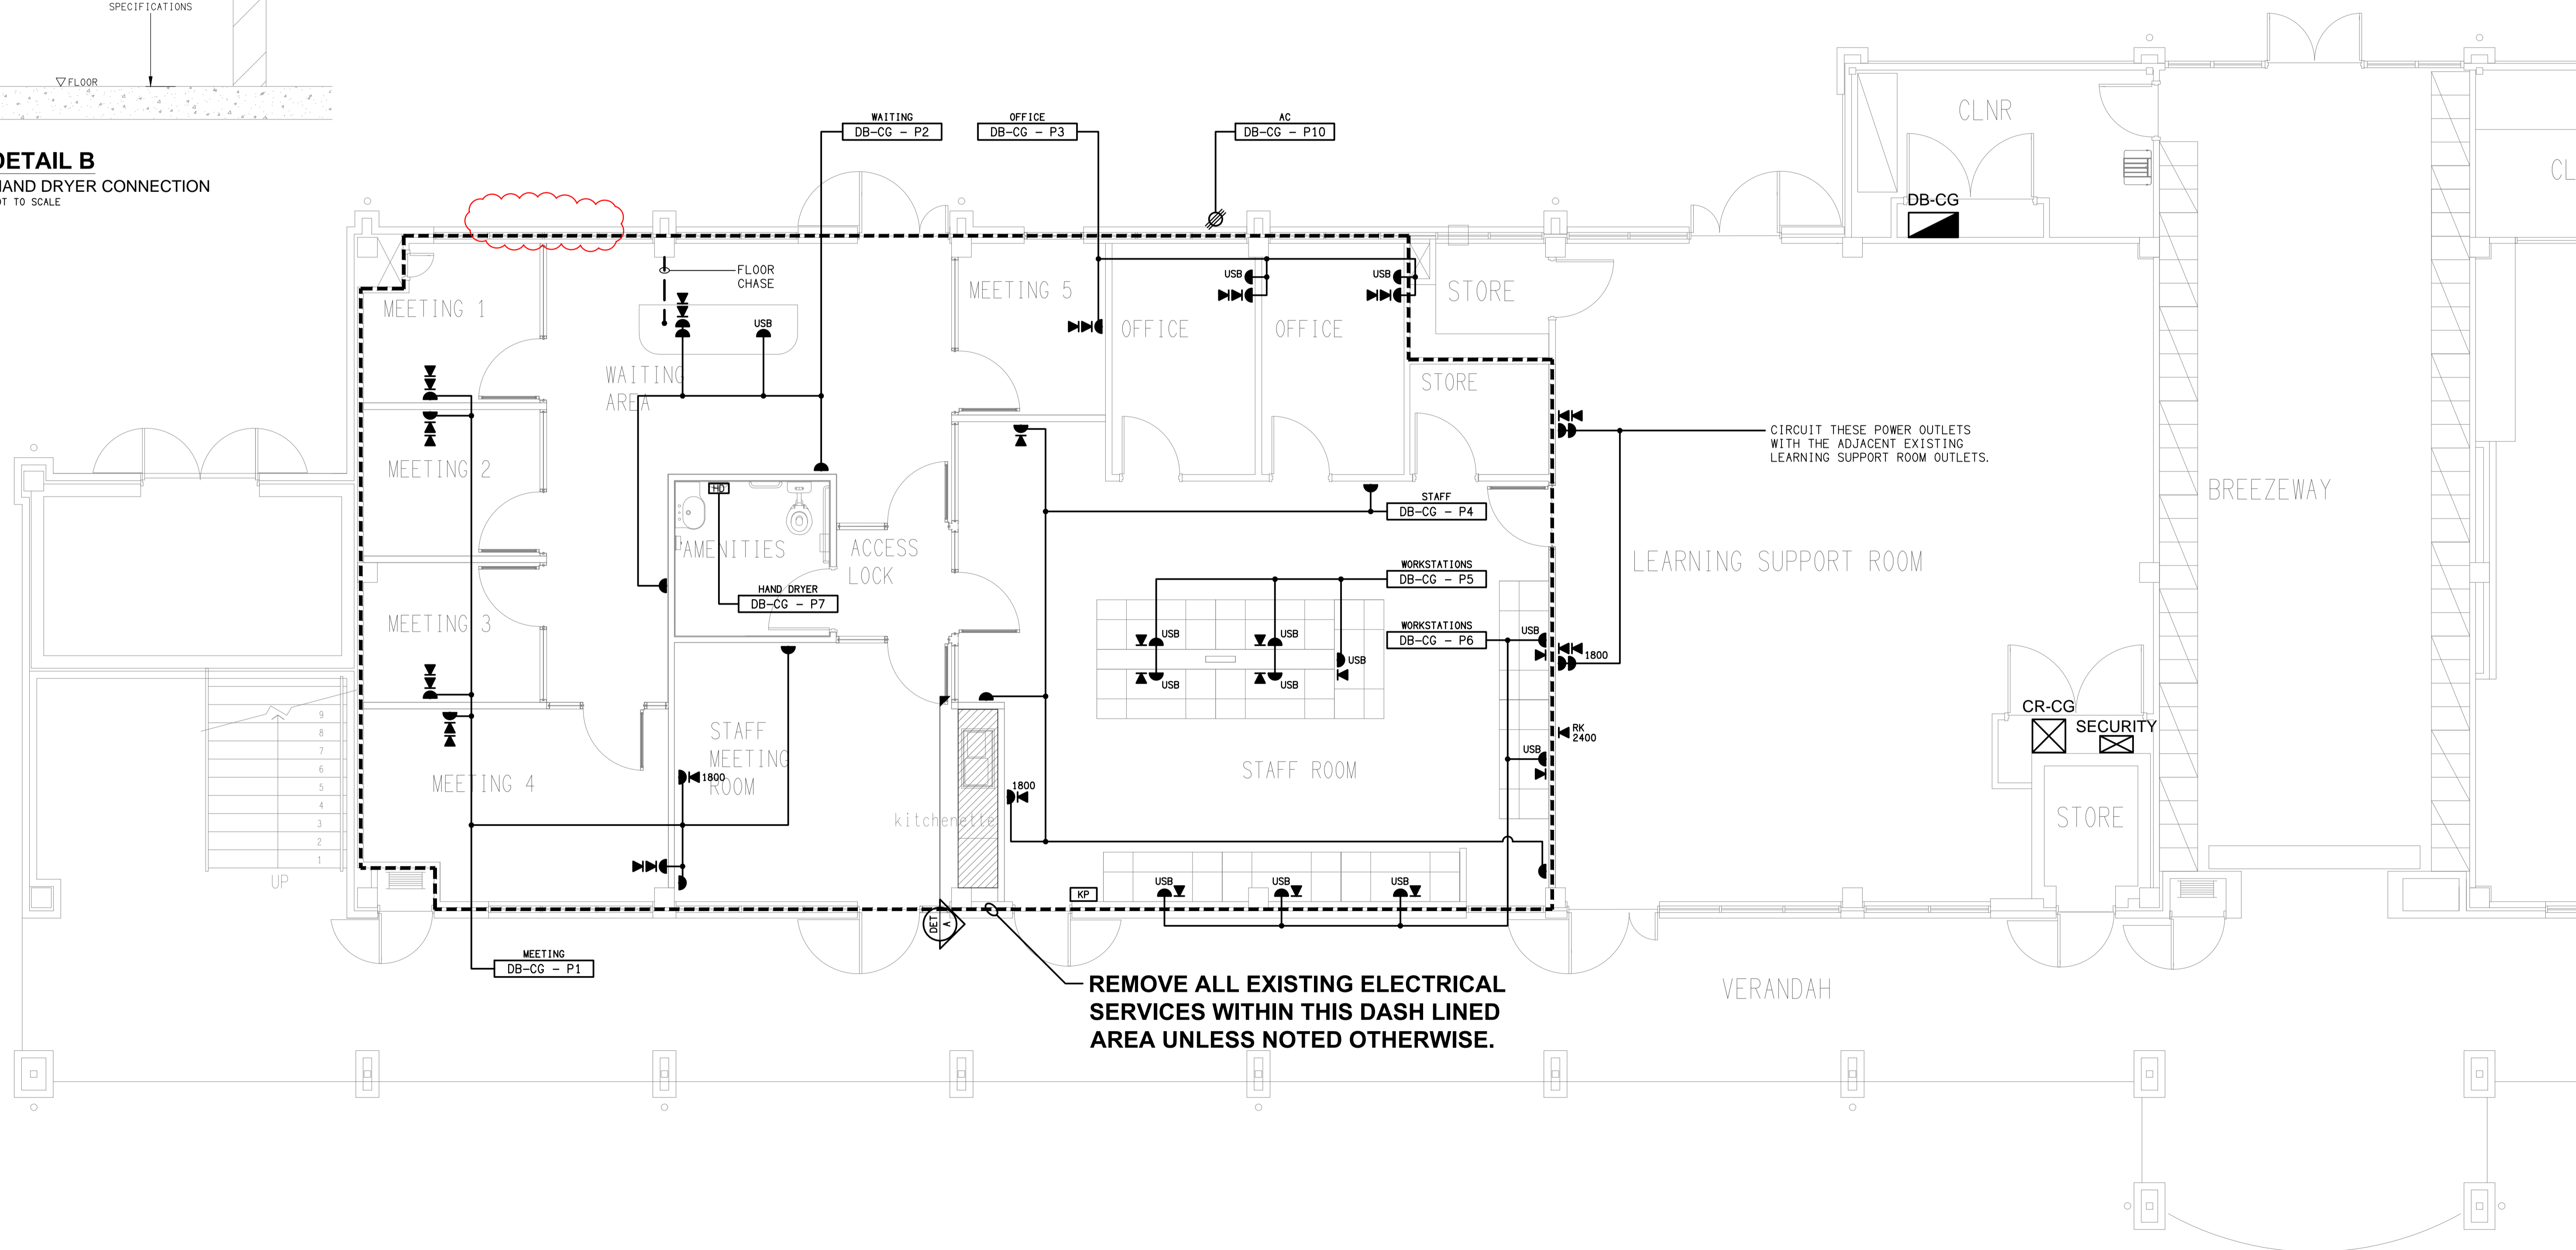

ELECTRICAL DESIGN GROUP BRISBANE
PTY LTD
ACN 092 710 793
TRADING AS:
ELECTRICAL DESIGN GROUP

THE COPYRIGHT OF THIS DRAWING
REMAINS THE PROPERTY OF THE
ELECTRICAL DESIGN GROUP.
USE FIGURED DIMENSIONS
IN PREFERENCE TO SCALE.
ALL DIMENSIONS TO BE
VERIFIED ONSITE.

ELECTRICAL DESIGN GROUP
ELECTRICAL BUILDING SERVICES CONSULTANTS
BRISBANE GOLD COAST

P.O. Box 15, Sherwood Q.4075
Phone: (07) 3278 4375
Email: brisbane@edg.net.au
Web: www.edg.net.au

PROJECT:
**ST JOHNS ANGLICAN COLLEGE
FOREST LAKE - HEALTH & WELLBEING**

COLLEGE AVENUE, FOREST LAKE

B	TENDER	06/11/2023
REV.	DESCRIPTION:	DATE:

DRAWING:
**ELECTRICAL SERVICES
FLOOR PLAN**

SCALE:
1:50

AT A1

PROJECT NO:
C3144a

DRAWING NO:
E02

REVISION:
B