



**DETAIL A**  
KITCHENETTE ELEVATION 1  
SCALE 1:25

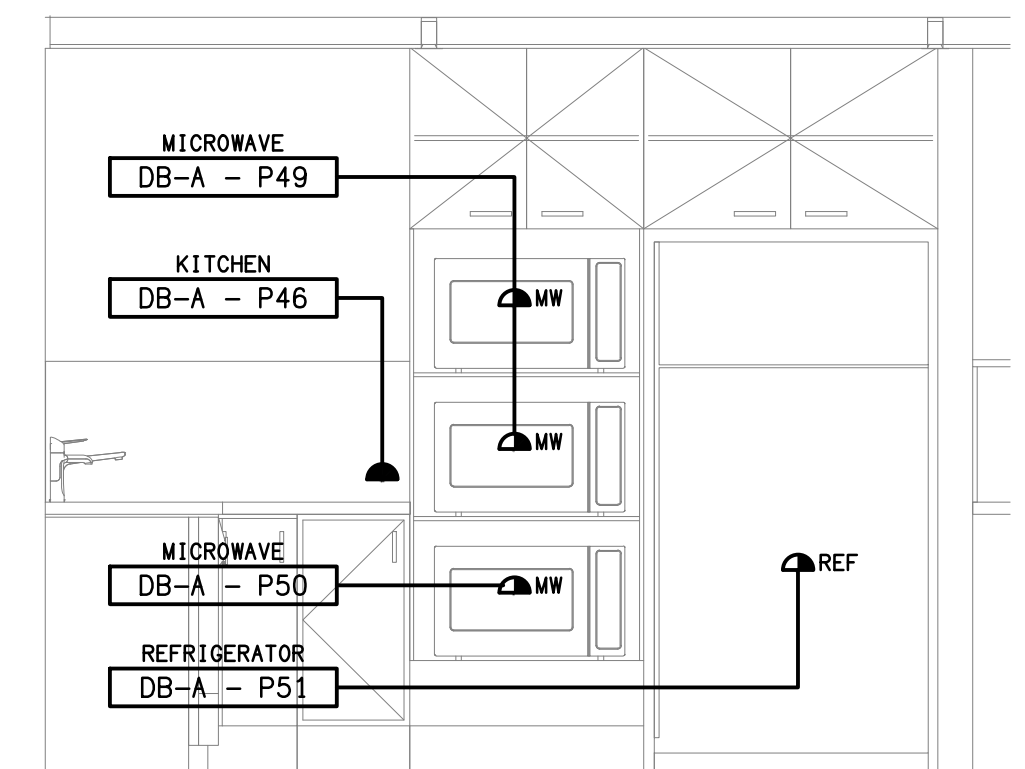

**DETAIL B**  
KITCHENETTE ELEVATION 2  
SCALE 1:25

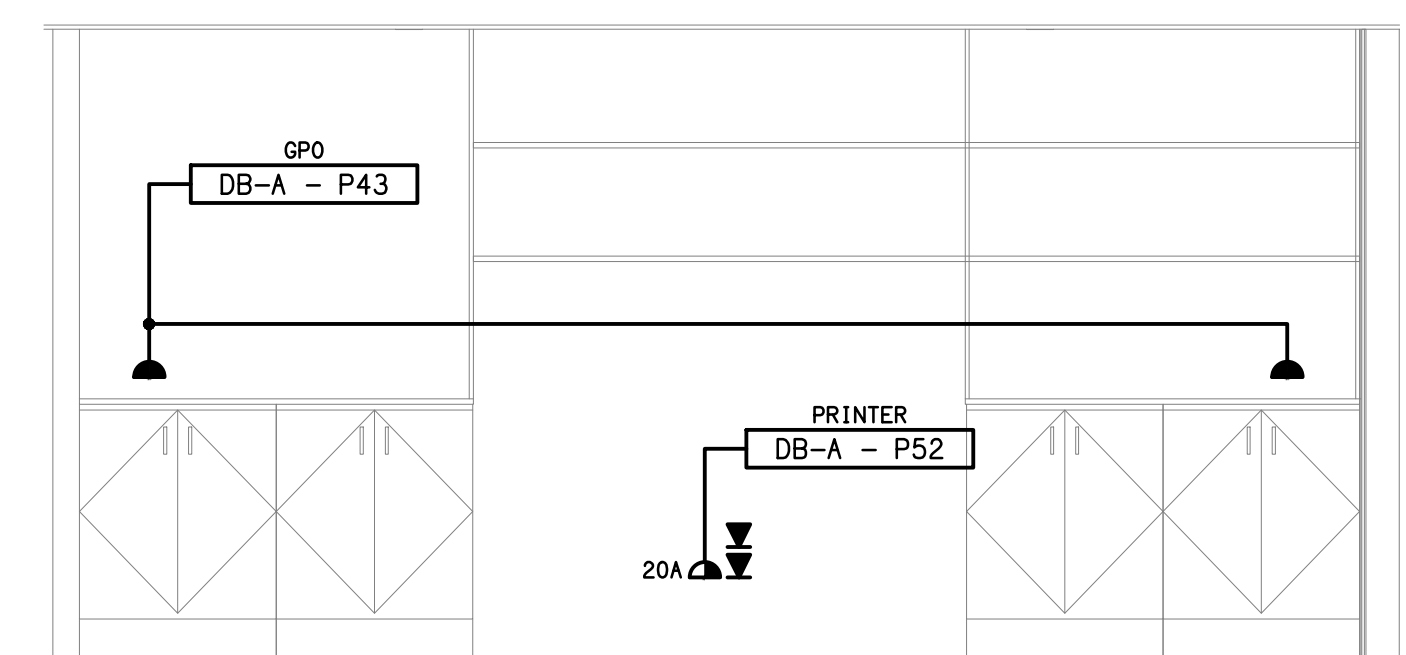

**DETAIL C**  
UTILITY BENCHES ELEVATION  
SCALE 1:25

ELECTRICAL DESIGN GROUP BRISBANE  
PTY LTD  
ACN 092 710 793  
TRADING AS:  
ELECTRICAL DESIGN GROUP

THE COPYRIGHT OF THIS DRAWING  
REMAINS THE PROPERTY OF THE  
ELECTRICAL DESIGN GROUP.  
USE FIGURED DIMENSIONS  
IN PREFERENCE TO SCALE.  
ALL DIMENSIONS TO BE  
VERIFIED ONSITE.

**ELECTRICAL DESIGN GROUP**  
ELECTRICAL BUILDING SERVICES CONSULTANTS  
BRISBANE GOLD COAST

P.O. Box 15, Sherwood Q.4075  
Phone: (07) 3278 4375  
Email: brisbane@edg.net.au  
Web: www.edg.net.au

PROJECT:  
78 MUSGRAVE ROAD, RED HILL

BRISBANE

B	TENDER	23/11/2023
REV.	DESCRIPTION:	DATE:

DRAWING:  
**ELECTRICAL SERVICES**  
GROUND FLOOR PLAN

SCALE:  
1:50 UNO

PROJECT NO:  
**C3148a**

DRAWING NO:  
**E05**

REVISION:  
**B**