


OPTION 2
REFLECTED CEILING PLAN
SCALE 1:50

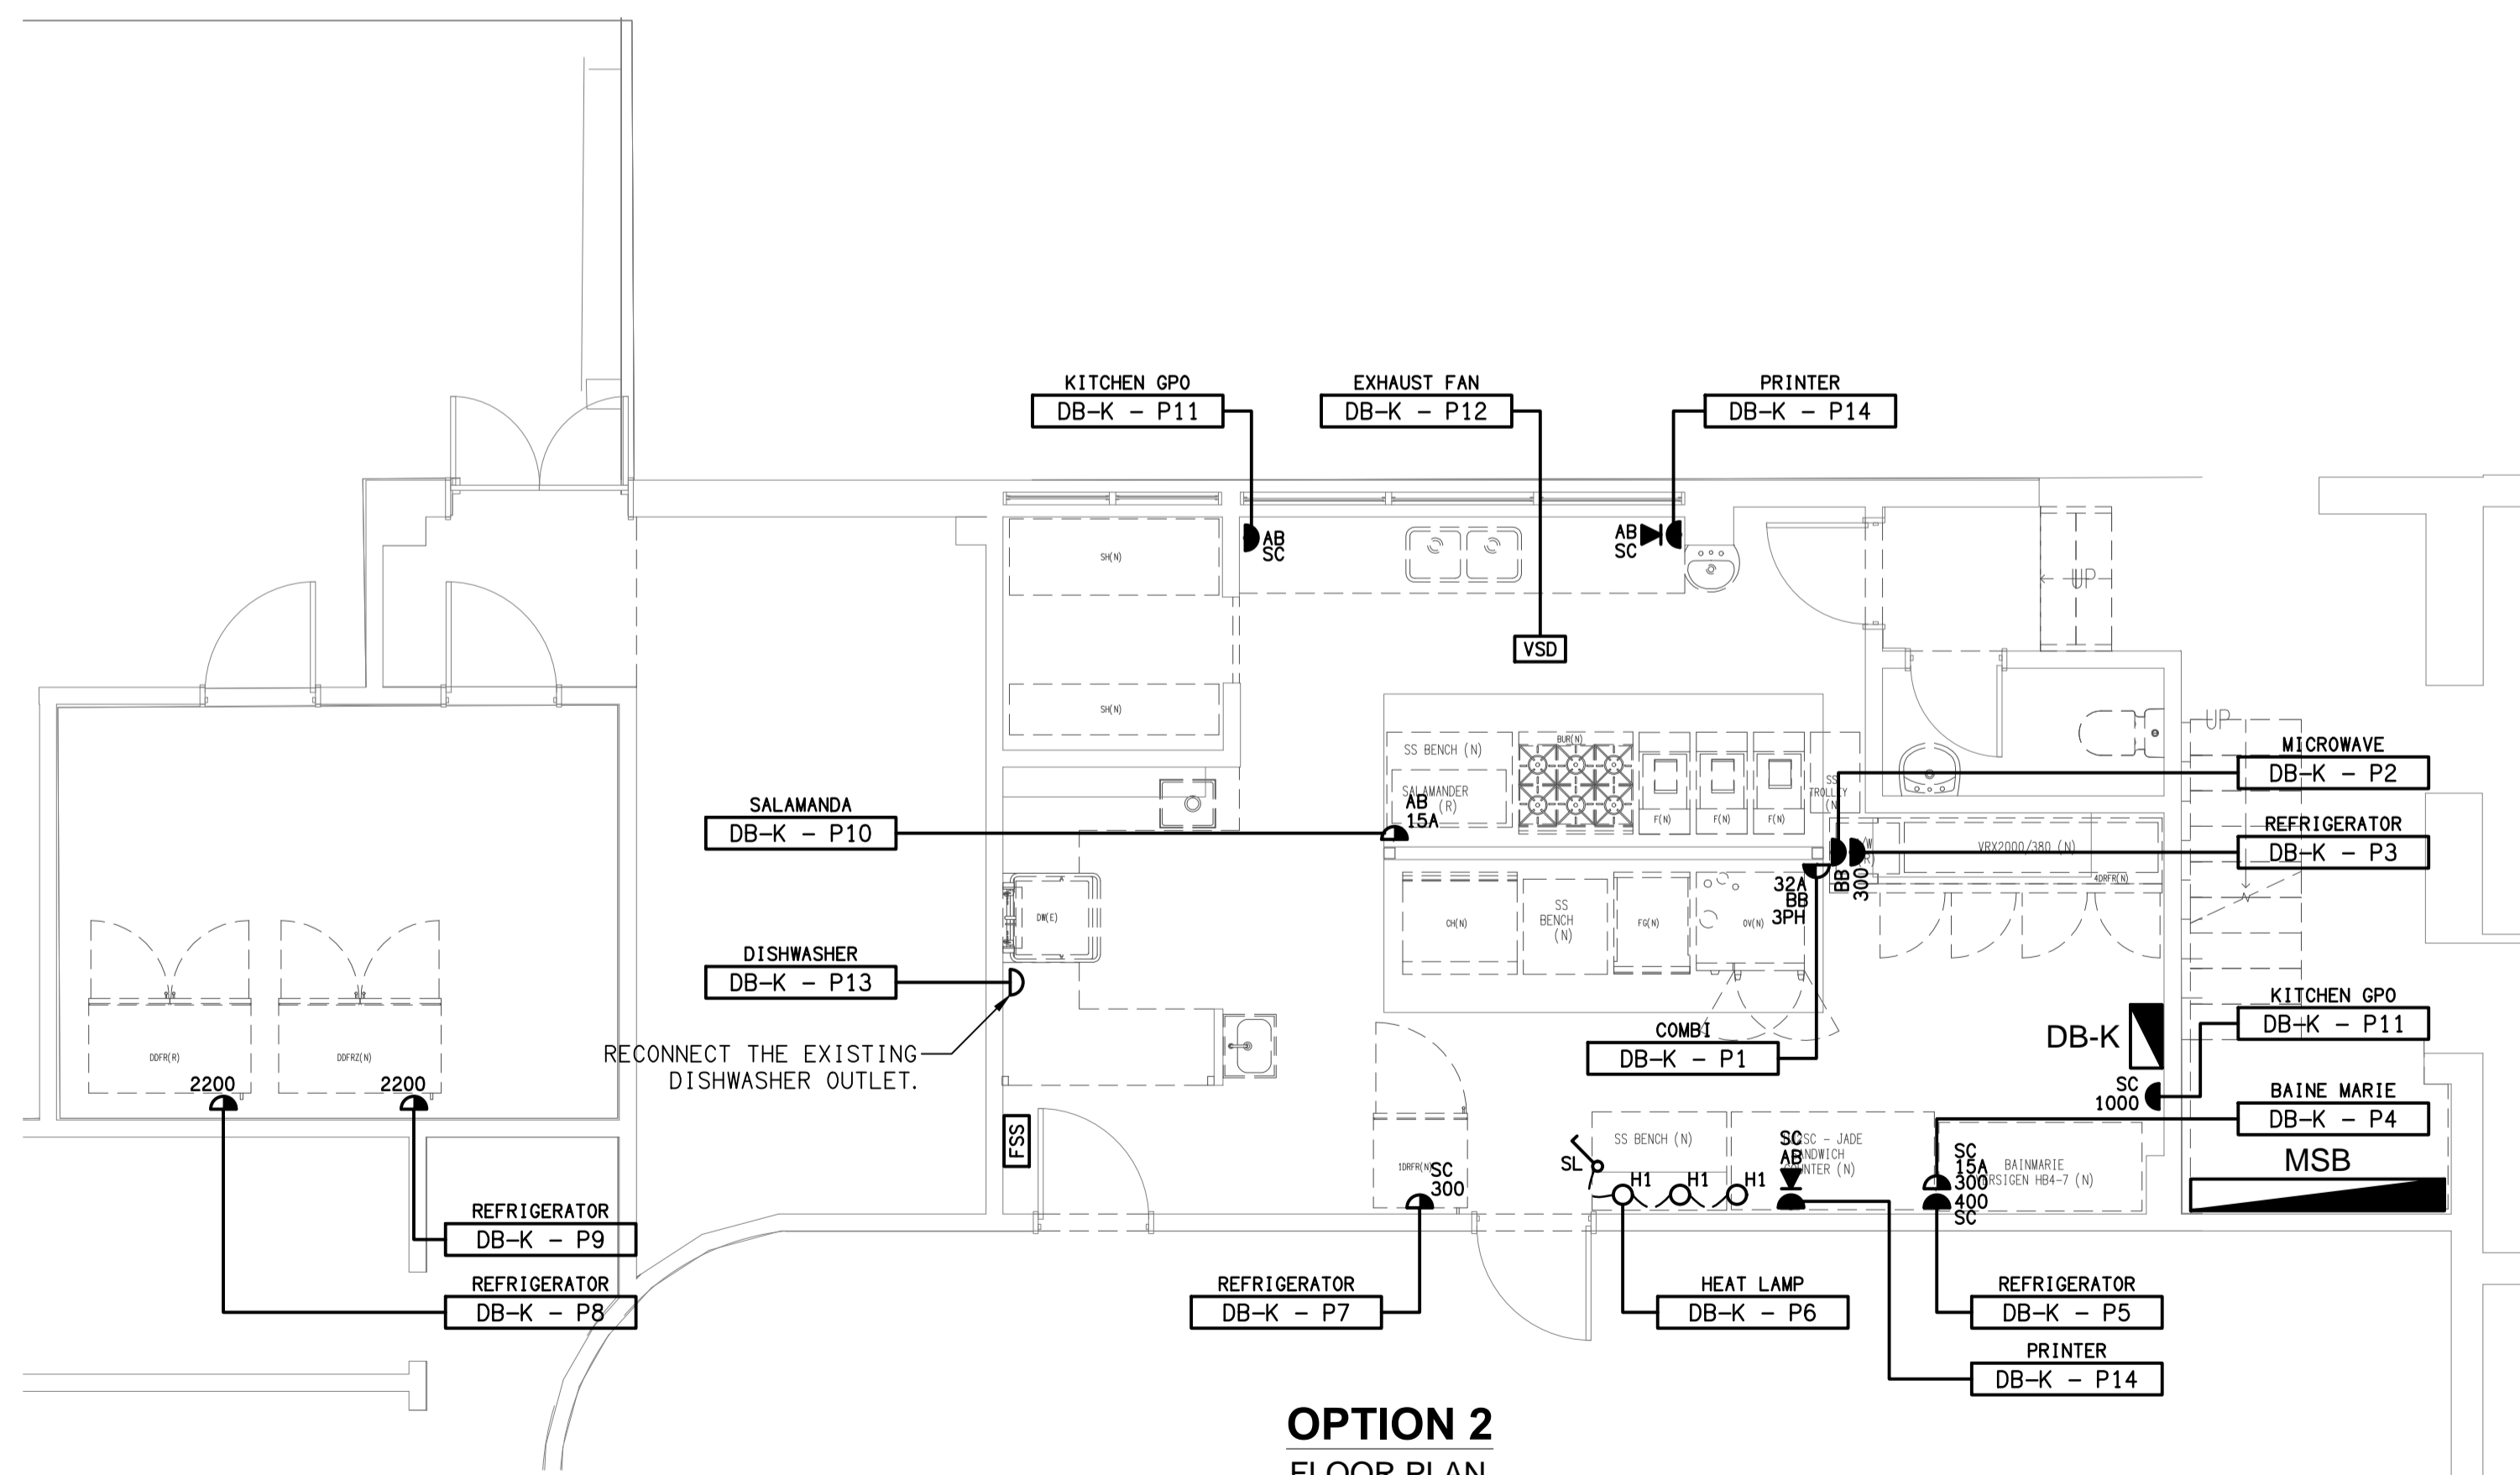

OPTION 2
FLOOR PLAN
SCALE 1:50

ELECTRICAL DESIGN GROUP BRISBANE
PTY LTD
ACN 092 710 793
TRADING AS:
ELECTRICAL DESIGN GROUP

THE COPYRIGHT OF THIS DRAWING
REMAINS THE PROPERTY OF THE
ELECTRICAL DESIGN GROUP.

USE FIGURED DIMENSIONS
IN PREFERENCE TO SCALE.

ALL DIMENSIONS TO BE
VERIFIED ONSITE.

ELECTRICAL DESIGN GROUP
ELECTRICAL BUILDING SERVICES CONSULTANTS
BRISBANE GOLD COAST

P.O. Box 15, Sherwood Q.4075
Phone: (07) 3278 4375
Email: brisbane@edg.net.au
Web: www.edg.net.au

PROJECT:
LEE'S HOTEL, INGHAM - KITCHEN UPGRADE

LANNERCOST STREET, INGHAM, QUEENSLAND

B	TENDER	20/11/2023
REV:	DESCRIPTION:	DATE:

DRAWING: ELECTRICAL SERVICES		
OPTION 2		
FLOOR PLAN & REFLECTED CEILING PLAN		
SCALE: 1:50	AT A1	REVISION: B
PROJECT NO: C3165a	DRAWING NO: E03	