



**BEER GARDEN
REFURBISHMENT**

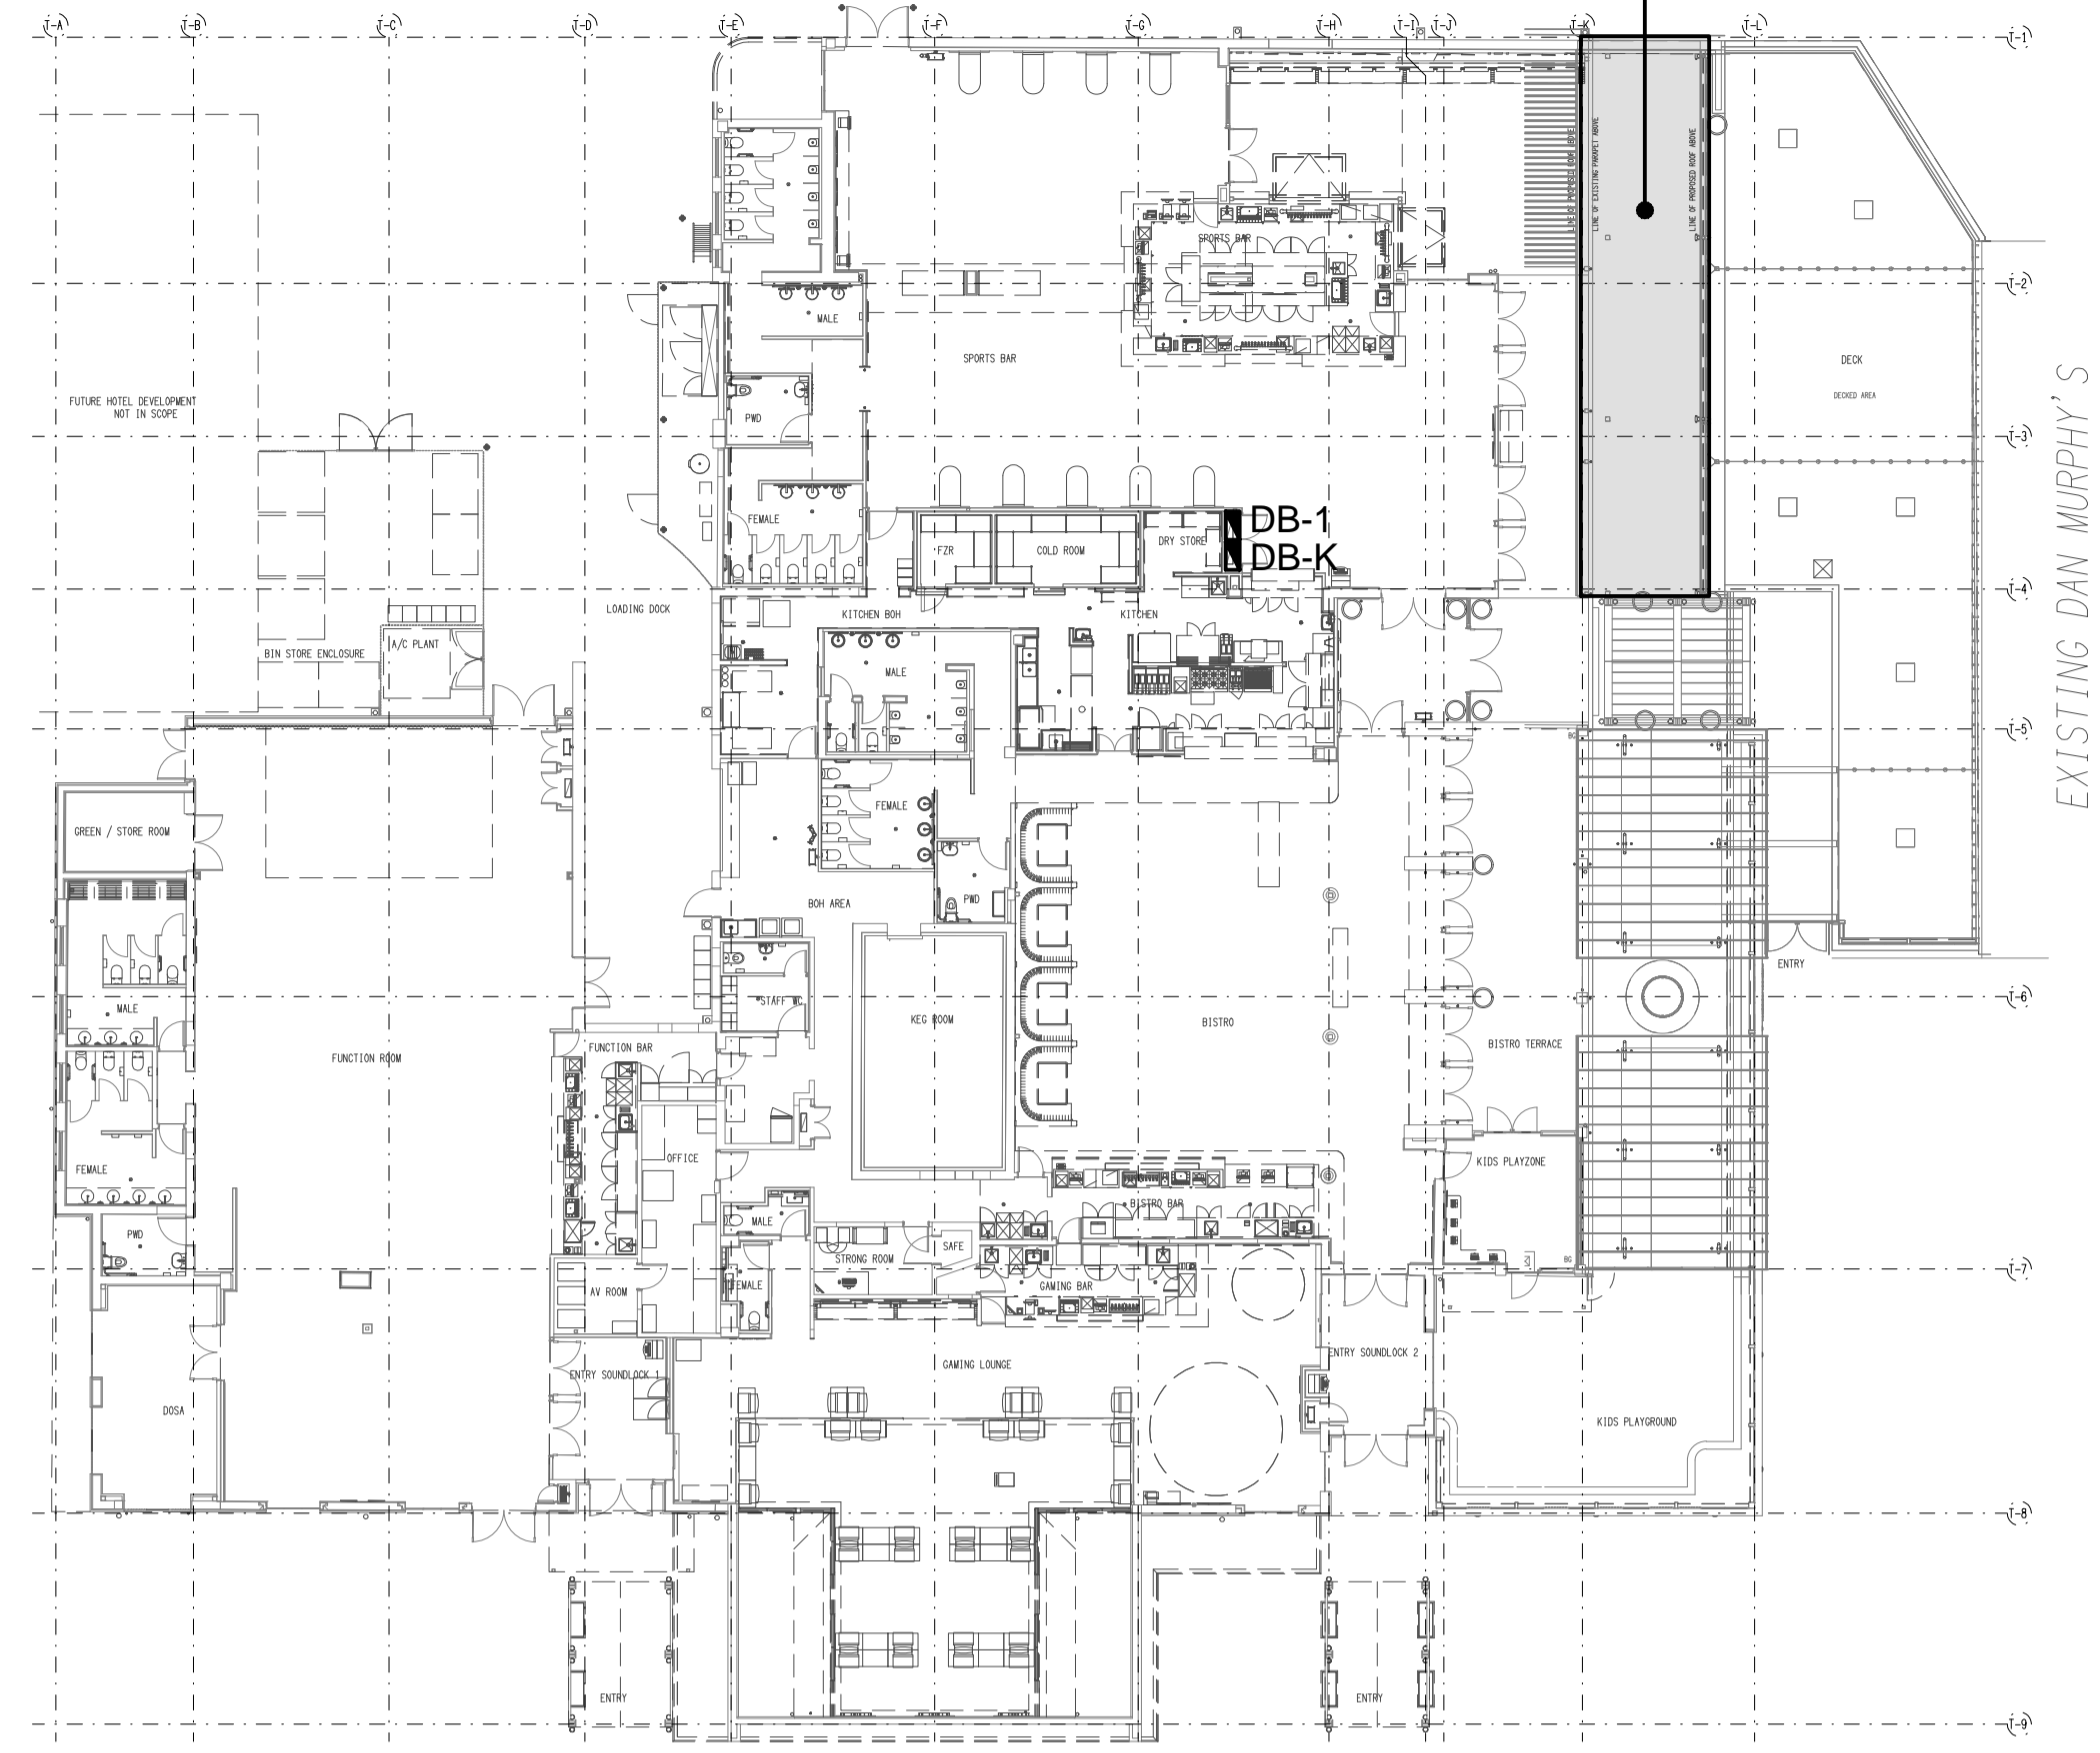

SITE PLAN
BEER GARDEN REFURBISHMENT
SCALE 1:250

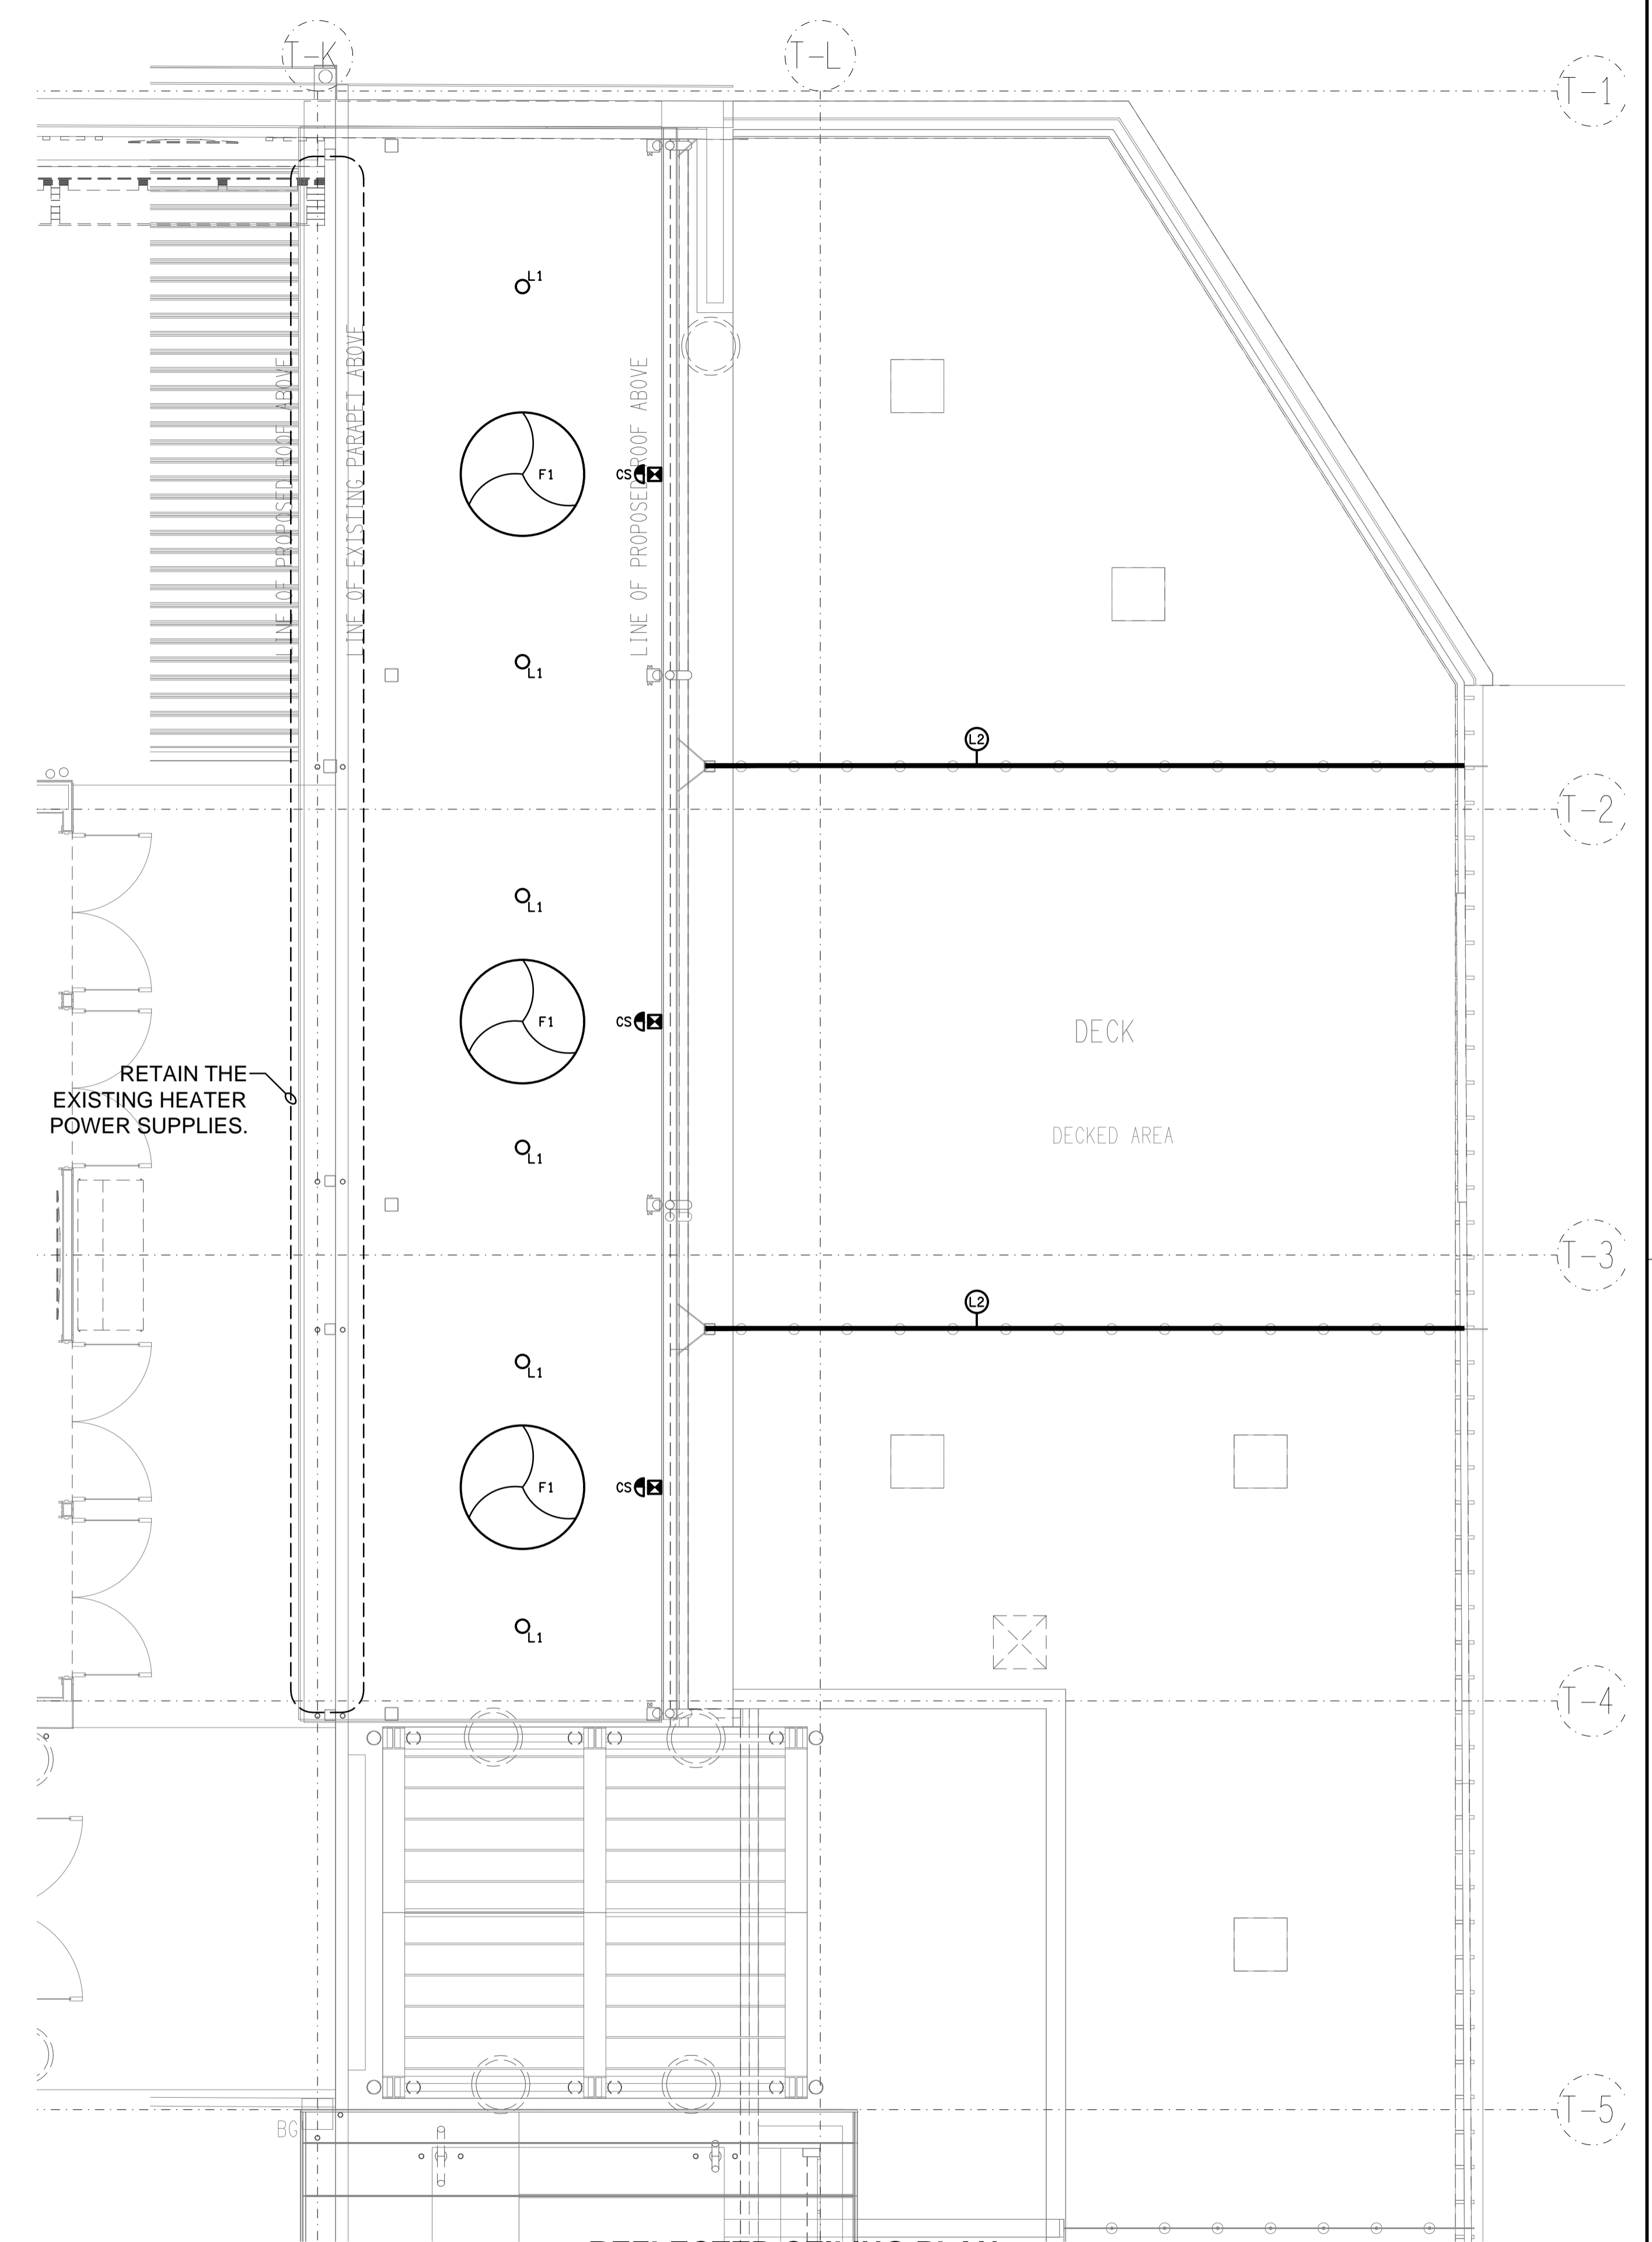

REFLECTED CEILING PLAN
BEER GARDEN REFURBISHMENT
SCALE 1:50

ELECTRICAL DESIGN GROUP BRISBANE
PTY LTD
ACN 092 710 793
TRADING AS:
ELECTRICAL DESIGN GROUP

THE COPYRIGHT OF THIS DRAWING
REMAINS THE PROPERTY OF THE
ELECTRICAL DESIGN GROUP.
USE FIGURED DIMENSIONS
IN PREFERENCE TO SCALE.
ALL DIMENSIONS TO BE
VERIFIED ONSITE.

ELECTRICAL DESIGN GROUP
ELECTRICAL BUILDING SERVICES CONSULTANTS
BRISBANE GOLD COAST

P.O. Box 15, Sherwood Q.4075
Phone: (07) 3278 4375
Email: brisbane@edg.net.au
Web: www.edg.net.au

PROJECT:
THE FOREST HOTEL - BEER GARDEN
5 FRENCHS FOREST ROAD EAST, FRENCHS FOREST NSW

A	PRELIMINARY	20/12/2023
REV:	DESCRIPTION:	DATE:
DRAWING: ELECTRICAL SERVICES REFLECTED CEILING PLAN		
SCALE: 1:50 & 1:250	AT A1	PROJECT NO: C3178a
		DRAWING NO: E02
		REVISION: A