
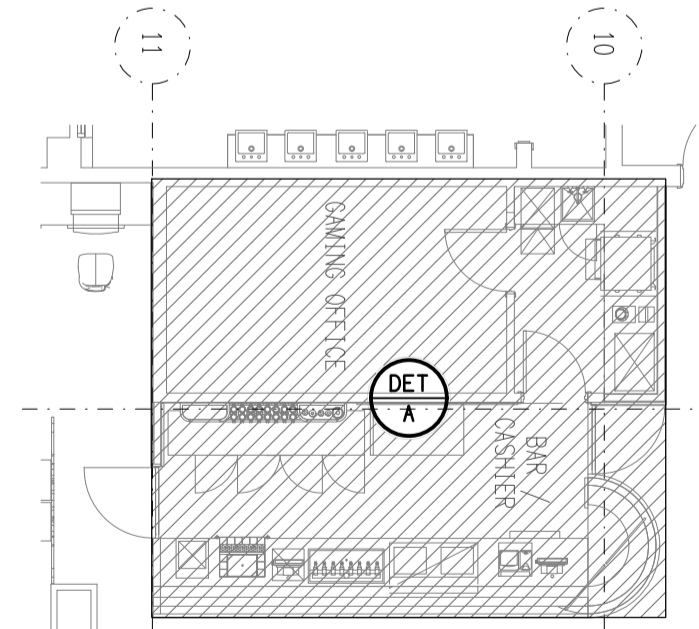


DETAIL A
 BAR / CASHIER FLOOR PLAN
 SCALE 1:50

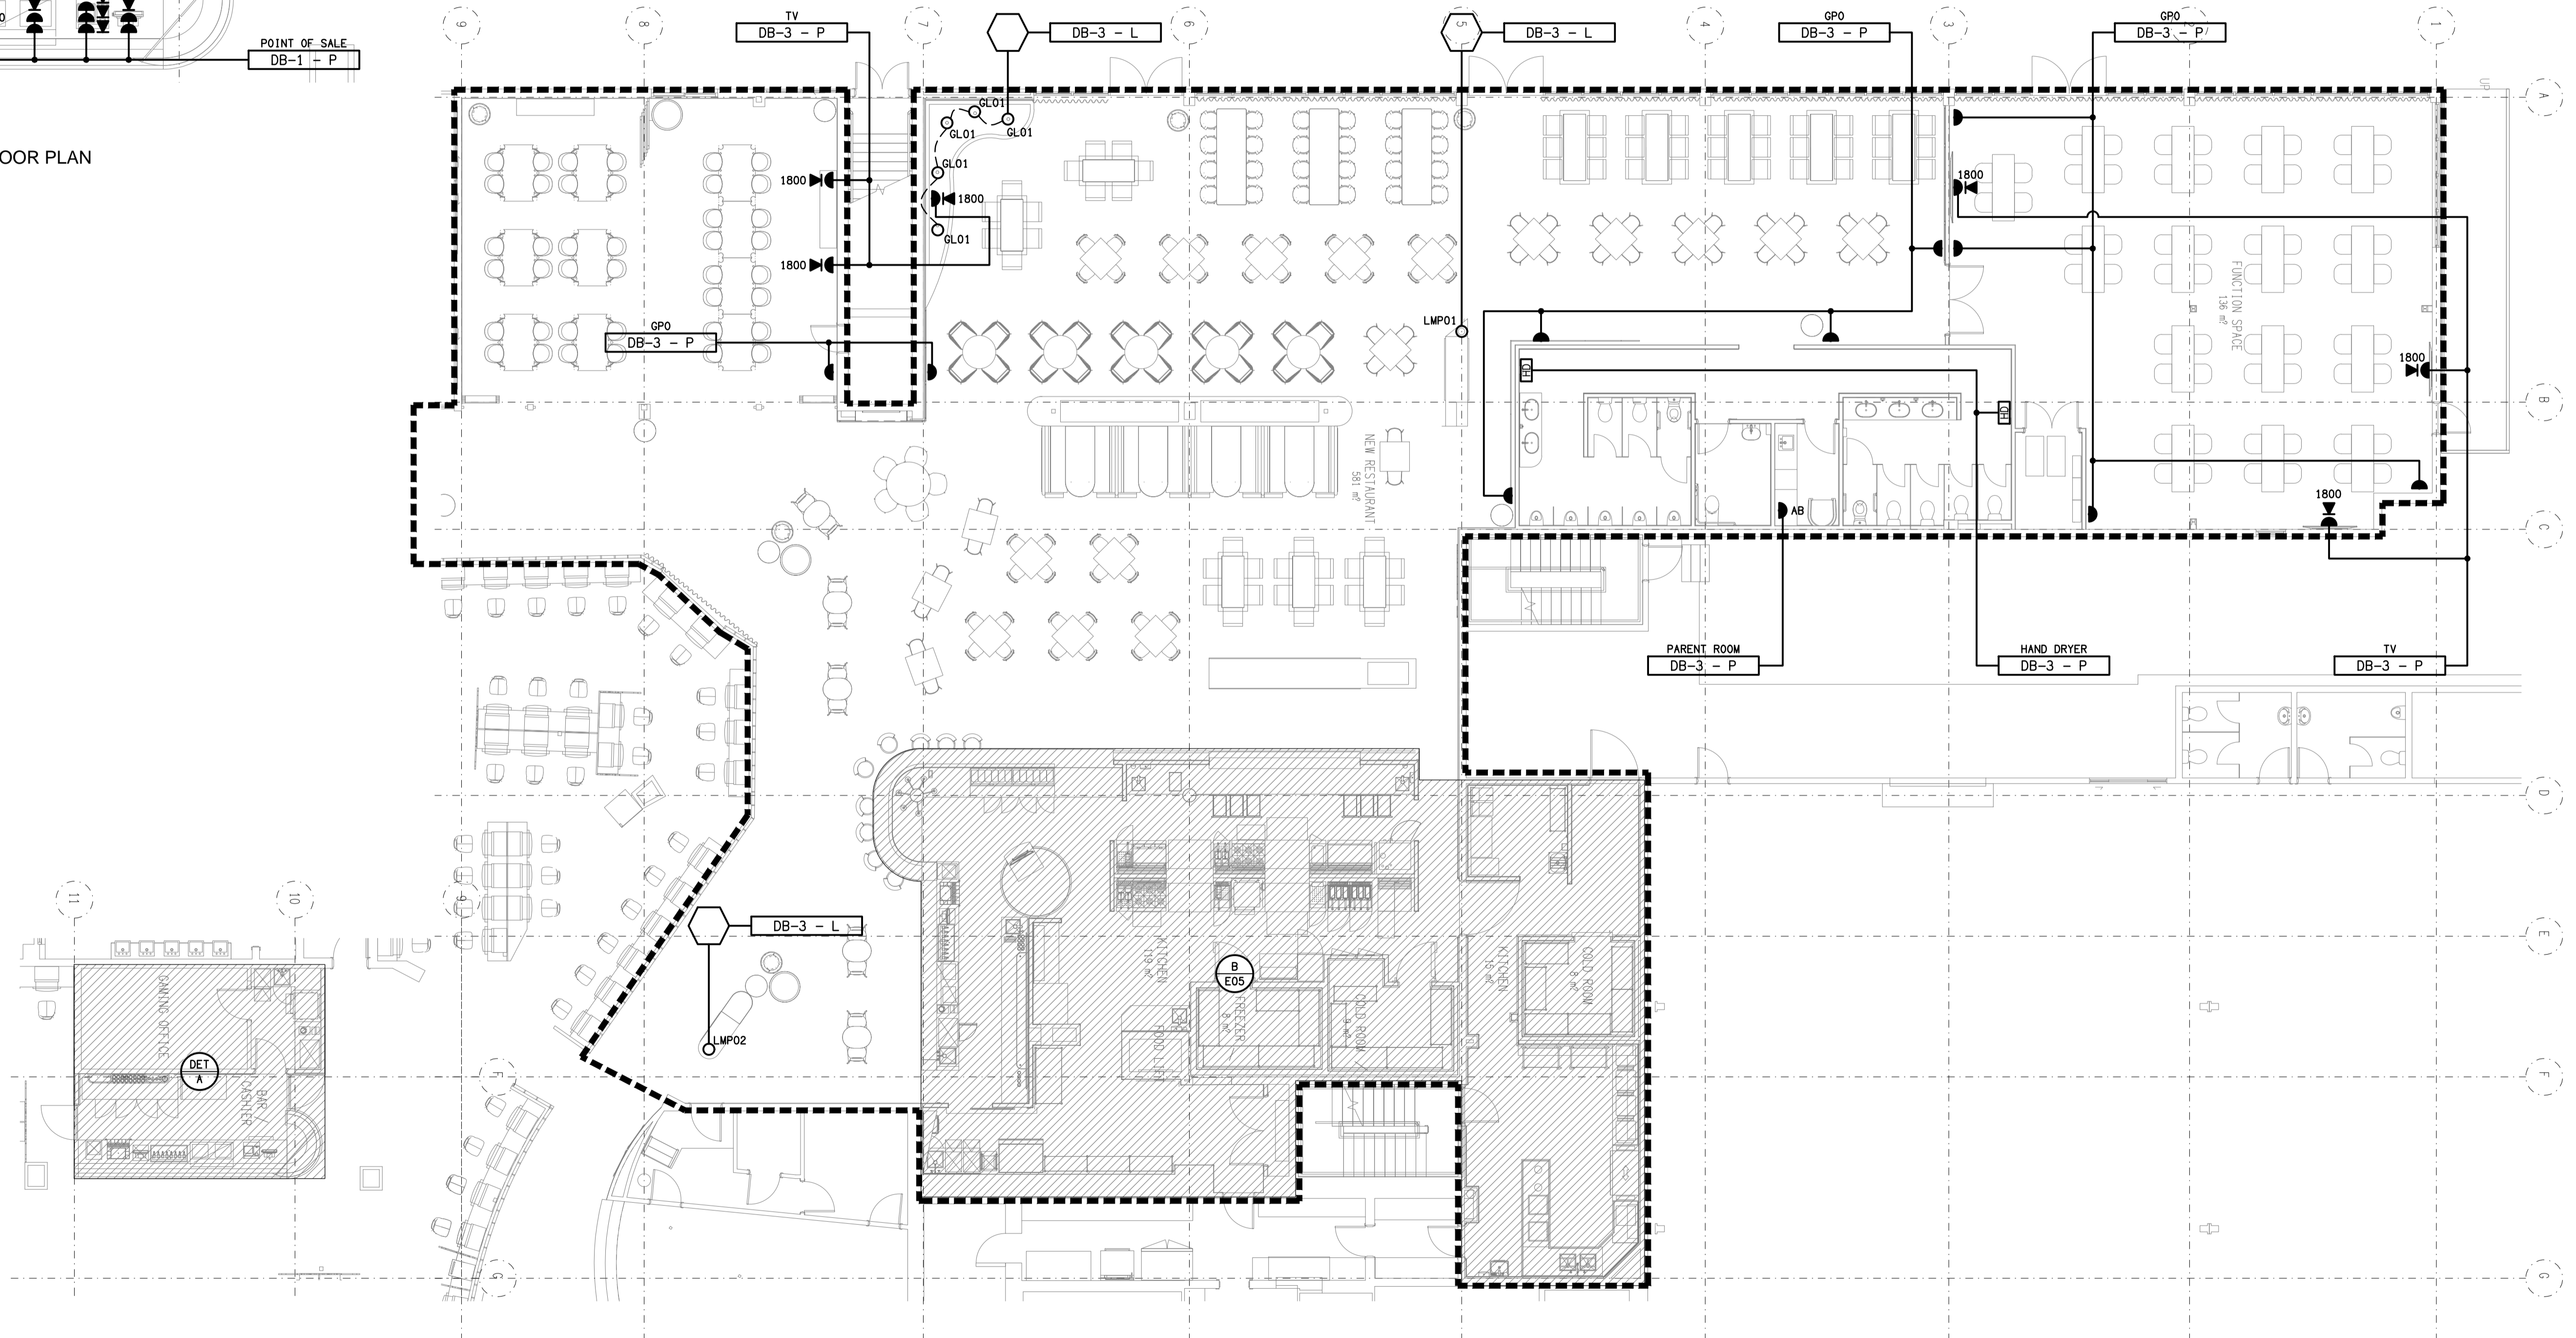

ELECTRICAL DESIGN GROUP BRISBANE
 PTY LTD
 ACN 092 710 793
 TRADING AS:
 ELECTRICAL DESIGN GROUP

THE COPYRIGHT OF THIS DRAWING
 REMAINS THE PROPERTY OF THE
 ELECTRICAL DESIGN GROUP.
 USE FIGURED DIMENSIONS
 IN PREFERENCE TO SCALE.
 ALL DIMENSIONS TO BE
 VERIFIED ONSITE.

ELECTRICAL DESIGN GROUP
 ELECTRICAL BUILDING SERVICES CONSULTANTS
 BRISBANE GOLD COAST
 P.O. Box 15, Sherwood Q.4075
 Phone: (07) 3278 4375
 Email: brisbane@edg.net.au
 Web: www.edg.net.au

PROJECT:
**REDLANDS SPORTING CLUB
 REFURBISHMENT**
 ANSON ROAD, WELLINGTON POINT, QUEENSLAND

A	PRELIMINARY	10/04/2024
REV.	DESCRIPTION:	DATE:
DRAWING: ELECTRICAL SERVICES FLOOR PLAN		
SCALE: 1:100 & 1:50	AT A1	PROJECT NO: C3204a
		DRAWING NO: E04
		REVISION: A