



DETAIL B
GAMING BAR COUNTER ELEVATION
SCALE 1:50


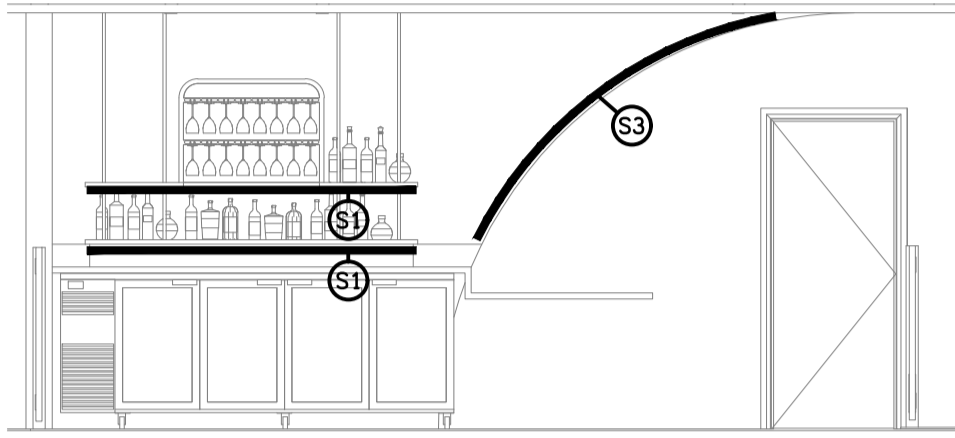


DETAIL C
GAMING BAR REAR WALL ELEVATION
SCALE 1:50

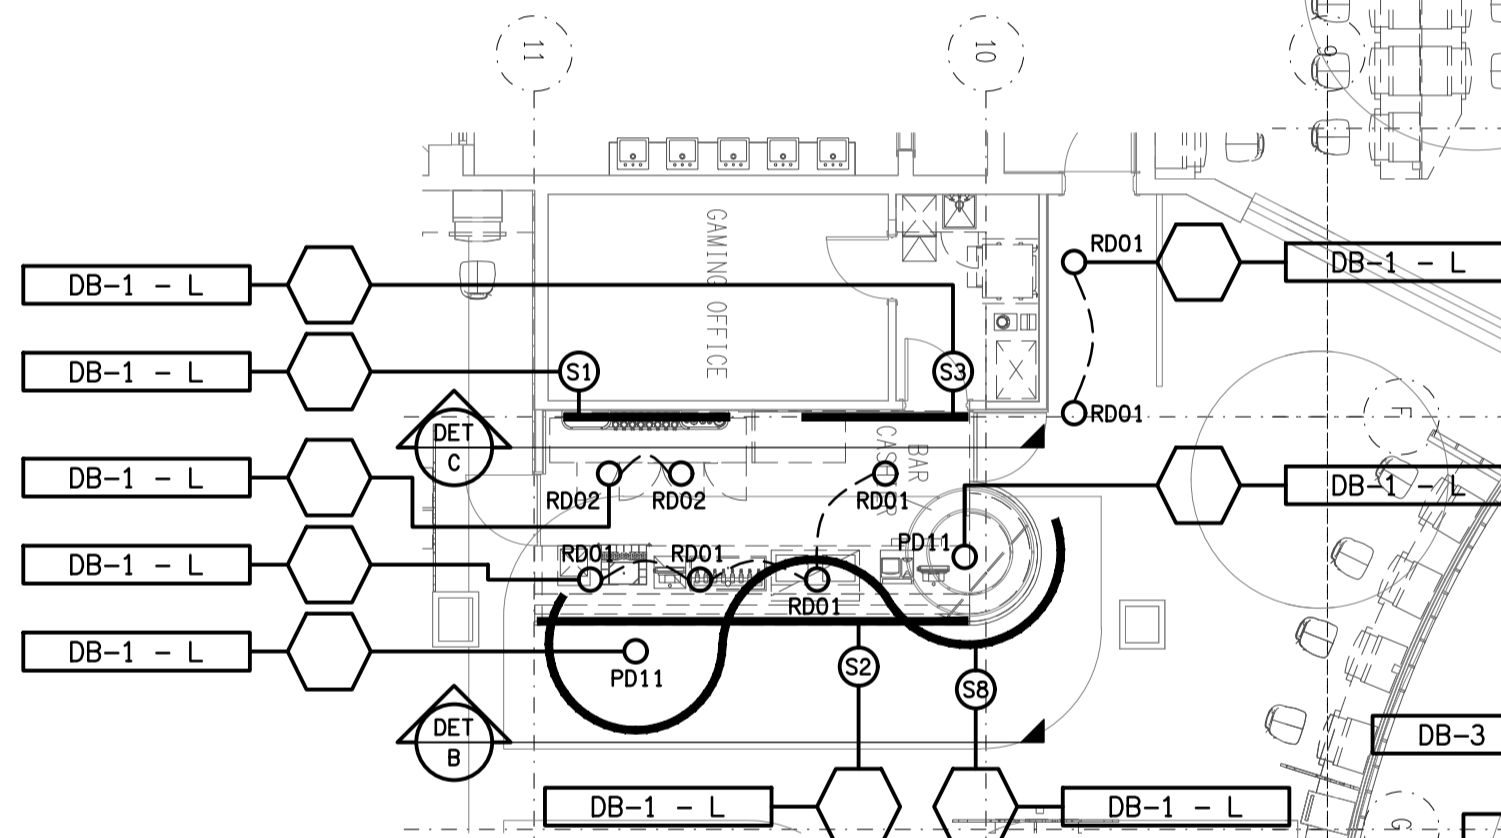


REFLECTED CEILING PLAN
REFURBISHMENT
SCALE 1:100

DETAIL F
SERVERY HEAT LAMP PLAN
SCALE 1:100

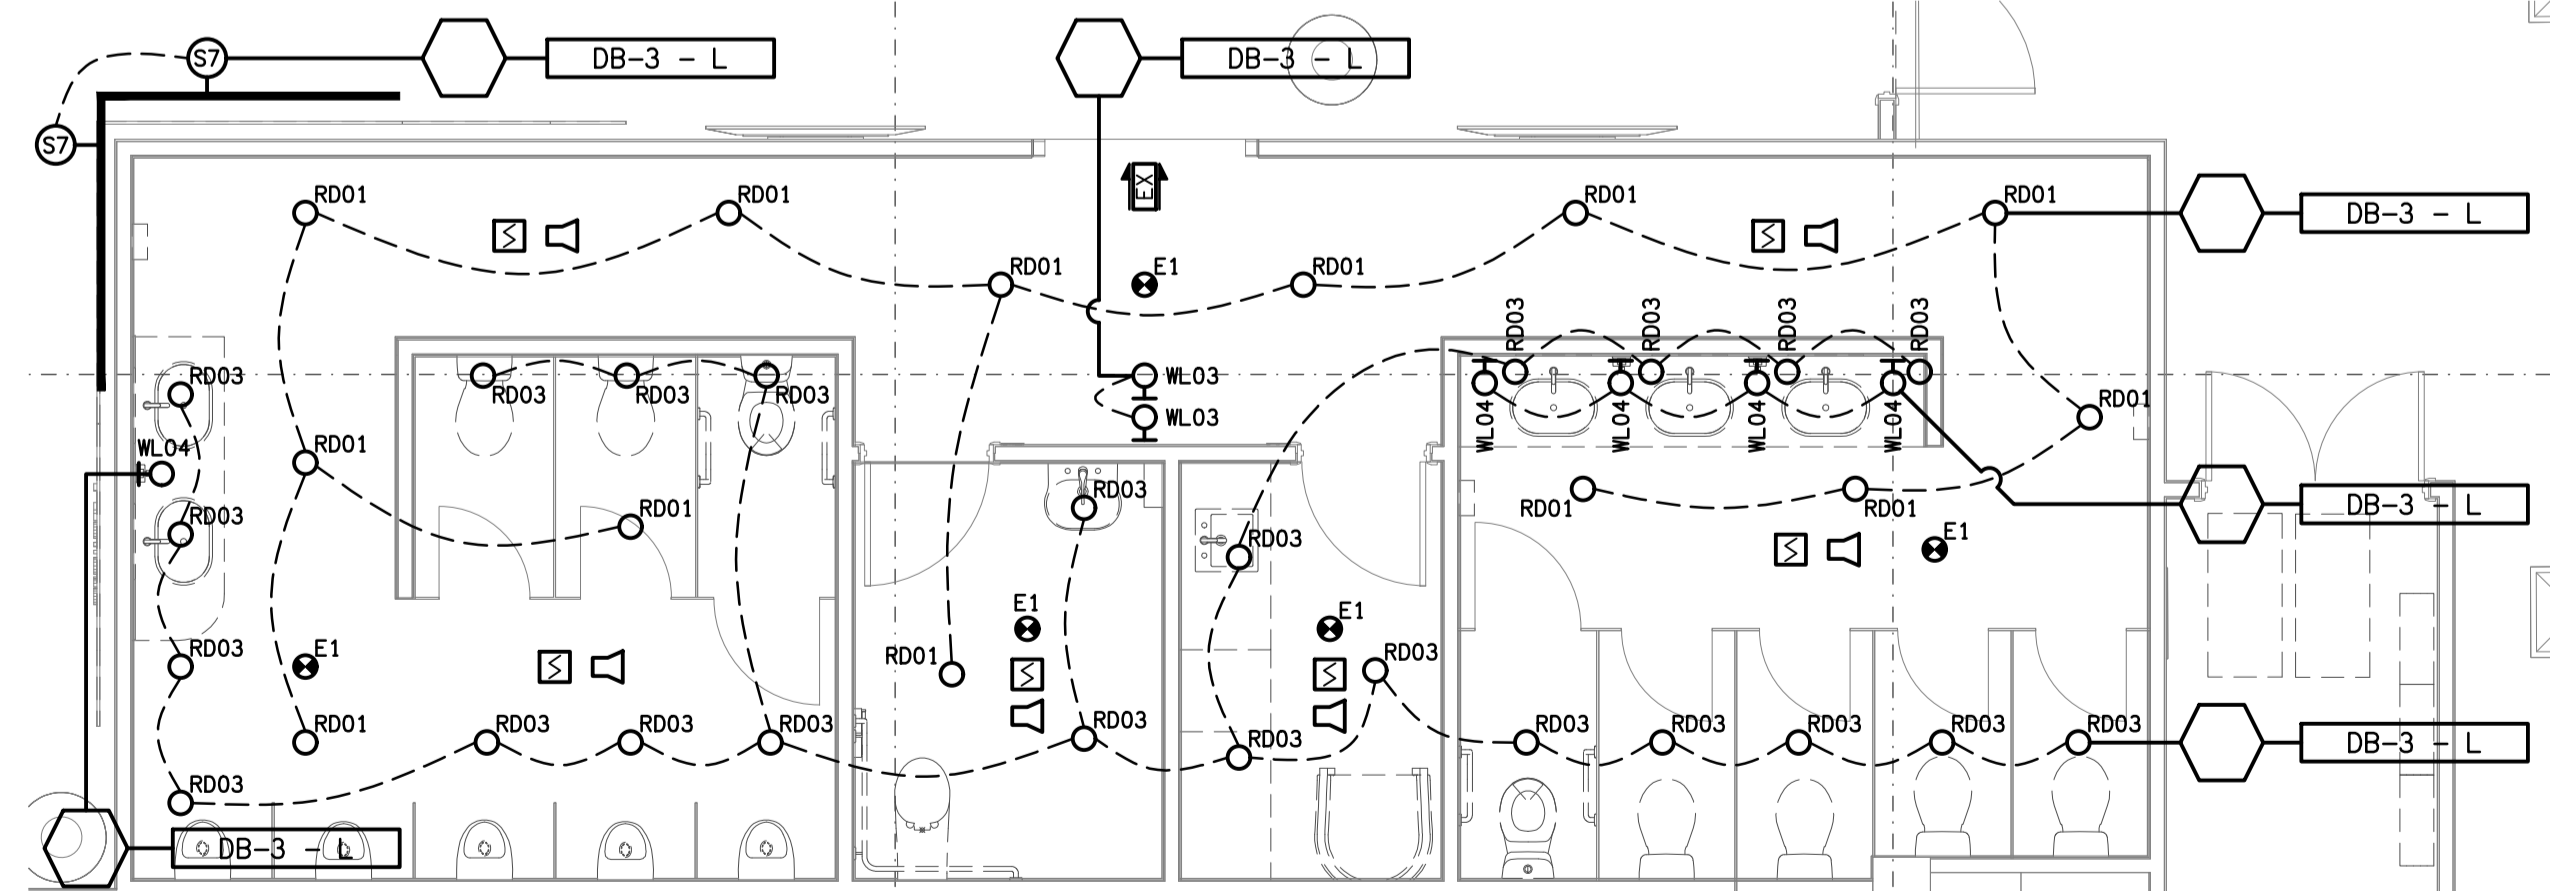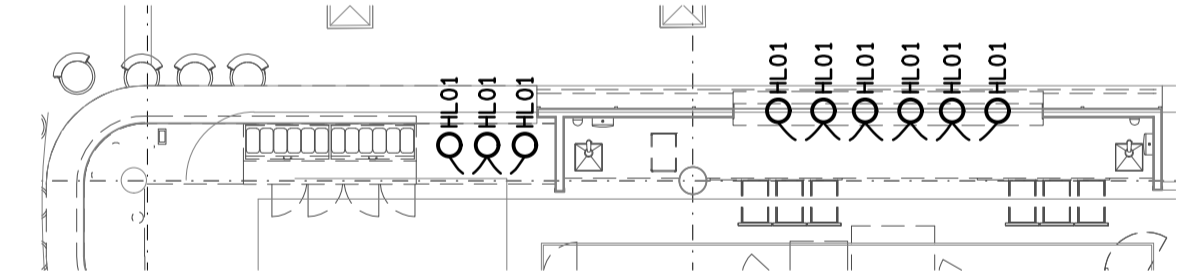


DETAIL A
AMENITIES REFLECTED CEILING PLAN
SCALE 1:50

DETAIL D
BAR COUNTER ELEVATION
SCALE 1:50

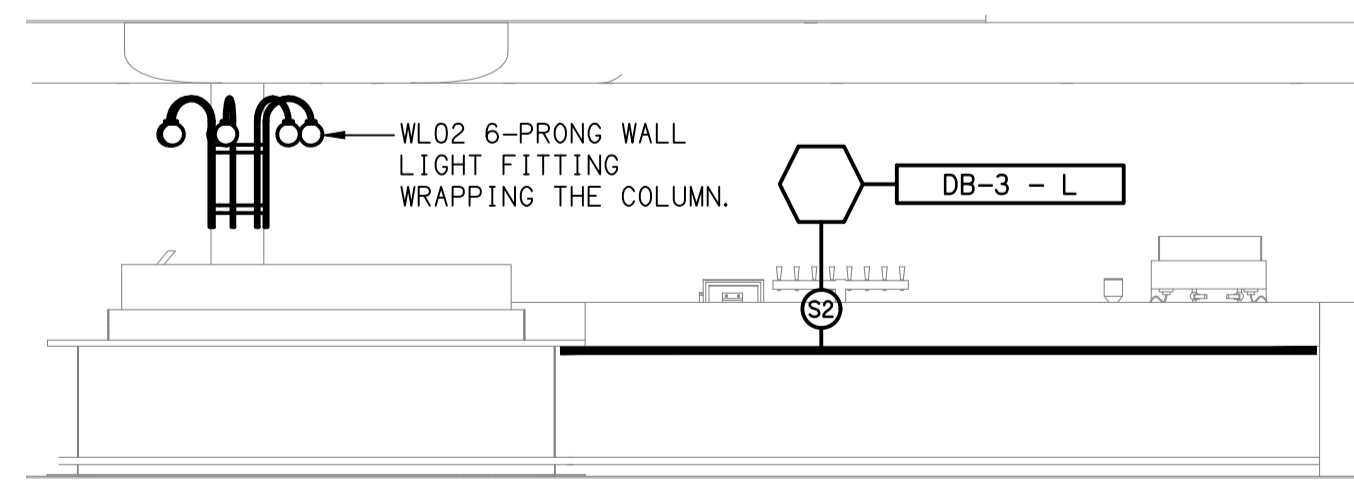

DETAIL E
BAR REAR WALL SHELVING ELEVATION
SCALE 1:50

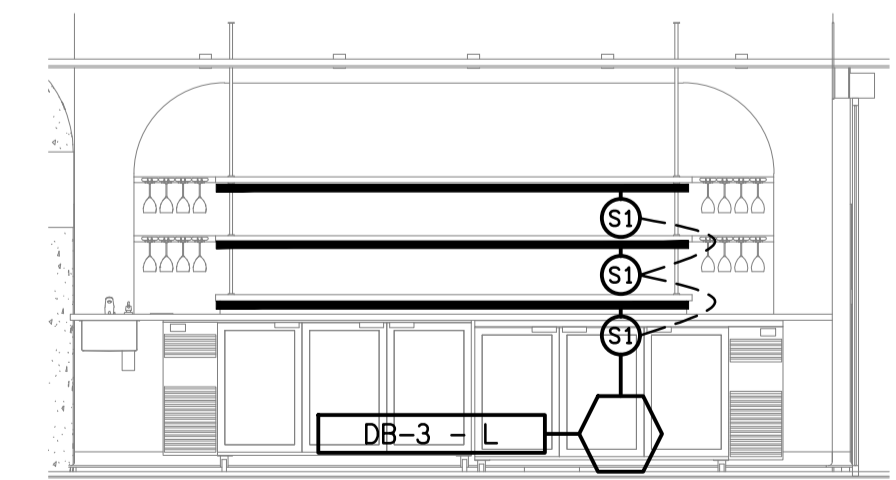

ELECTRICAL DESIGN GROUP BRISBANE
PTY LTD
ACN 092 710 793
TRADING AS:
ELECTRICAL DESIGN GROUP

THE COPYRIGHT OF THIS DRAWING
REMAINS THE PROPERTY OF THE
ELECTRICAL DESIGN GROUP.
USE FIGURED DIMENSIONS
IN PREFERENCE TO SCALE.
ALL DIMENSIONS TO BE
VERIFIED ONSITE.

ELECTRICAL DESIGN GROUP
ELECTRICAL BUILDING SERVICES CONSULTANTS
BRISBANE GOLD COAST

P.O. Box 15, Sherwood Q. 4075
Phone: (07) 3278 4375
Email: brisbane@edg.net.au
Web: www.edg.net.au

PROJECT:
**REDLANDS SPORTING CLUB
REFURBISHMENT**

ANSON ROAD, WELLINGTON POINT, QUEENSLAND

A	PRELIMINARY	10/04/2024
REV:	DESCRIPTION:	DATE:

DRAWING:
**ELECTRICAL SERVICES
REFLECTED CEILING PLAN**

SCALE: 1:100 & 1:50	AT A1	PROJECT NO: C3204a	DRAWING NO: E06	REVISION: A
------------------------	-------	------------------------------	---------------------------	-----------------------