




**STORAGE ROOMS**  
LOWER GROUND PLAN  
SCALE 1:100

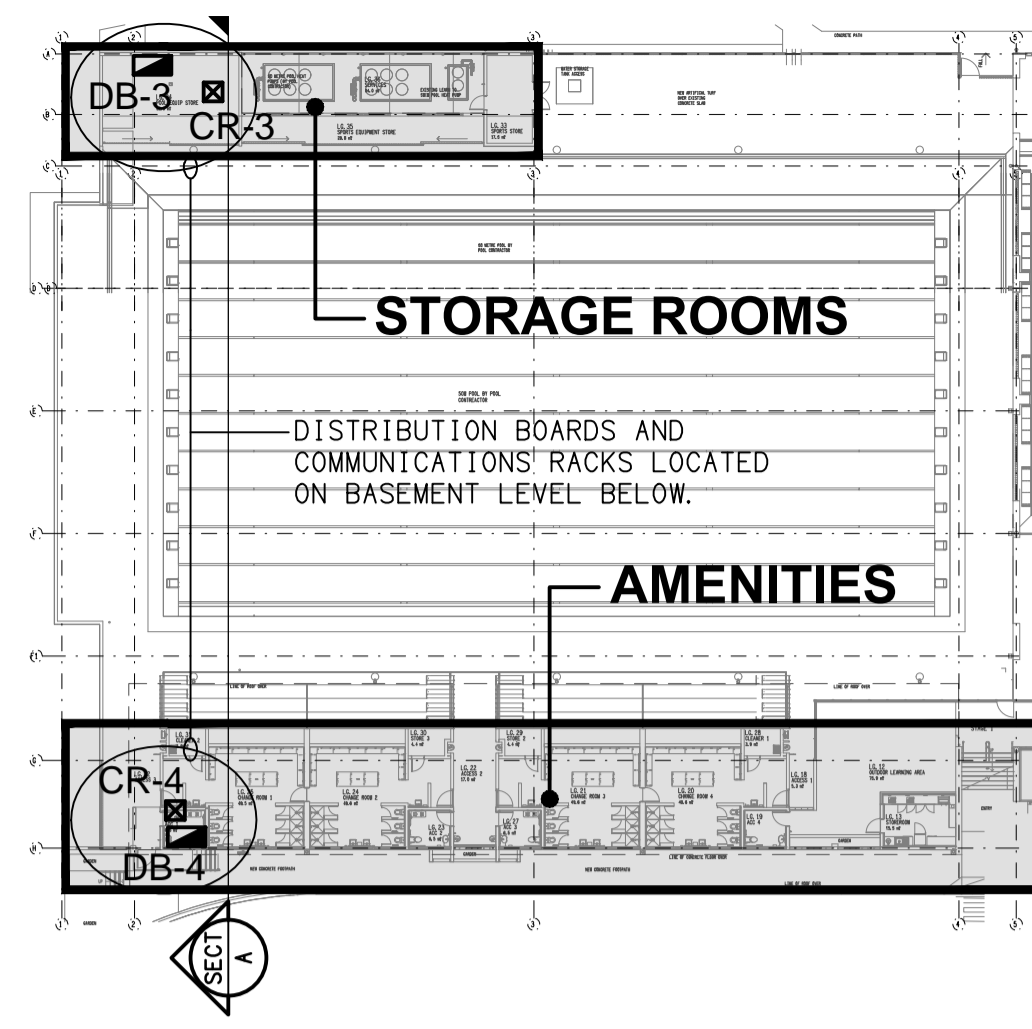


**REFERENCE PLAN**  
LOWER GROUND STORAGE & AMENITIES  
SCALE 1:500

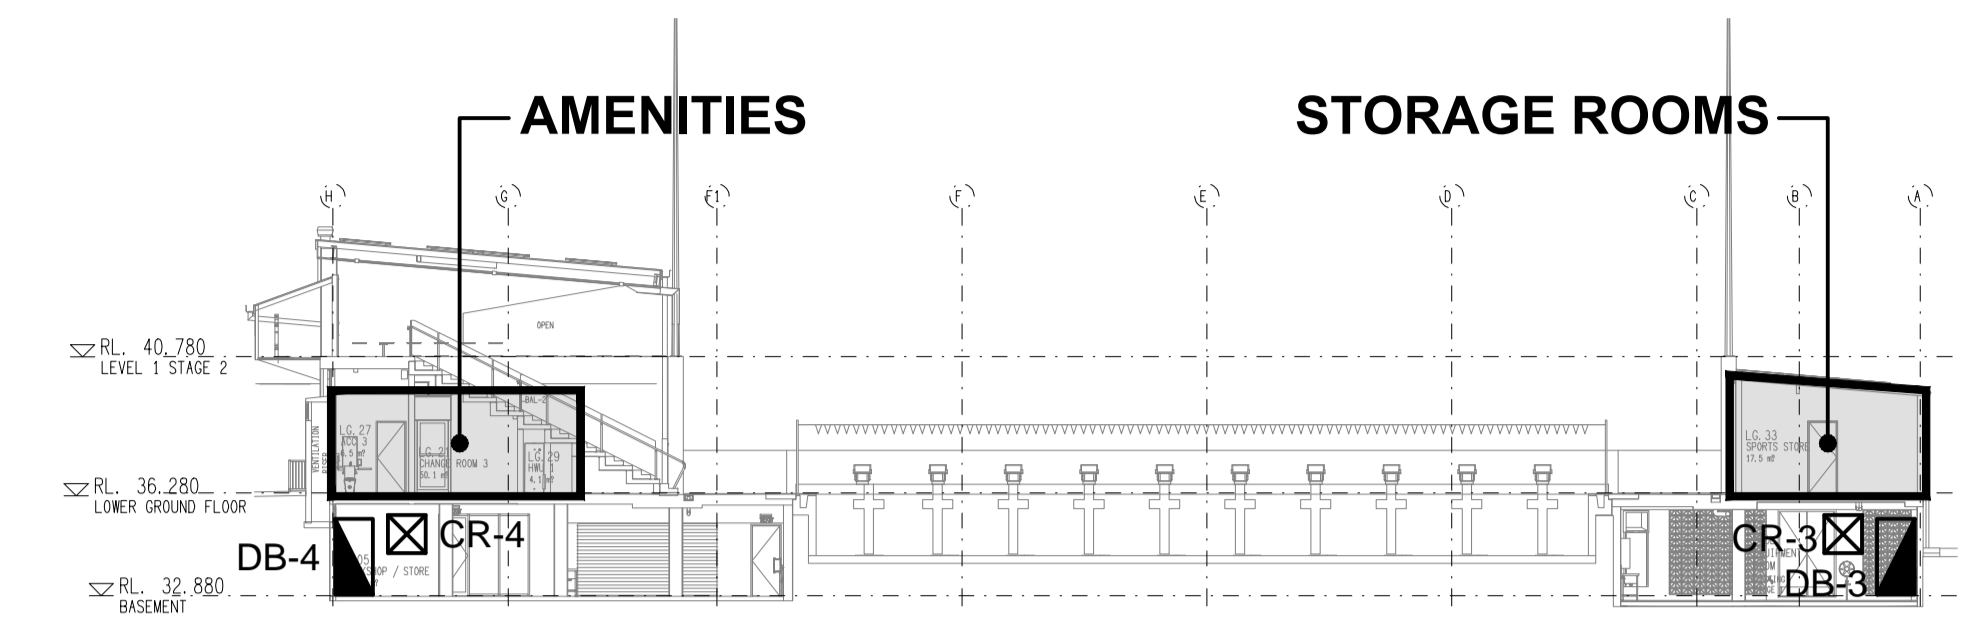


**SECTION A**  
LOWER GROUND STORAGE & AMENITIES  
SCALE 1:250

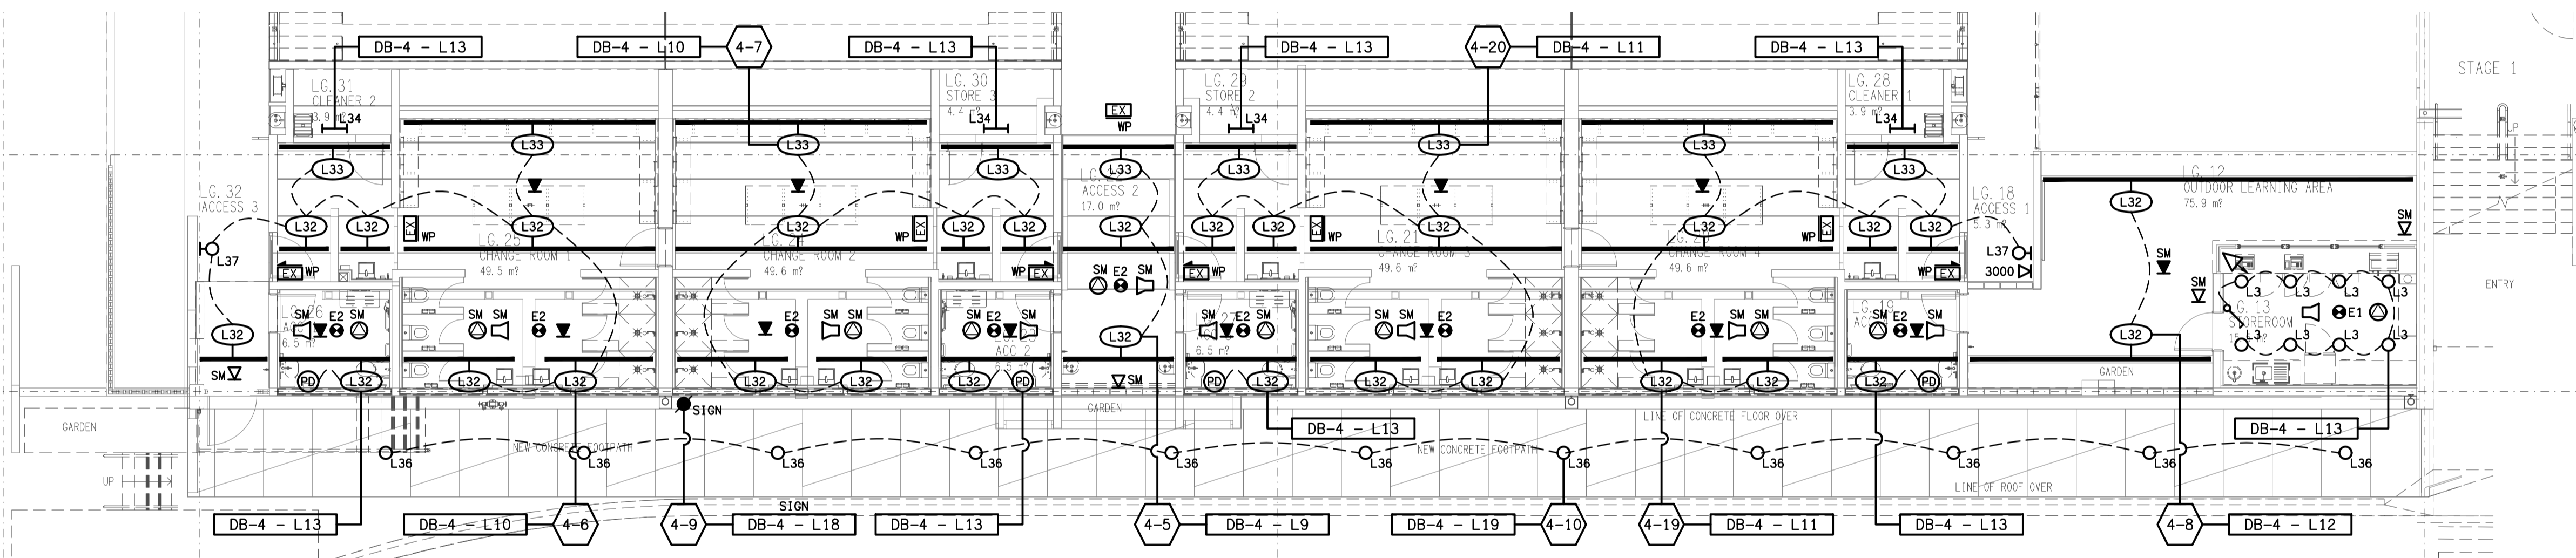


**AMENITIES**  
LOWER GROUND REFLECTED CEILING PLAN  
SCALE 1:100

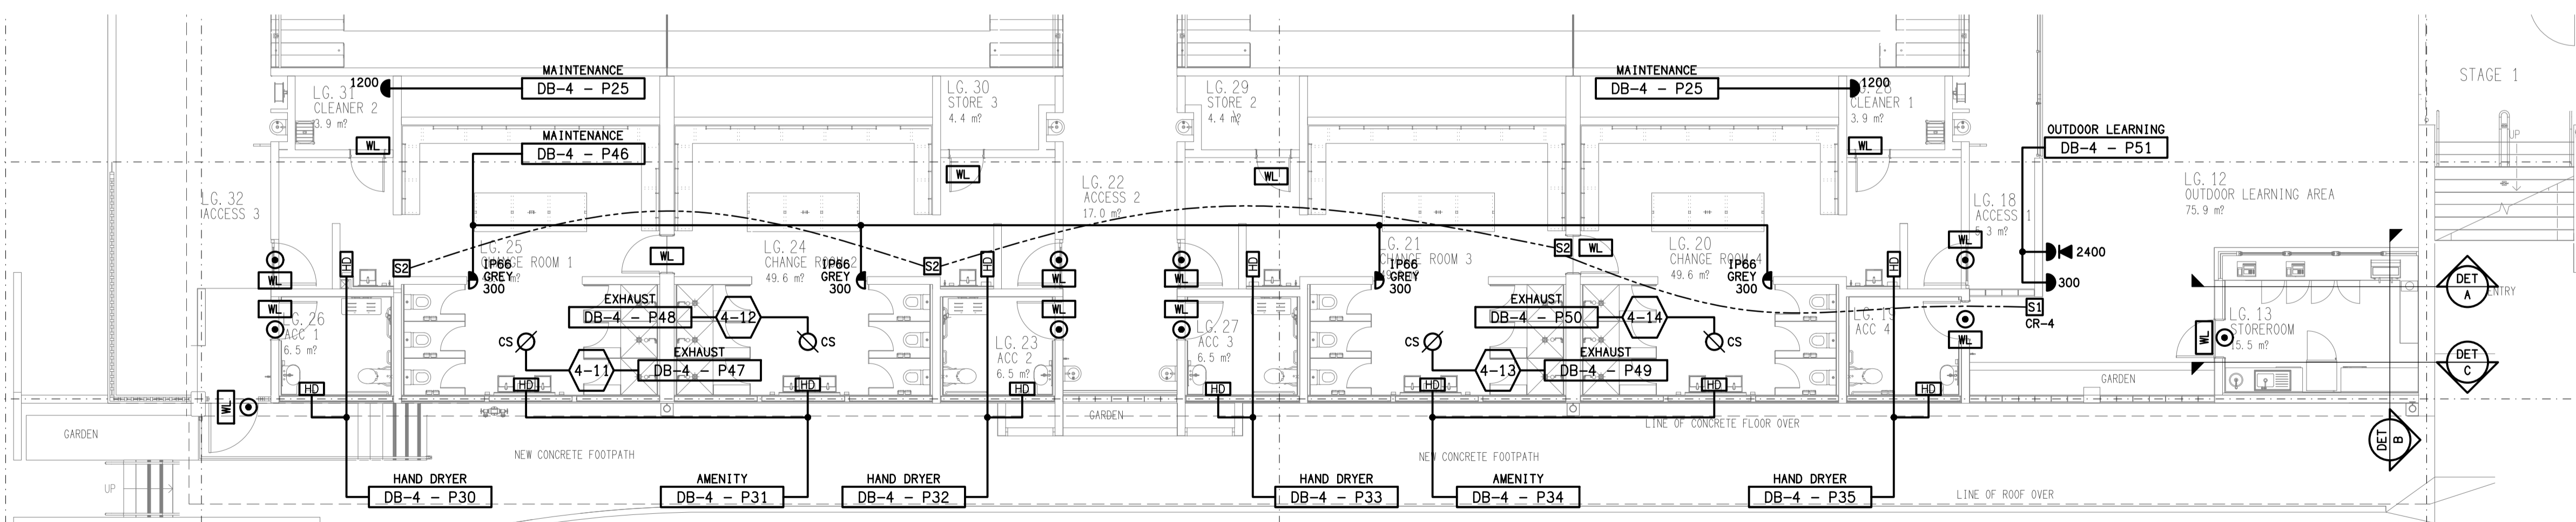


**AMENITIES**  
LOWER GROUND FLOOR PLAN  
SCALE 1:100

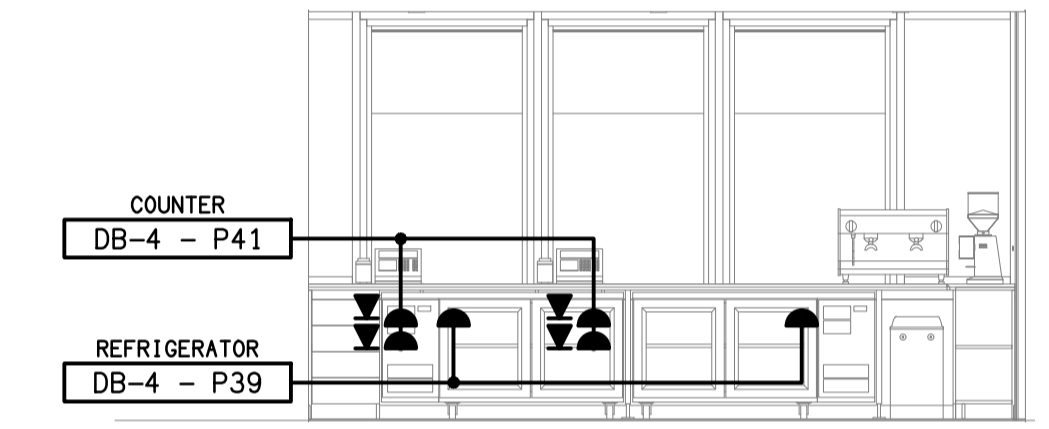

**DETAIL A**  
STORE ROOM BENCH ELEVATION 1  
SCALE 1:50

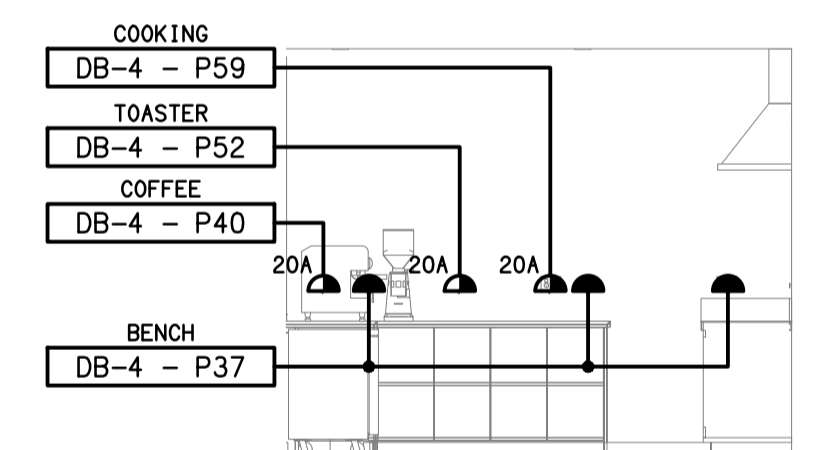

**DETAIL B**  
STORE ROOM BENCH ELEVATION 2  
SCALE 1:50

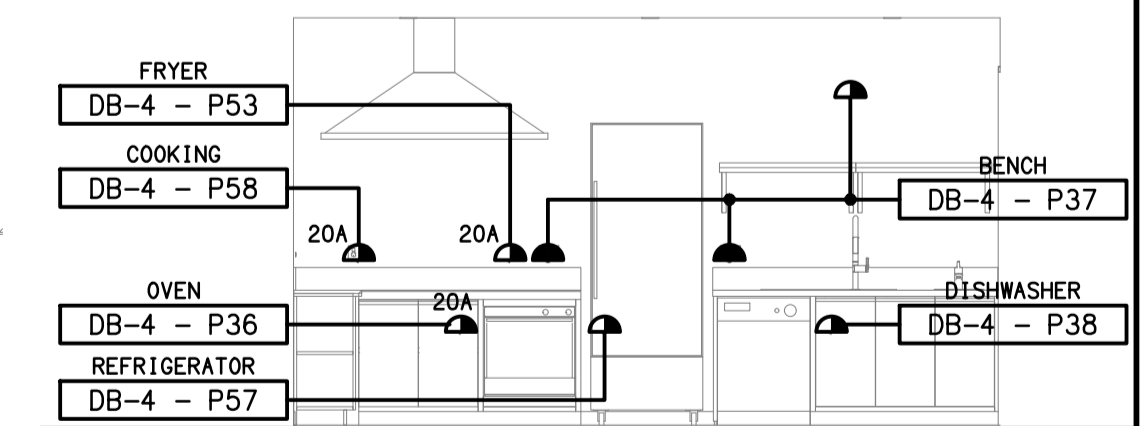

**DETAIL C**  
STORE ROOM BENCH ELEVATION 3  
SCALE 1:50

ELECTRICAL DESIGN GROUP BRISBANE  
PTY LTD  
ACN 092 710 793  
TRADING AS:  
ELECTRICAL DESIGN GROUP

THE COPYRIGHT OF THIS DRAWING  
REMAINS THE PROPERTY OF THE  
ELECTRICAL DESIGN GROUP.  
USE FIGURED DIMENSIONS  
IN PREFERENCE TO SCALE.  
ALL DIMENSIONS TO BE  
VERIFIED ONSITE.

**ELECTRICAL DESIGN GROUP**  
ELECTRICAL BUILDING SERVICES CONSULTANTS  
BRISBANE GOLD COAST  
P.O. Box 15, Sherwood Q. 4075  
Phone: (07) 3278 4375  
Email: brisbane@edg.net.au  
Web: www.edg.net.au

PROJECT:  
**ST JOHN'S ANGLICAN COLLEGE**  
**FOREST LAKE**  
**AQUATIC CENTRE STAGE 2**  
COLLEGE AVENUE, FOREST LAKE

|   |              |                              |
|---|--------------|------------------------------|
| E   | CONSTRUCTION | 30/03/2026                   |
| REV:  | DESCRIPTION: | DATE:                        |
| DRAWING:<br><b>ELECTRICAL SERVICES</b><br><b>LOWER GROUND STORAGE &amp; AMENITIES</b><br><b>PLANS</b> |              |                              |
| SCALE:<br>1:100 UNO   | AT A1        | PROJECT NO:<br><b>C3230a</b> |
|   |              | DRAWING NO:<br><b>E06</b>    |
|   |              | REVISION:<br><b>E</b>        |