


Lot 0
SP124964

2 STOREY
RENDERED
TOWNHOUSES

REFER TO THE LEVEL 1 REFLECTED CEILING
PLAN ABOVE FOR THE ELECTRICAL CEILING
SERVICES WITHIN THIS AREA.

NOTE:
CEILING FITTINGS IN AREAS SHOWN
SHADED ARE TO BE BLACK IN COLOUR.

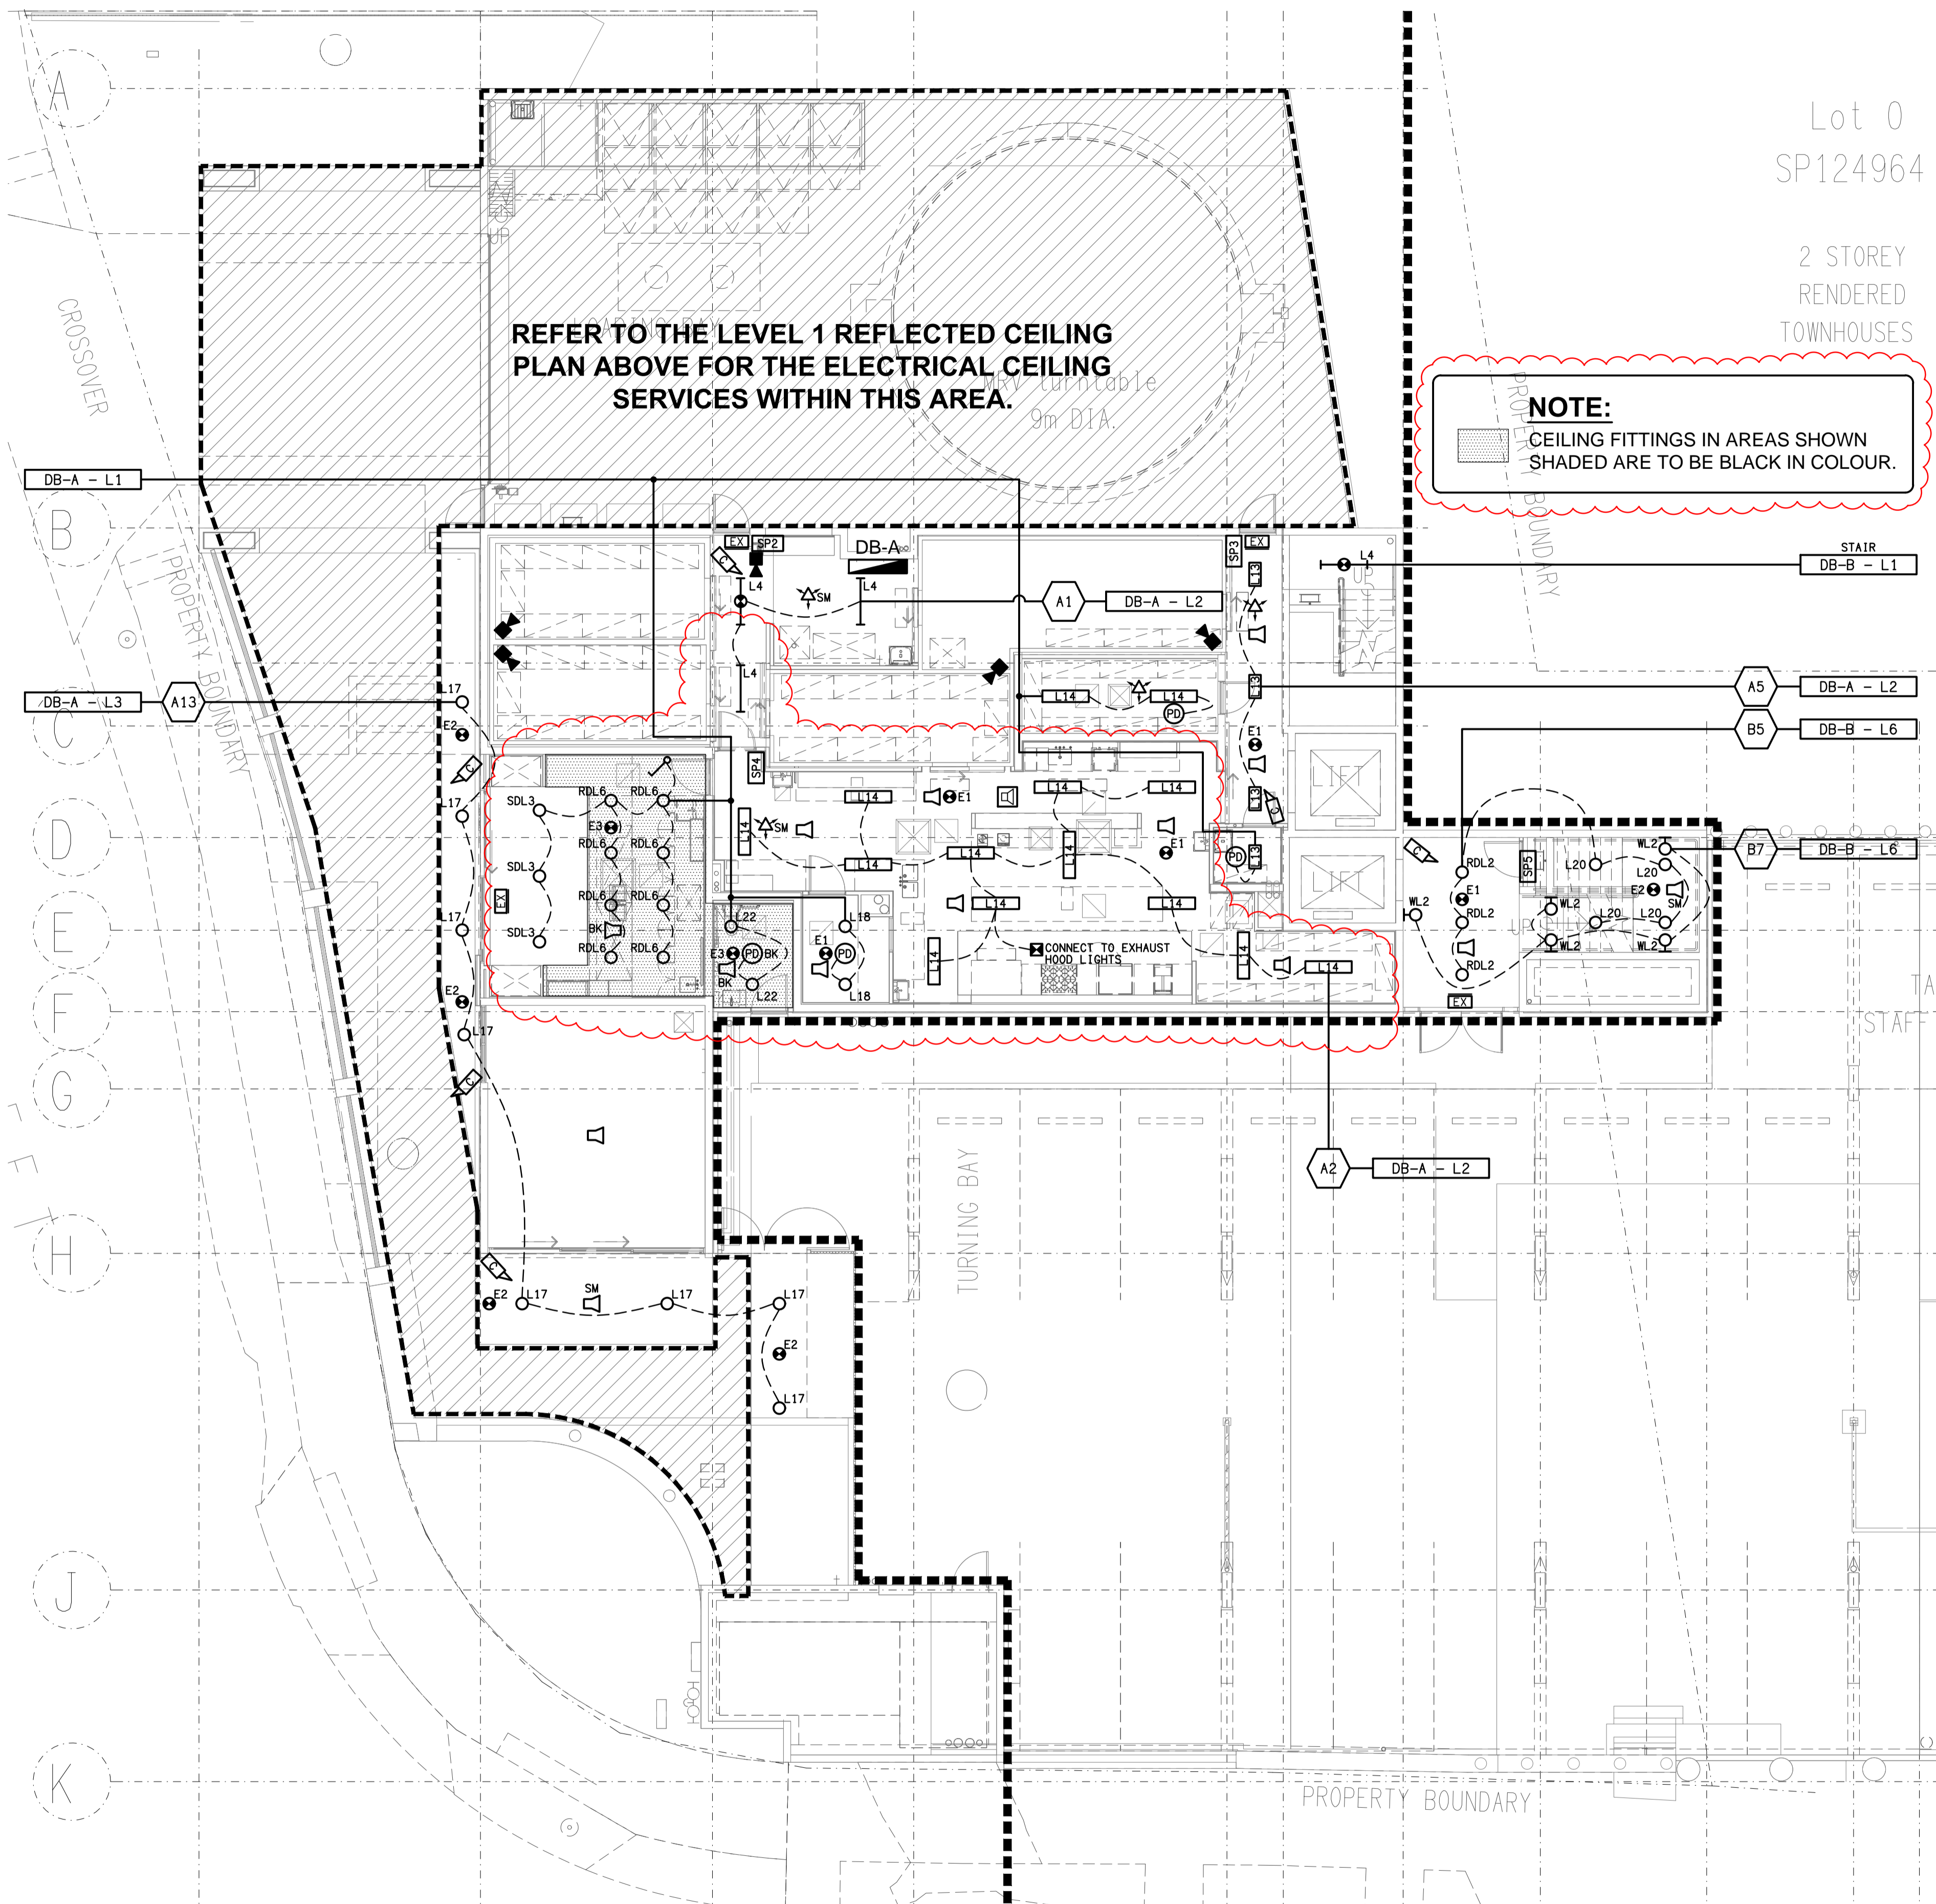

ELECTRICAL DESIGN GROUP BRISBANE
PTY LTD
ACN 092 710 793
TRADING AS:
ELECTRICAL DESIGN GROUP

THE COPYRIGHT OF THIS DRAWING
REMAINS THE PROPERTY OF THE
ELECTRICAL DESIGN GROUP.
USE FIGURED DIMENSIONS
IN PREFERENCE TO SCALE.
ALL DIMENSIONS TO BE
VERIFIED ONSITE.

ELECTRICAL DESIGN GROUP
ELECTRICAL BUILDING SERVICES CONSULTANTS
BRISBANE GOLD COAST

P.O. Box 15, Sherwood Q.4075
Phone: (07) 3278 4375
Email: brisbane@edg.net.au
Web: www.edg.net.au

PROJECT:
185 SAMFORD ROAD, ENOGGERA

2	CONSTRUCTION	01/06/2026
REV:	DESCRIPTION:	DATE:

DRAWING: ELECTRICAL SERVICES LEVEL 0 REFLECTED CEILING PLAN			
SCALE: 1:100	AT A1	PROJECT NO: C3234a	DRAWING NO: E10
			REVISION: 2