


NOTE: SP124964
 CEILING FITTINGS IN AREAS SHOWN SHADED ARE TO BE BLACK IN COLOUR.

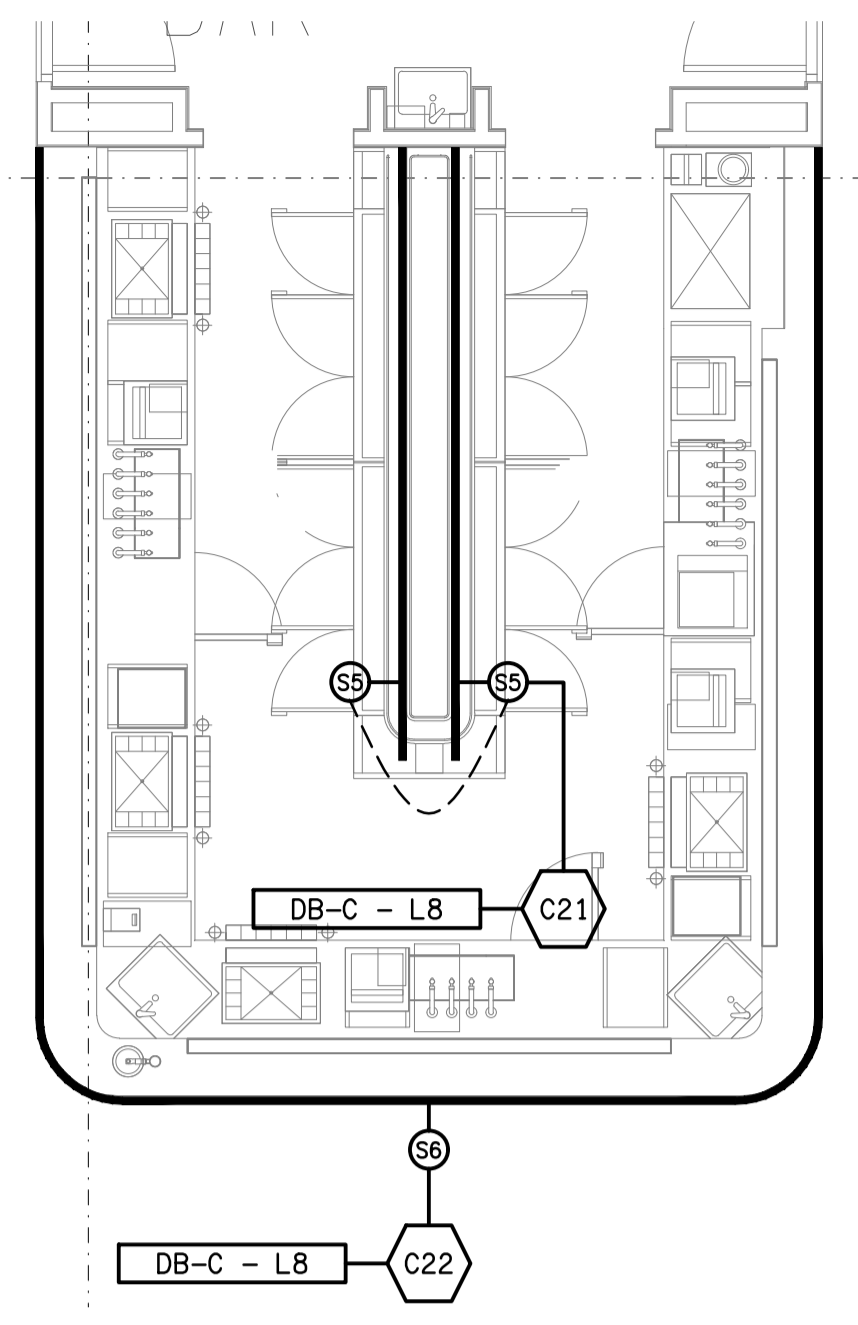

DETAIL A
 BAR COUNTER & SHELVING STRIP LIGHTING
 SCALE 1:50

ELECTRICAL DESIGN GROUP BRISBANE
 PTY LTD
 ACN 092 710 793
 TRADING AS:
 ELECTRICAL DESIGN GROUP

THE COPYRIGHT OF THIS DRAWING
 REMAINS THE PROPERTY OF THE
 ELECTRICAL DESIGN GROUP.
 USE FIGURED DIMENSIONS
 IN PREFERENCE TO SCALE.
 ALL DIMENSIONS TO BE
 VERIFIED ONSITE.

ELECTRICAL DESIGN GROUP
 ELECTRICAL BUILDING SERVICES CONSULTANTS
 BRISBANE GOLD COAST
 P.O. Box 15, Sherwood Q.4075
 Phone: (07) 3278 4375
 Email: brisbane@edg.net.au
 Web: www.edg.net.au

PROJECT:
185 SAMFORD ROAD, ENOGGERA

3	CONSTRUCTION	01/06/2026
REV:	DESCRIPTION:	DATE:
DRAWING: ELECTRICAL SERVICES		
LEVEL 2		
REFLECTED CEILING PLAN - LIGHTING		
SCALE: 1:100 UNO	PROJECT NO: C3234a	DRAWING NO: E12
AT A1	REVISION: 3	