




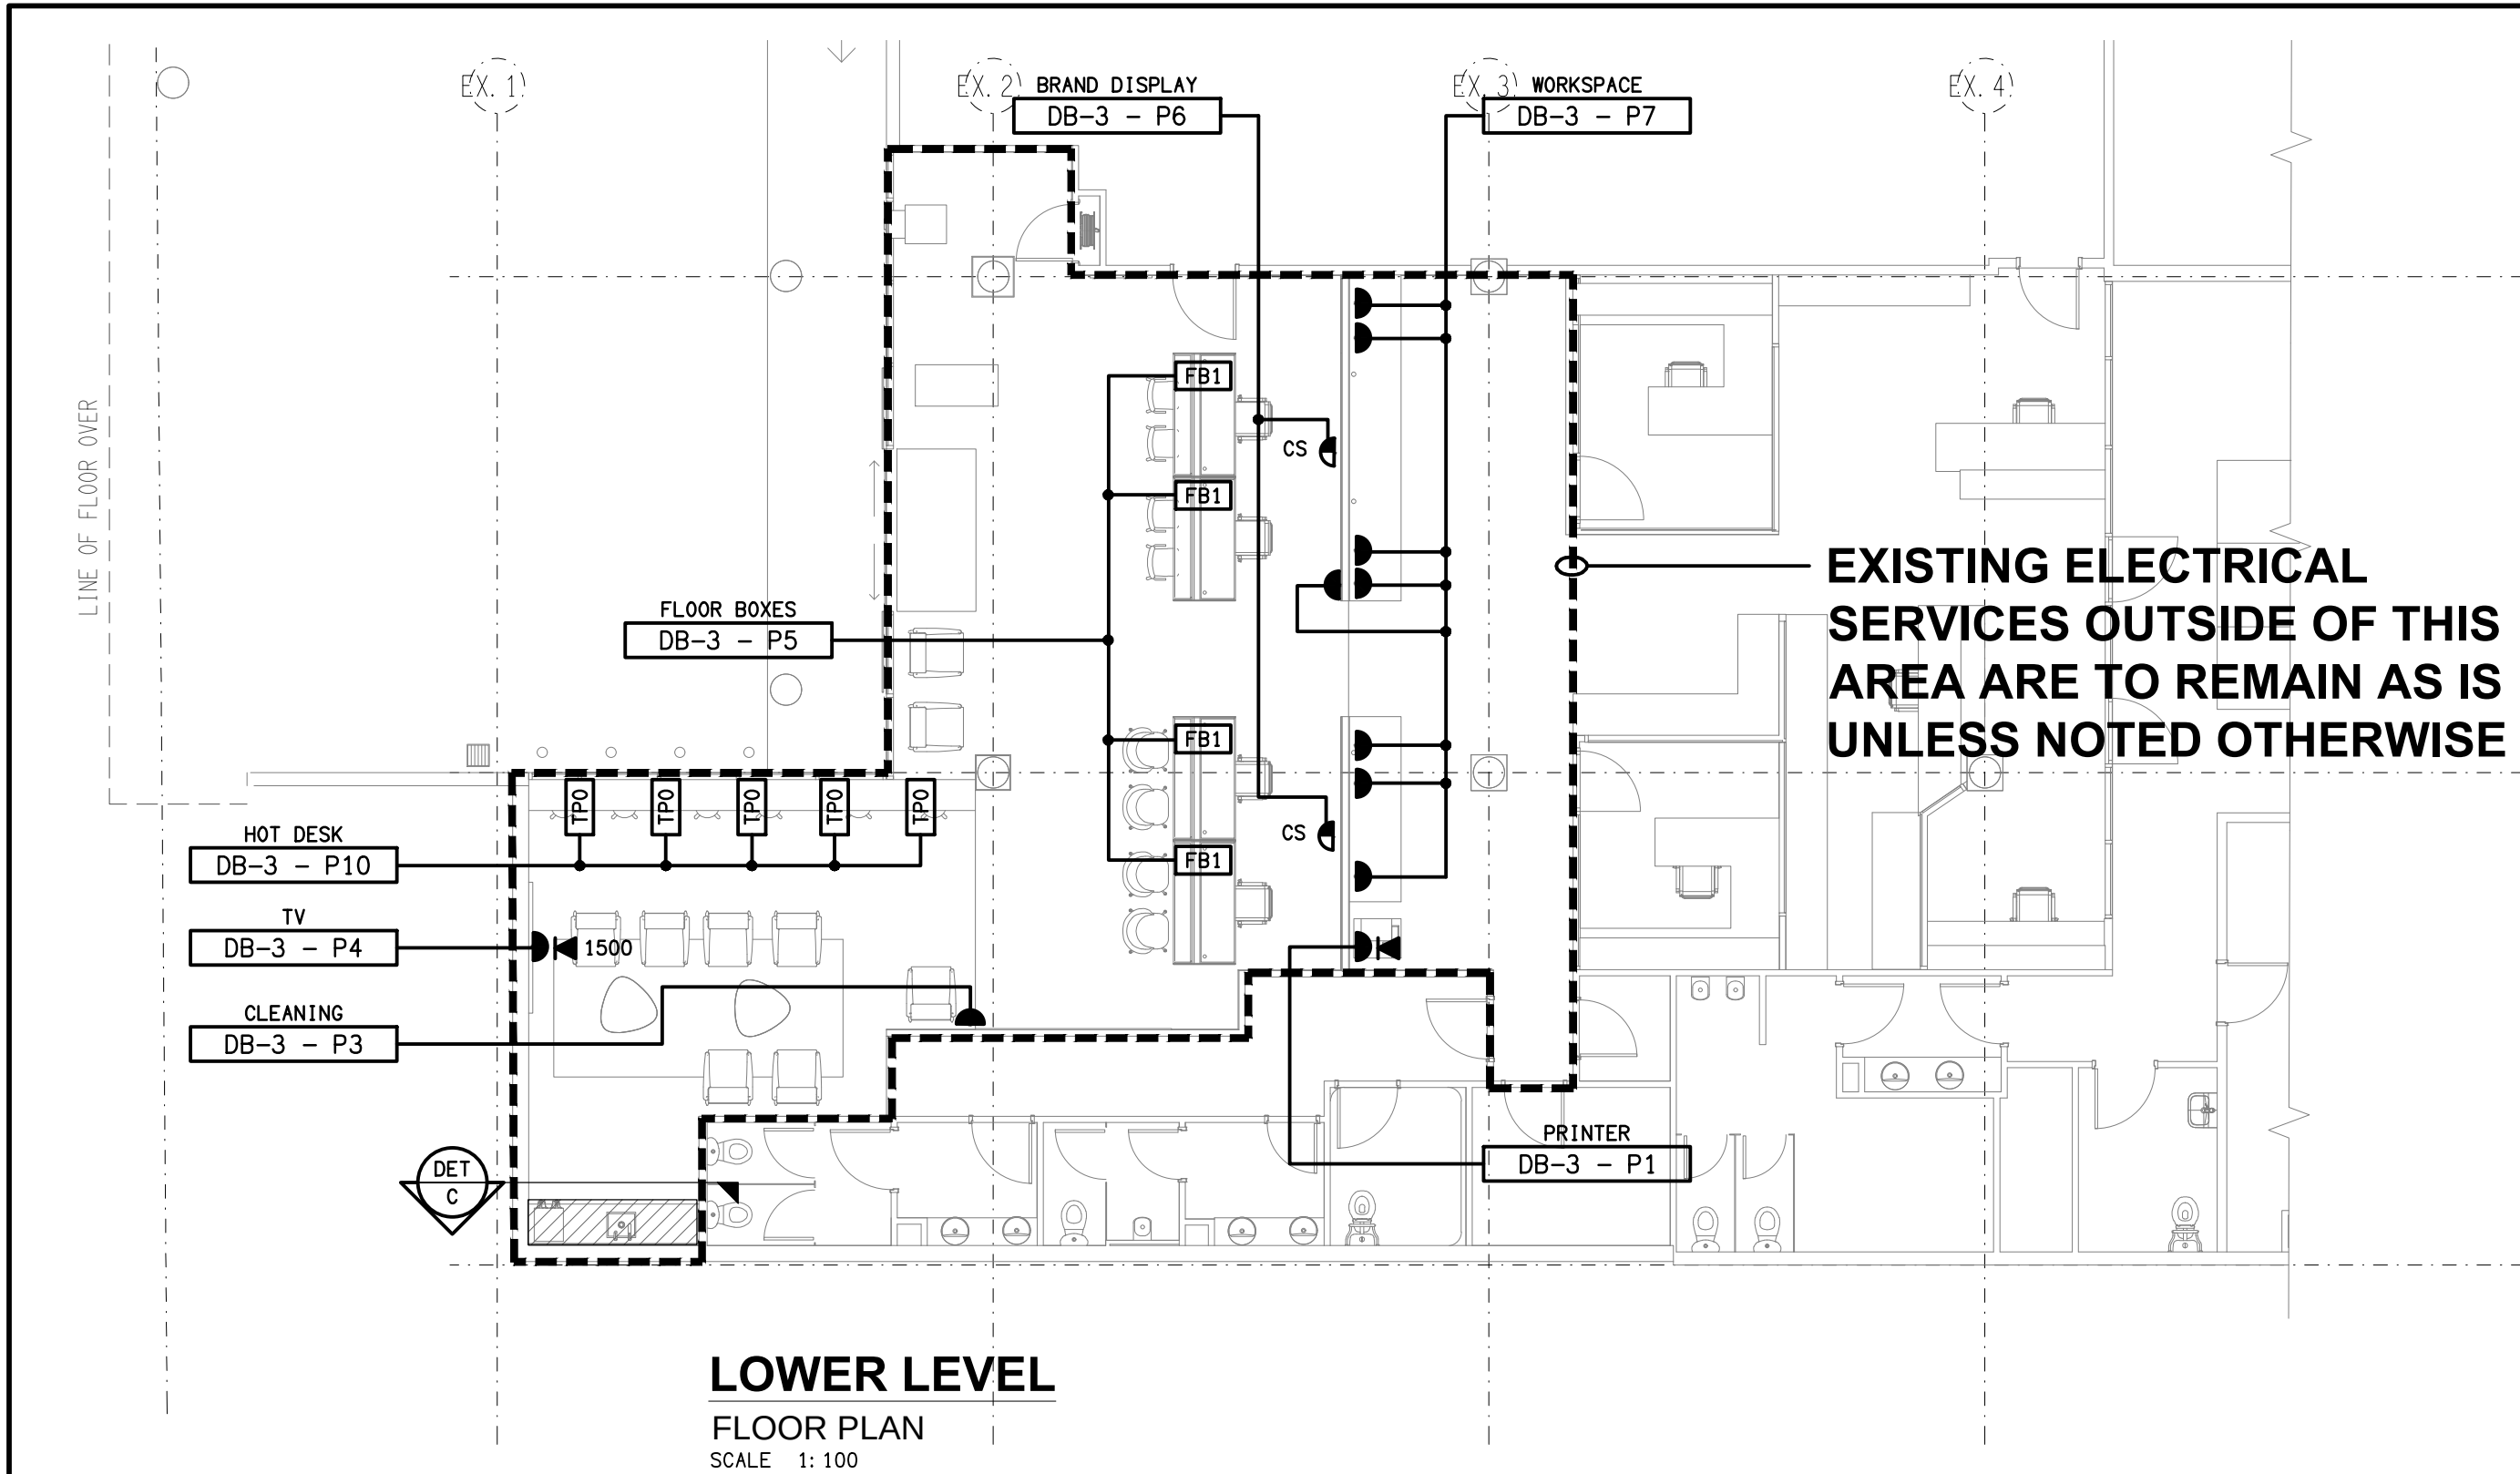

LOWER LEVEL
FLOOR PLAN
SCALE 1: 100

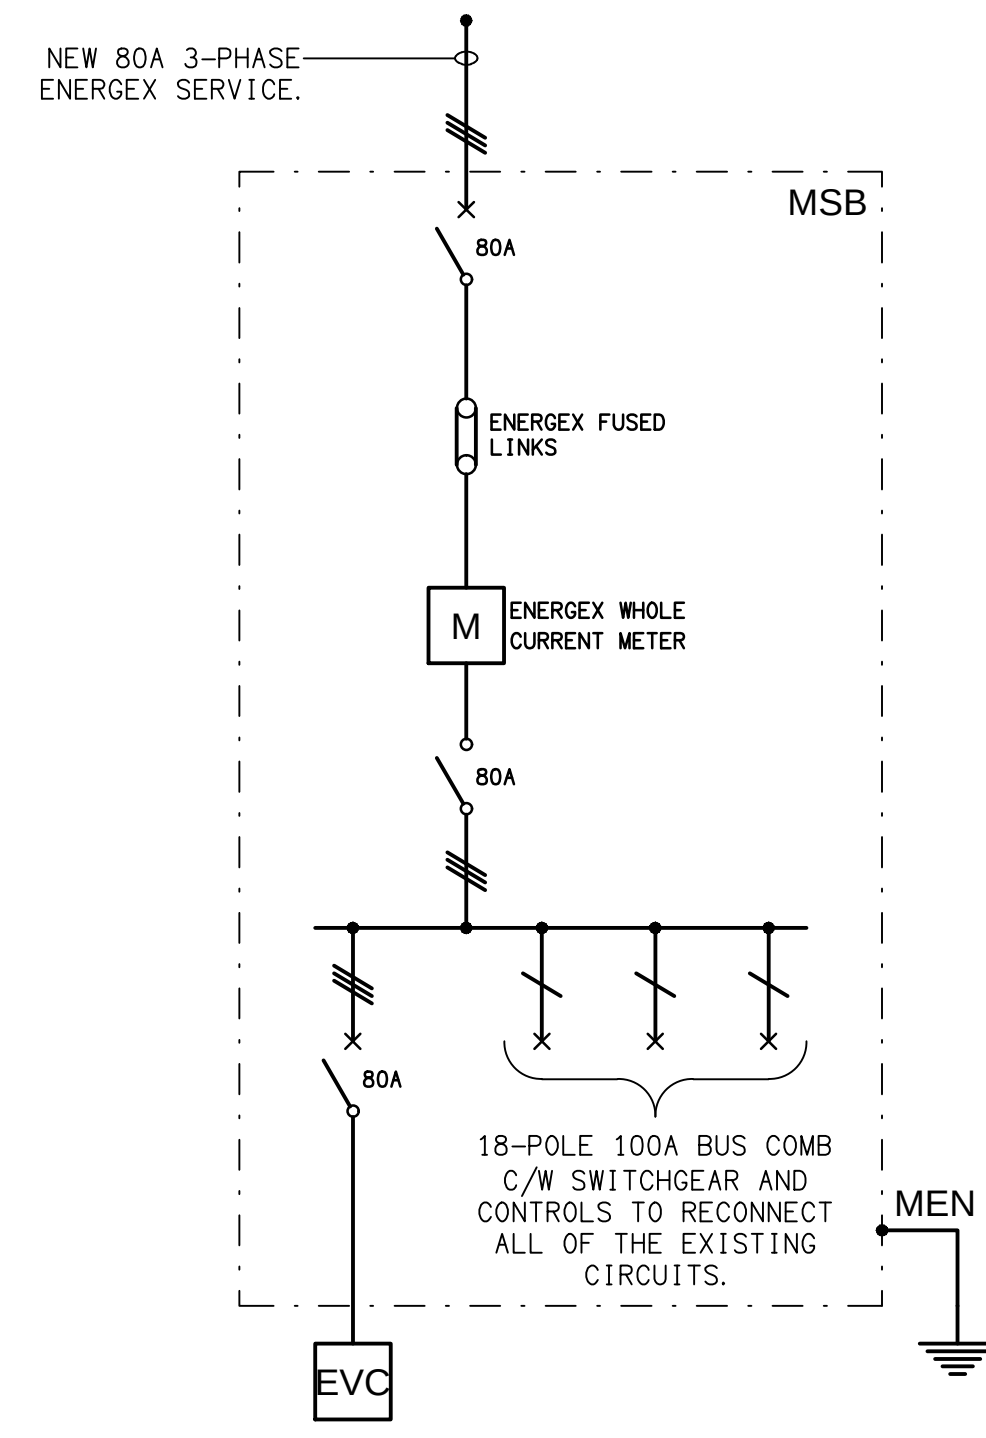


SCHEMATIC
MSB POWER ARRANGEMENTS
NOT TO SCALE

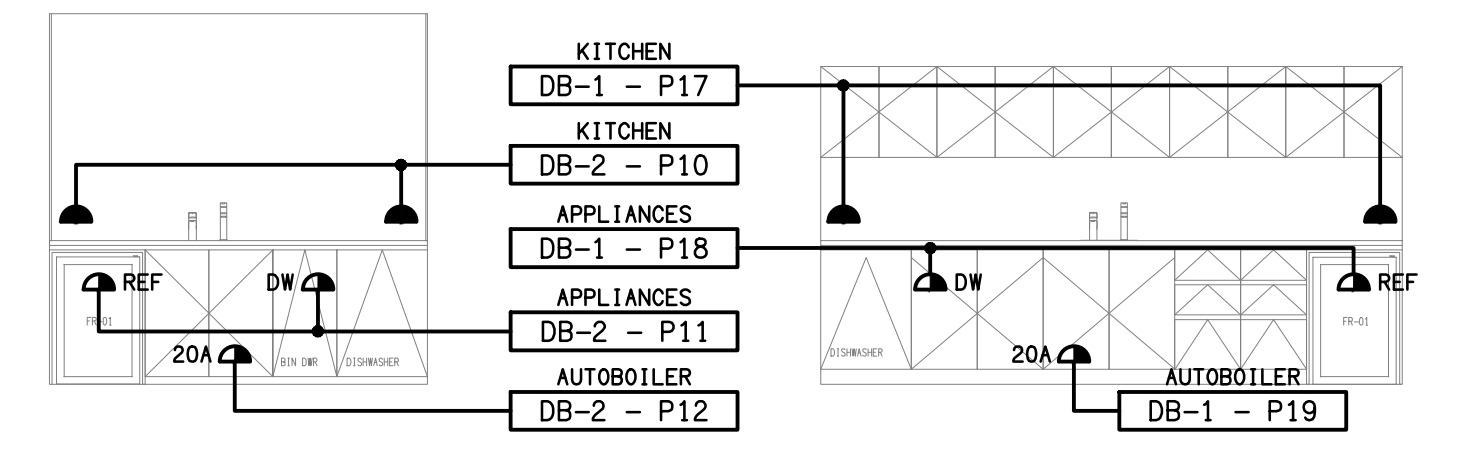


DETAIL A
KIA KITCHENETTE
SCALE 1: 50

DETAIL B
MITSUBISHI KITCHENETTE
SCALE 1: 50

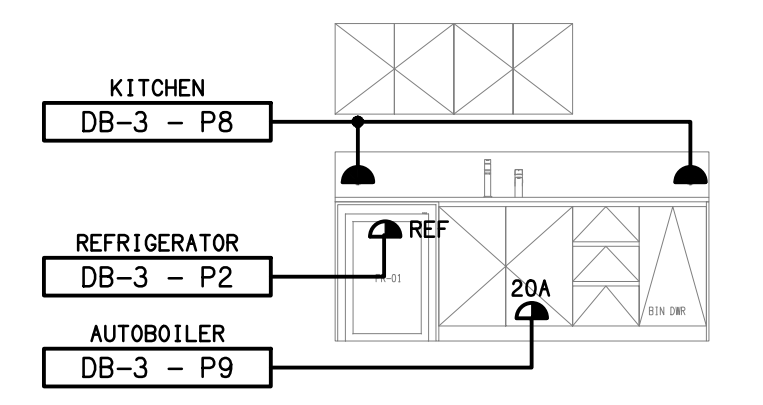

DETAIL C
SERVICE KITCHENETTE
SCALE 1: 50

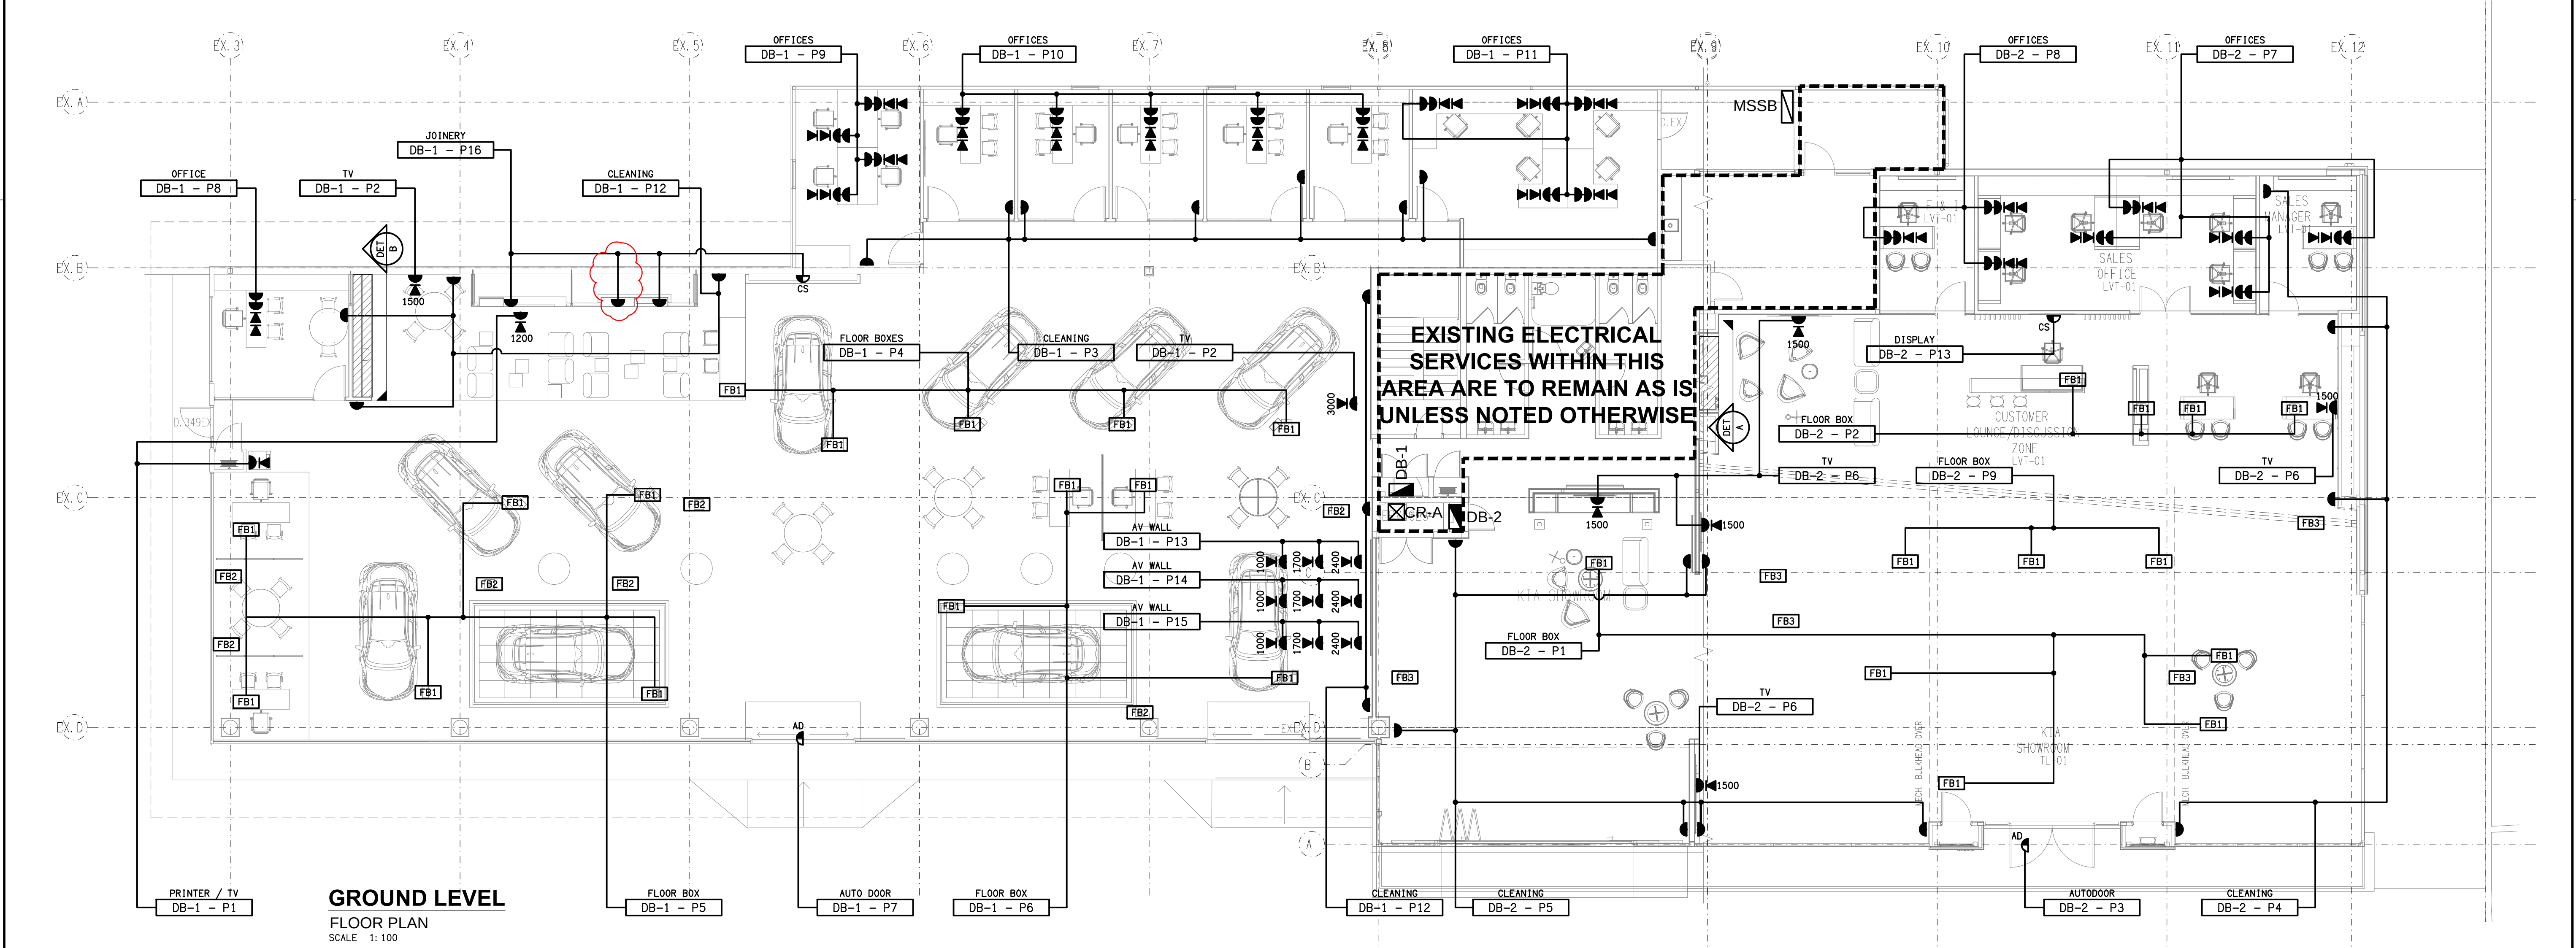

GROUND LEVEL
FLOOR PLAN
SCALE 1: 100