


**ROOF LEVEL**  
**PLANT DECK PLAN**  
 SCALE 1:200

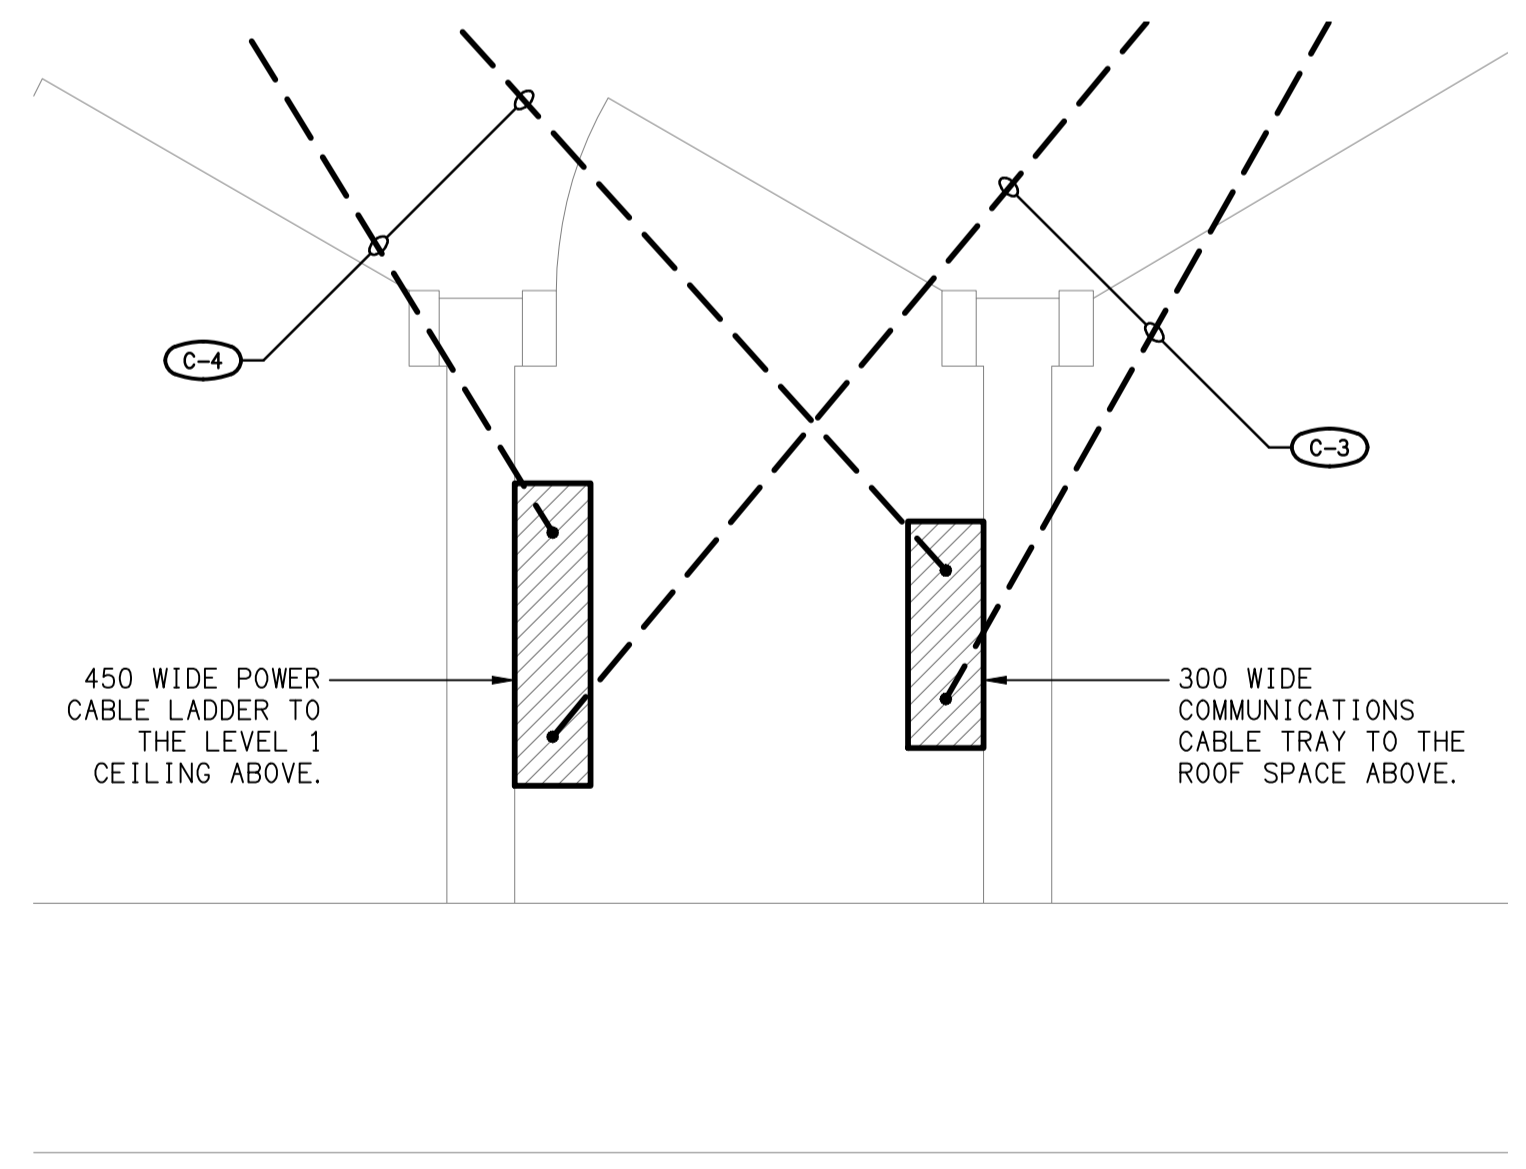

**DETAIL A**  
**ELECTRICAL RISER PLAN**  
 SCALE 1:10

ELECTRICAL DESIGN GROUP BRISBANE  
 PTY LTD  
 ACN 092 710 793  
 TRADING AS:  
 ELECTRICAL DESIGN GROUP

THE COPYRIGHT OF THIS DRAWING  
 REMAINS THE PROPERTY OF THE  
 ELECTRICAL DESIGN GROUP.  
 USE FIGURED DIMENSIONS  
 IN PREFERENCE TO SCALE.  
 ALL DIMENSIONS TO BE  
 VERIFIED ONSITE.

**ELECTRICAL DESIGN GROUP**  
 ELECTRICAL BUILDING SERVICES CONSULTANTS  
 BRISBANE GOLD COAST

P.O. Box 15, Sherwood Q.4075  
 Phone: (07) 3278 4375  
 Email: brisbane@edg.net.au  
 Web: www.edg.net.au

PROJECT:  
**KINGS CHRISTIAN COLLEGE**  
**CHAMBERS FLAT, SENIOR SCHOOL CHA12**  
 38-112 ANZAC AVENUE, CHAMBERS FLAT

|      |              |            |
|------|--------------|------------|
| F    | CONSTRUCTION | 08/05/2026 |
| REV: | DESCRIPTION: | DATE:      |

DRAWING:  
**ELECTRICAL SERVICES**  
**GROUND LEVEL FLOOR PLAN**

|                     |       |                              |                           |                       |
|---------------------|-------|------------------------------|---------------------------|-----------------------|
| SCALE:<br>1:100 UNO | AT A1 | PROJECT NO:<br><b>C3474a</b> | DRAWING NO:<br><b>E05</b> | REVISION:<br><b>F</b> |
|---------------------|-------|------------------------------|---------------------------|-----------------------|