



CONDUIT:
 - - - - - EXISTING CONDUITS.
 - - - - - NEW CONDUITS.

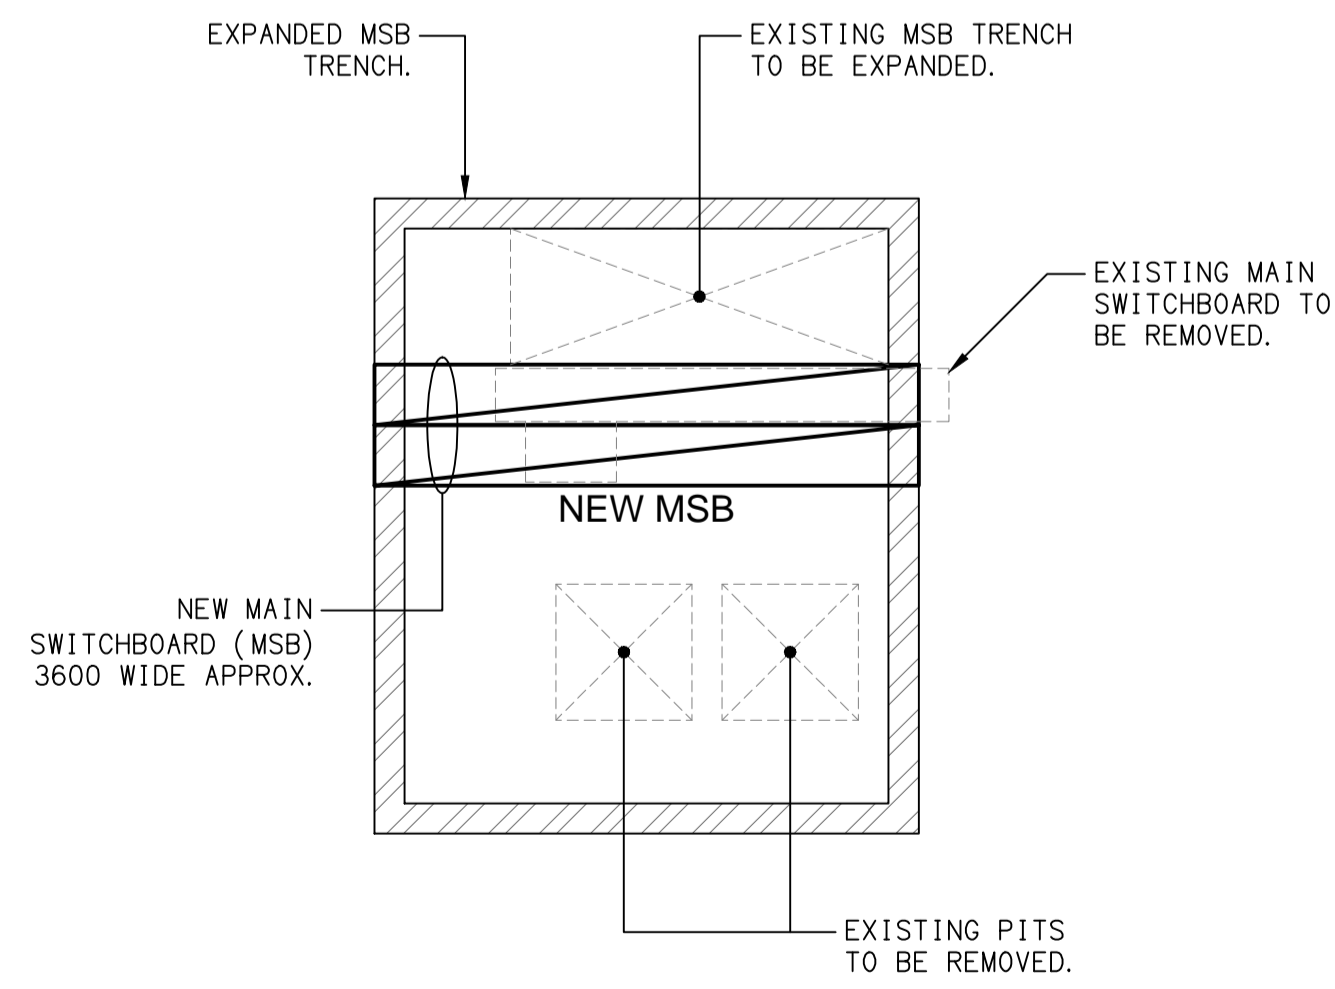

DETAIL A
 EXPANDED MSB TRENCH PLAN
 SCALE 1:50

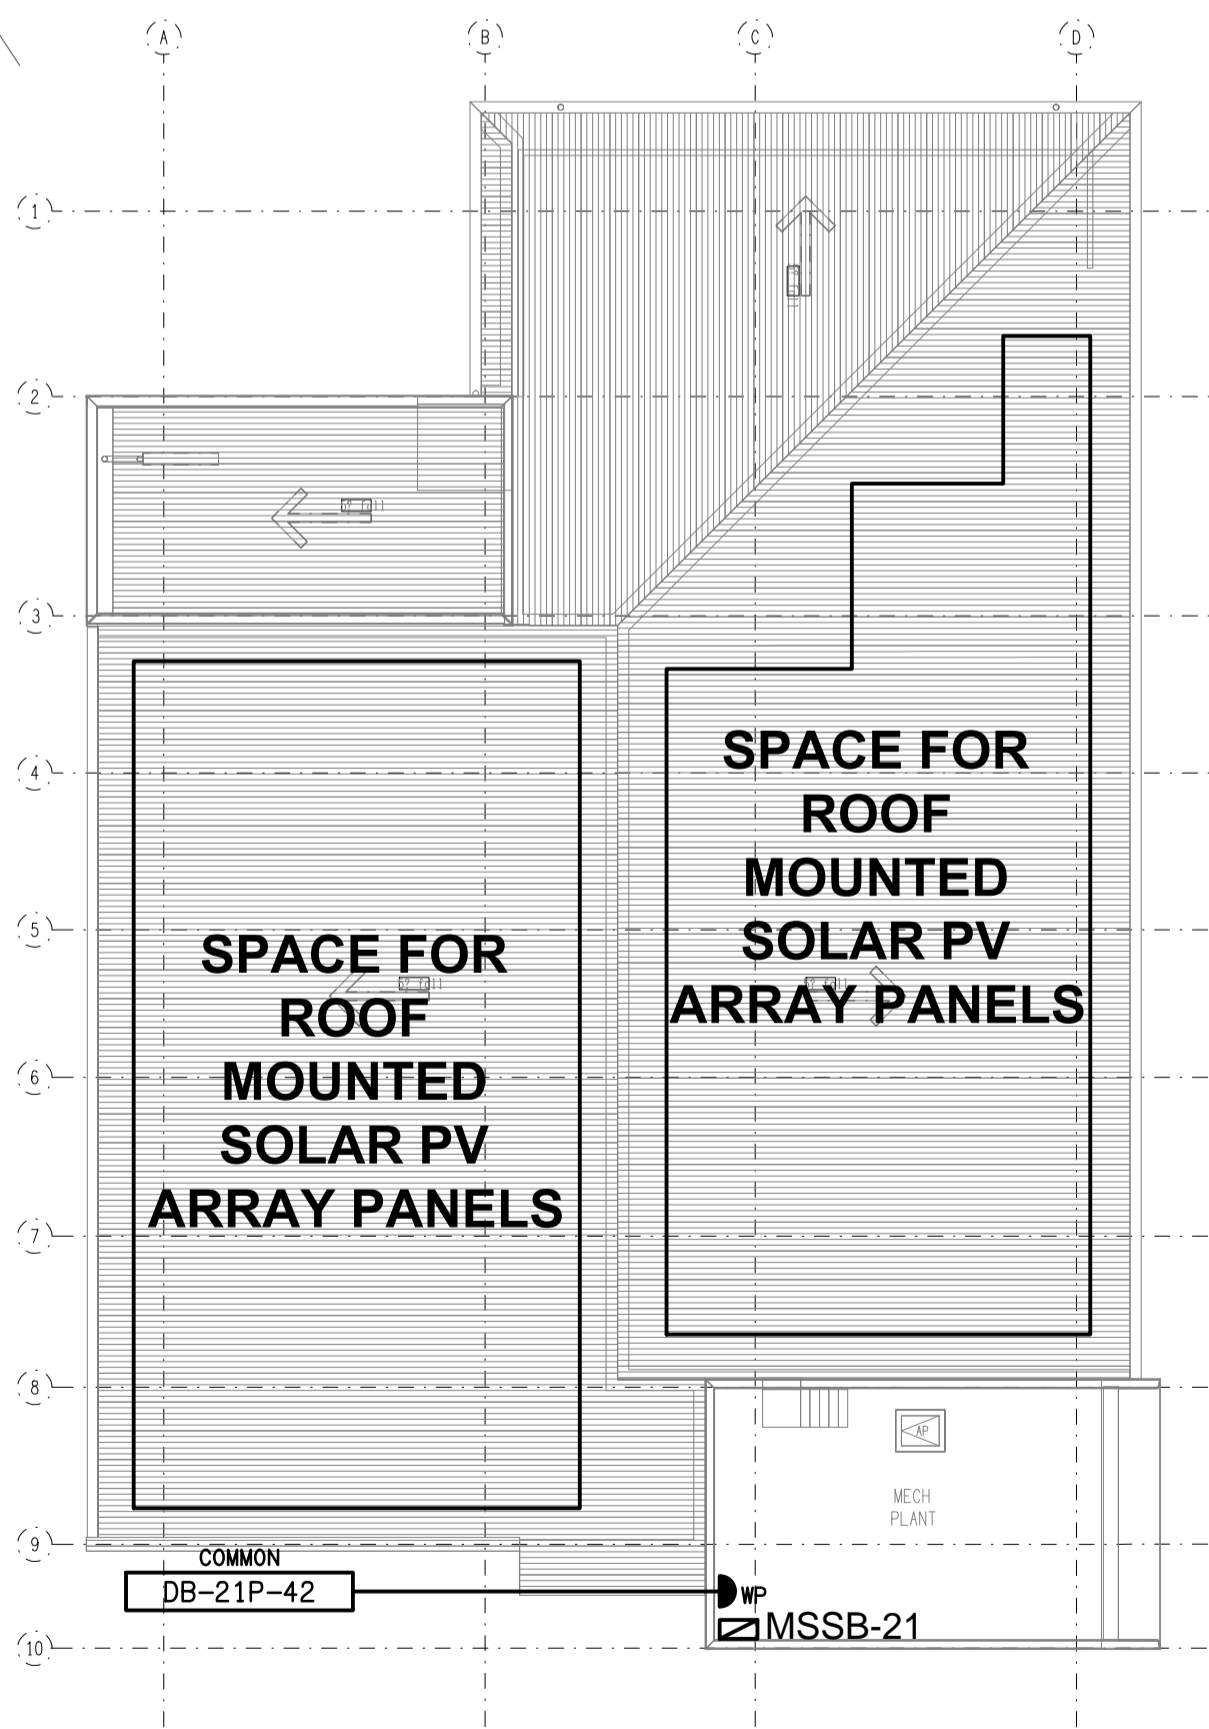

ELECTRICAL DESIGN GROUP BRISBANE
 PTY LTD
 ACN 092 710 793
 TRADING AS:
 ELECTRICAL DESIGN GROUP

THE COPYRIGHT OF THIS DRAWING
 REMAINS THE PROPERTY OF THE
 ELECTRICAL DESIGN GROUP.
 USE FIGURED DIMENSIONS
 IN PREFERENCE TO SCALE.
 ALL DIMENSIONS TO BE
 VERIFIED ONSITE.

ELECTRICAL DESIGN GROUP
 ELECTRICAL BUILDING SERVICES CONSULTANTS
 BRISBANE GOLD COAST
 P.O. Box 15, Sherwood Q.4075
 Phone: (07) 3278 4375
 Email: brisbane@edg.net.au
 Web: www.edg.net.au

PROJECT:
**KINGS CHRISTIAN COLLEGE PIMPAMA
 SENIOR SCHOOL ADMINISTRATION - PIM21**
 198 PIMPAMA JACOBS WELL ROAD, PIMPAMA, QUEENSLAND

C	CONSTRUCTION	23/03/2026
REV:	DESCRIPTION:	DATE:
DRAWING: ELECTRICAL SERVICES SITE PLAN		
SCALE: 1:500 UNO	AT A1	PROJECT NO: C3475a
		DRAWING NO: E04
		REVISION: C