


FLOOR PLAN
UNDERCROFT REFURBISHMENT
 SCALE 1:100

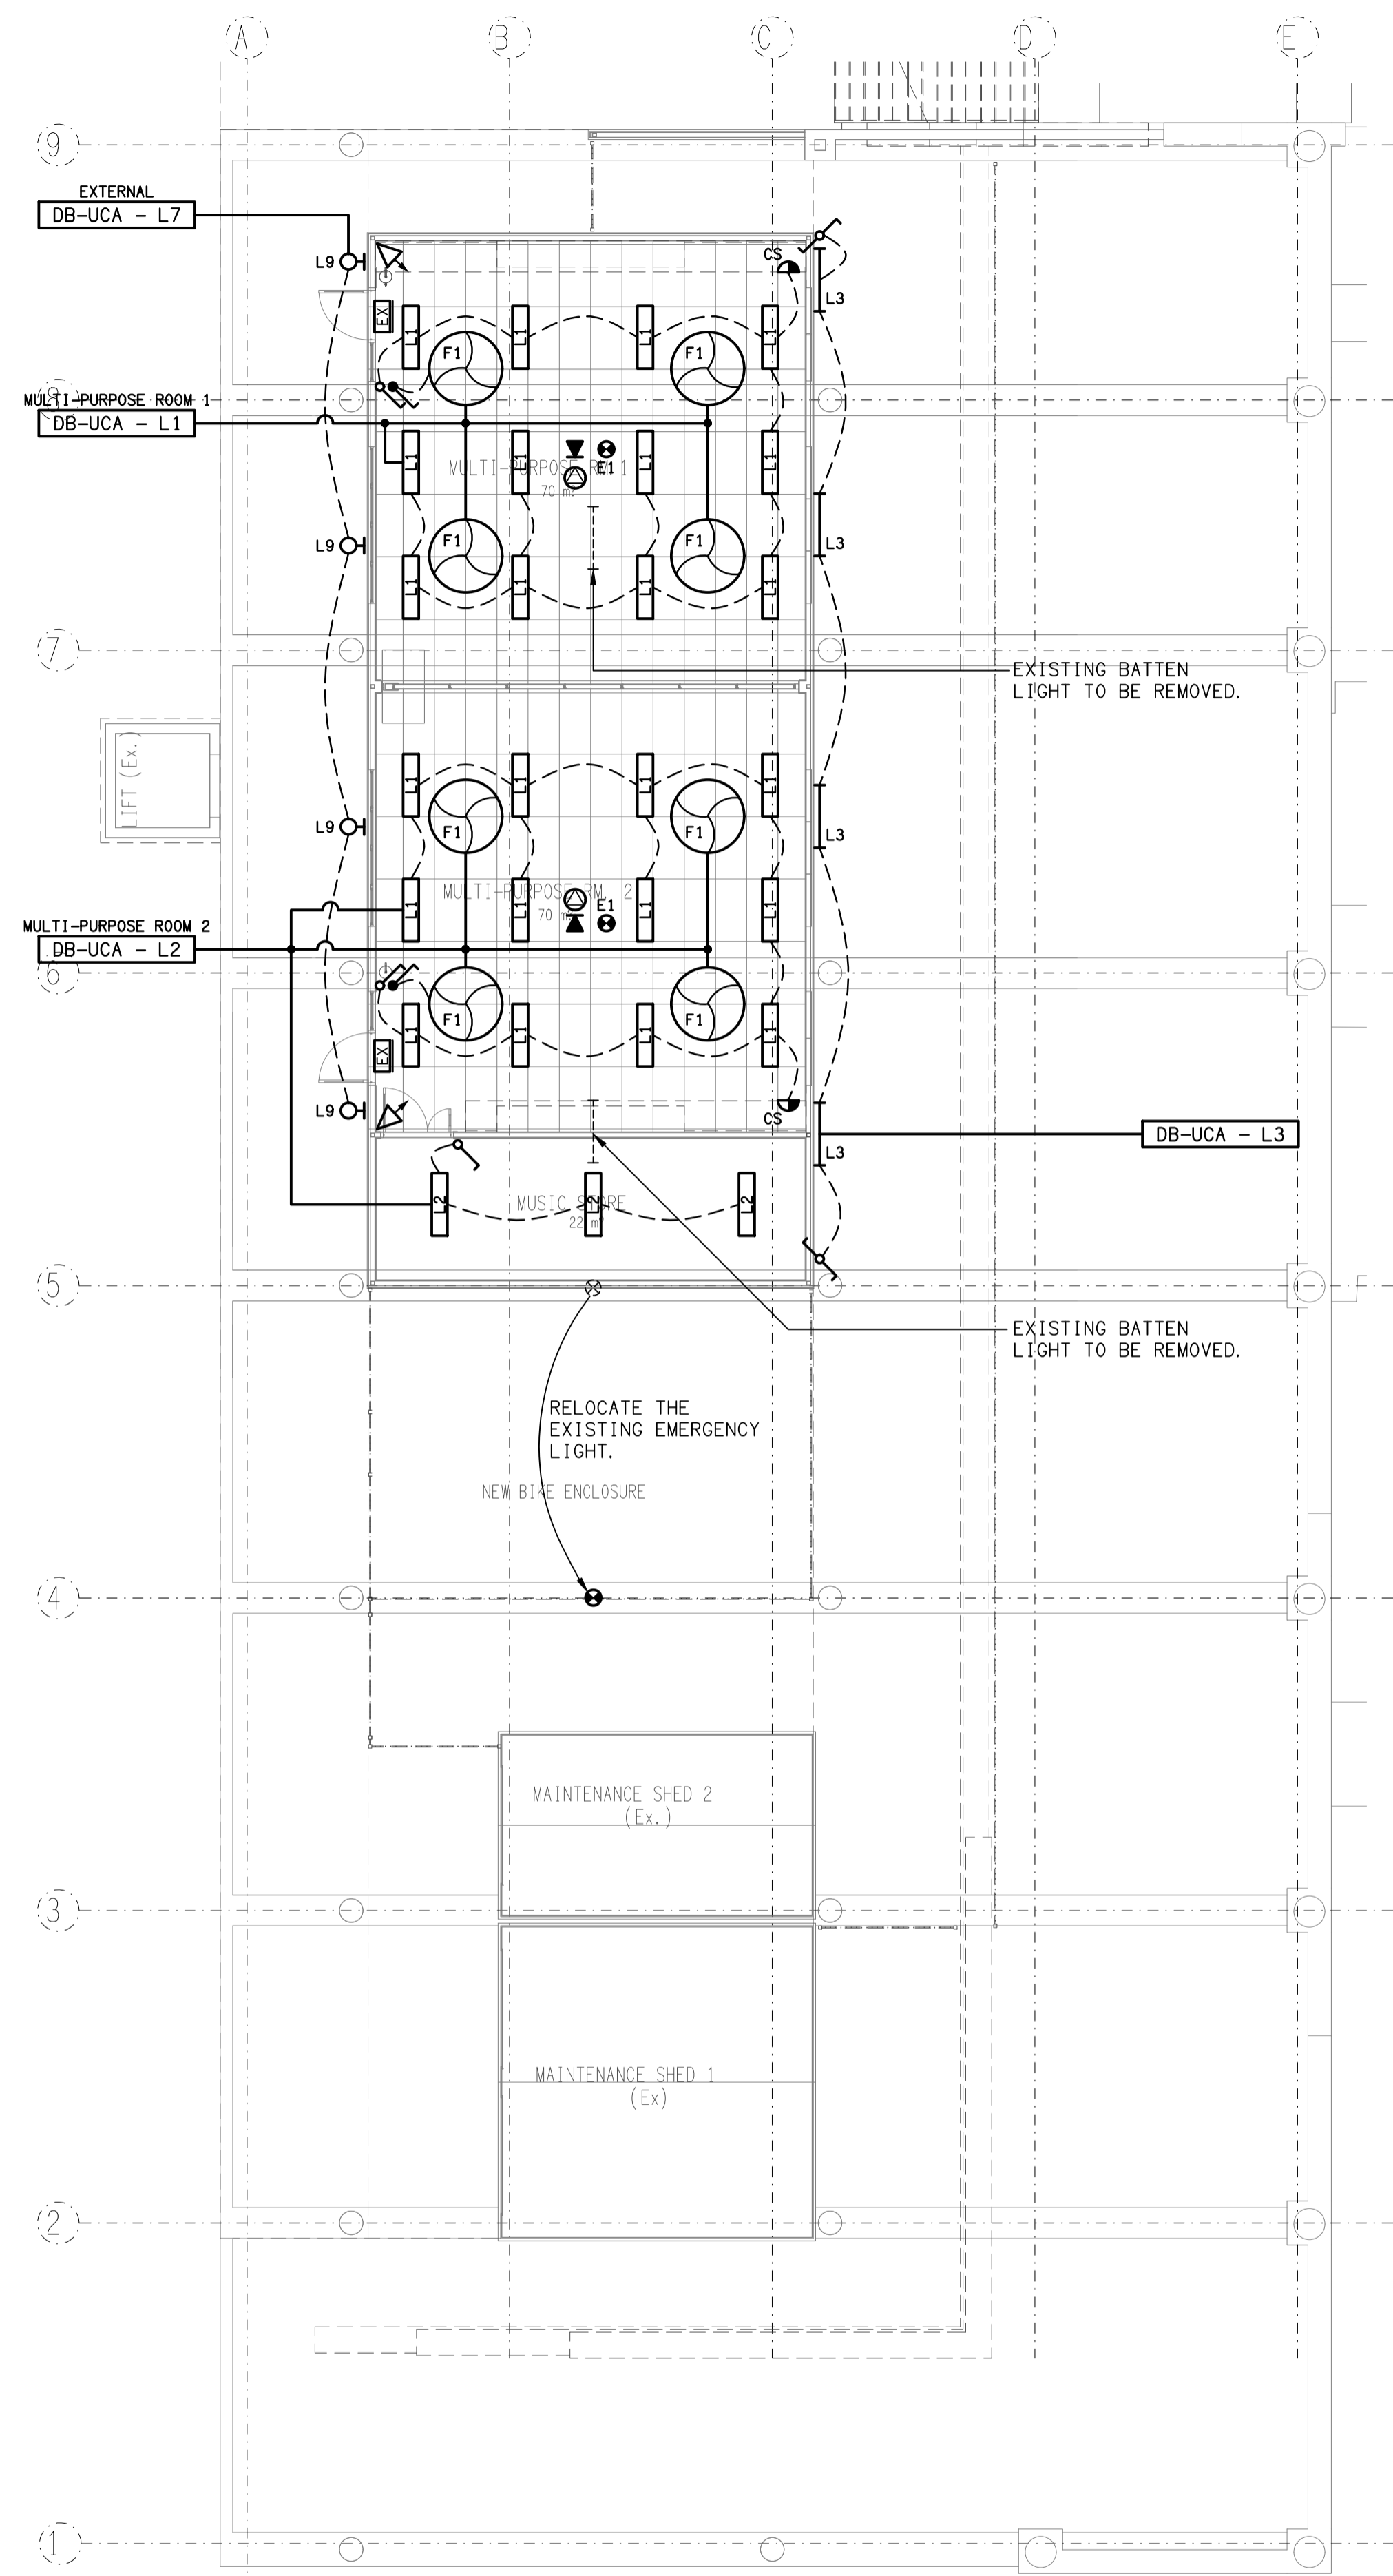

REFLECTED CEILING PLAN
UNDERCROFT REFURBISHMENT
 SCALE 1:100

ELECTRICAL DESIGN GROUP BRISBANE
 PTY LTD
 ACN 092 710 793
 TRADING AS:
 ELECTRICAL DESIGN GROUP

THE COPYRIGHT OF THIS DRAWING
 REMAINS THE PROPERTY OF THE
 ELECTRICAL DESIGN GROUP.
 USE FIGURED DIMENSIONS
 IN PREFERENCE TO SCALE.
 ALL DIMENSIONS TO BE
 VERIFIED ONSITE.

ELECTRICAL DESIGN GROUP
 ELECTRICAL BUILDING SERVICES CONSULTANTS
 BRISBANE GOLD COAST

P.O. Box 15, Sherwood Q.4075
 Phone: (07) 3278 4375
 Email: brisbane@edg.net.au
 Web: www.edg.net.au

PROJECT:
**ST PIUS PRIMARY SCHOOL, BANYO
 HALL & GLA REFURBISHMENT**

APPERLEY STREET, BANYO, QUEENSLAND

D	CONSTRUCTION	20/03/2026
REV.	DESCRIPTION:	DATE:

DRAWING:
**ELECTRICAL SERVICES
 UNDERCROFT GLA PLANS**

SCALE:
 1:100

AT A1

PROJECT NO:
C3491a

DRAWING NO:
E02

REVISION:
D