



FLOOR PLAN
HALL REFURBISHMENT
SCALE 1:100

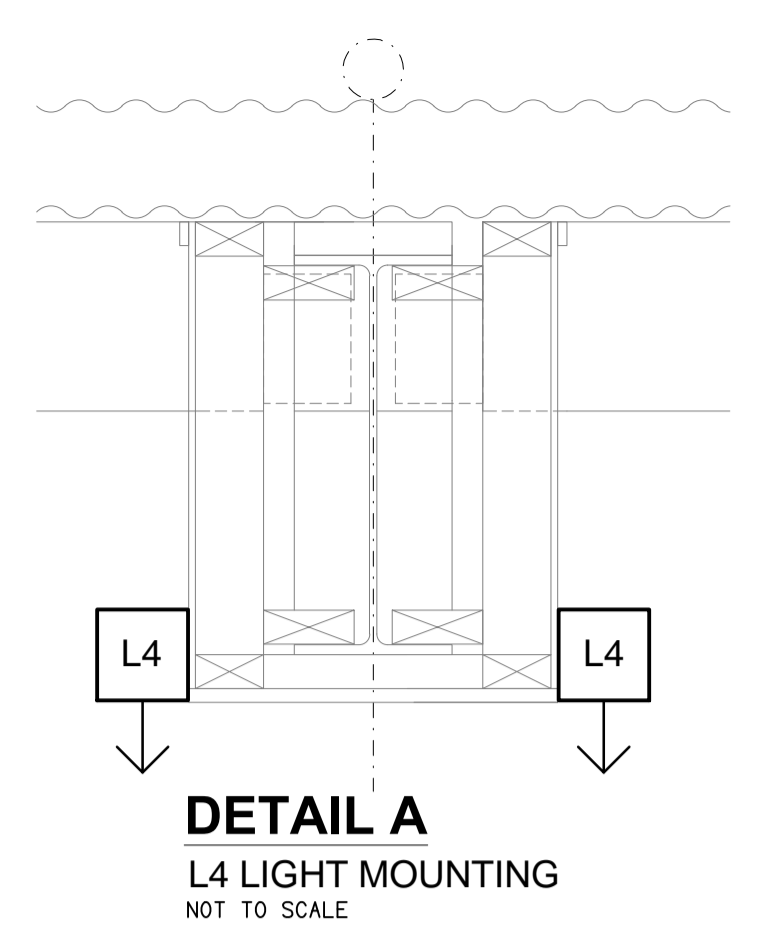

DETAIL A
L4 LIGHT MOUNTING
NOT TO SCALE

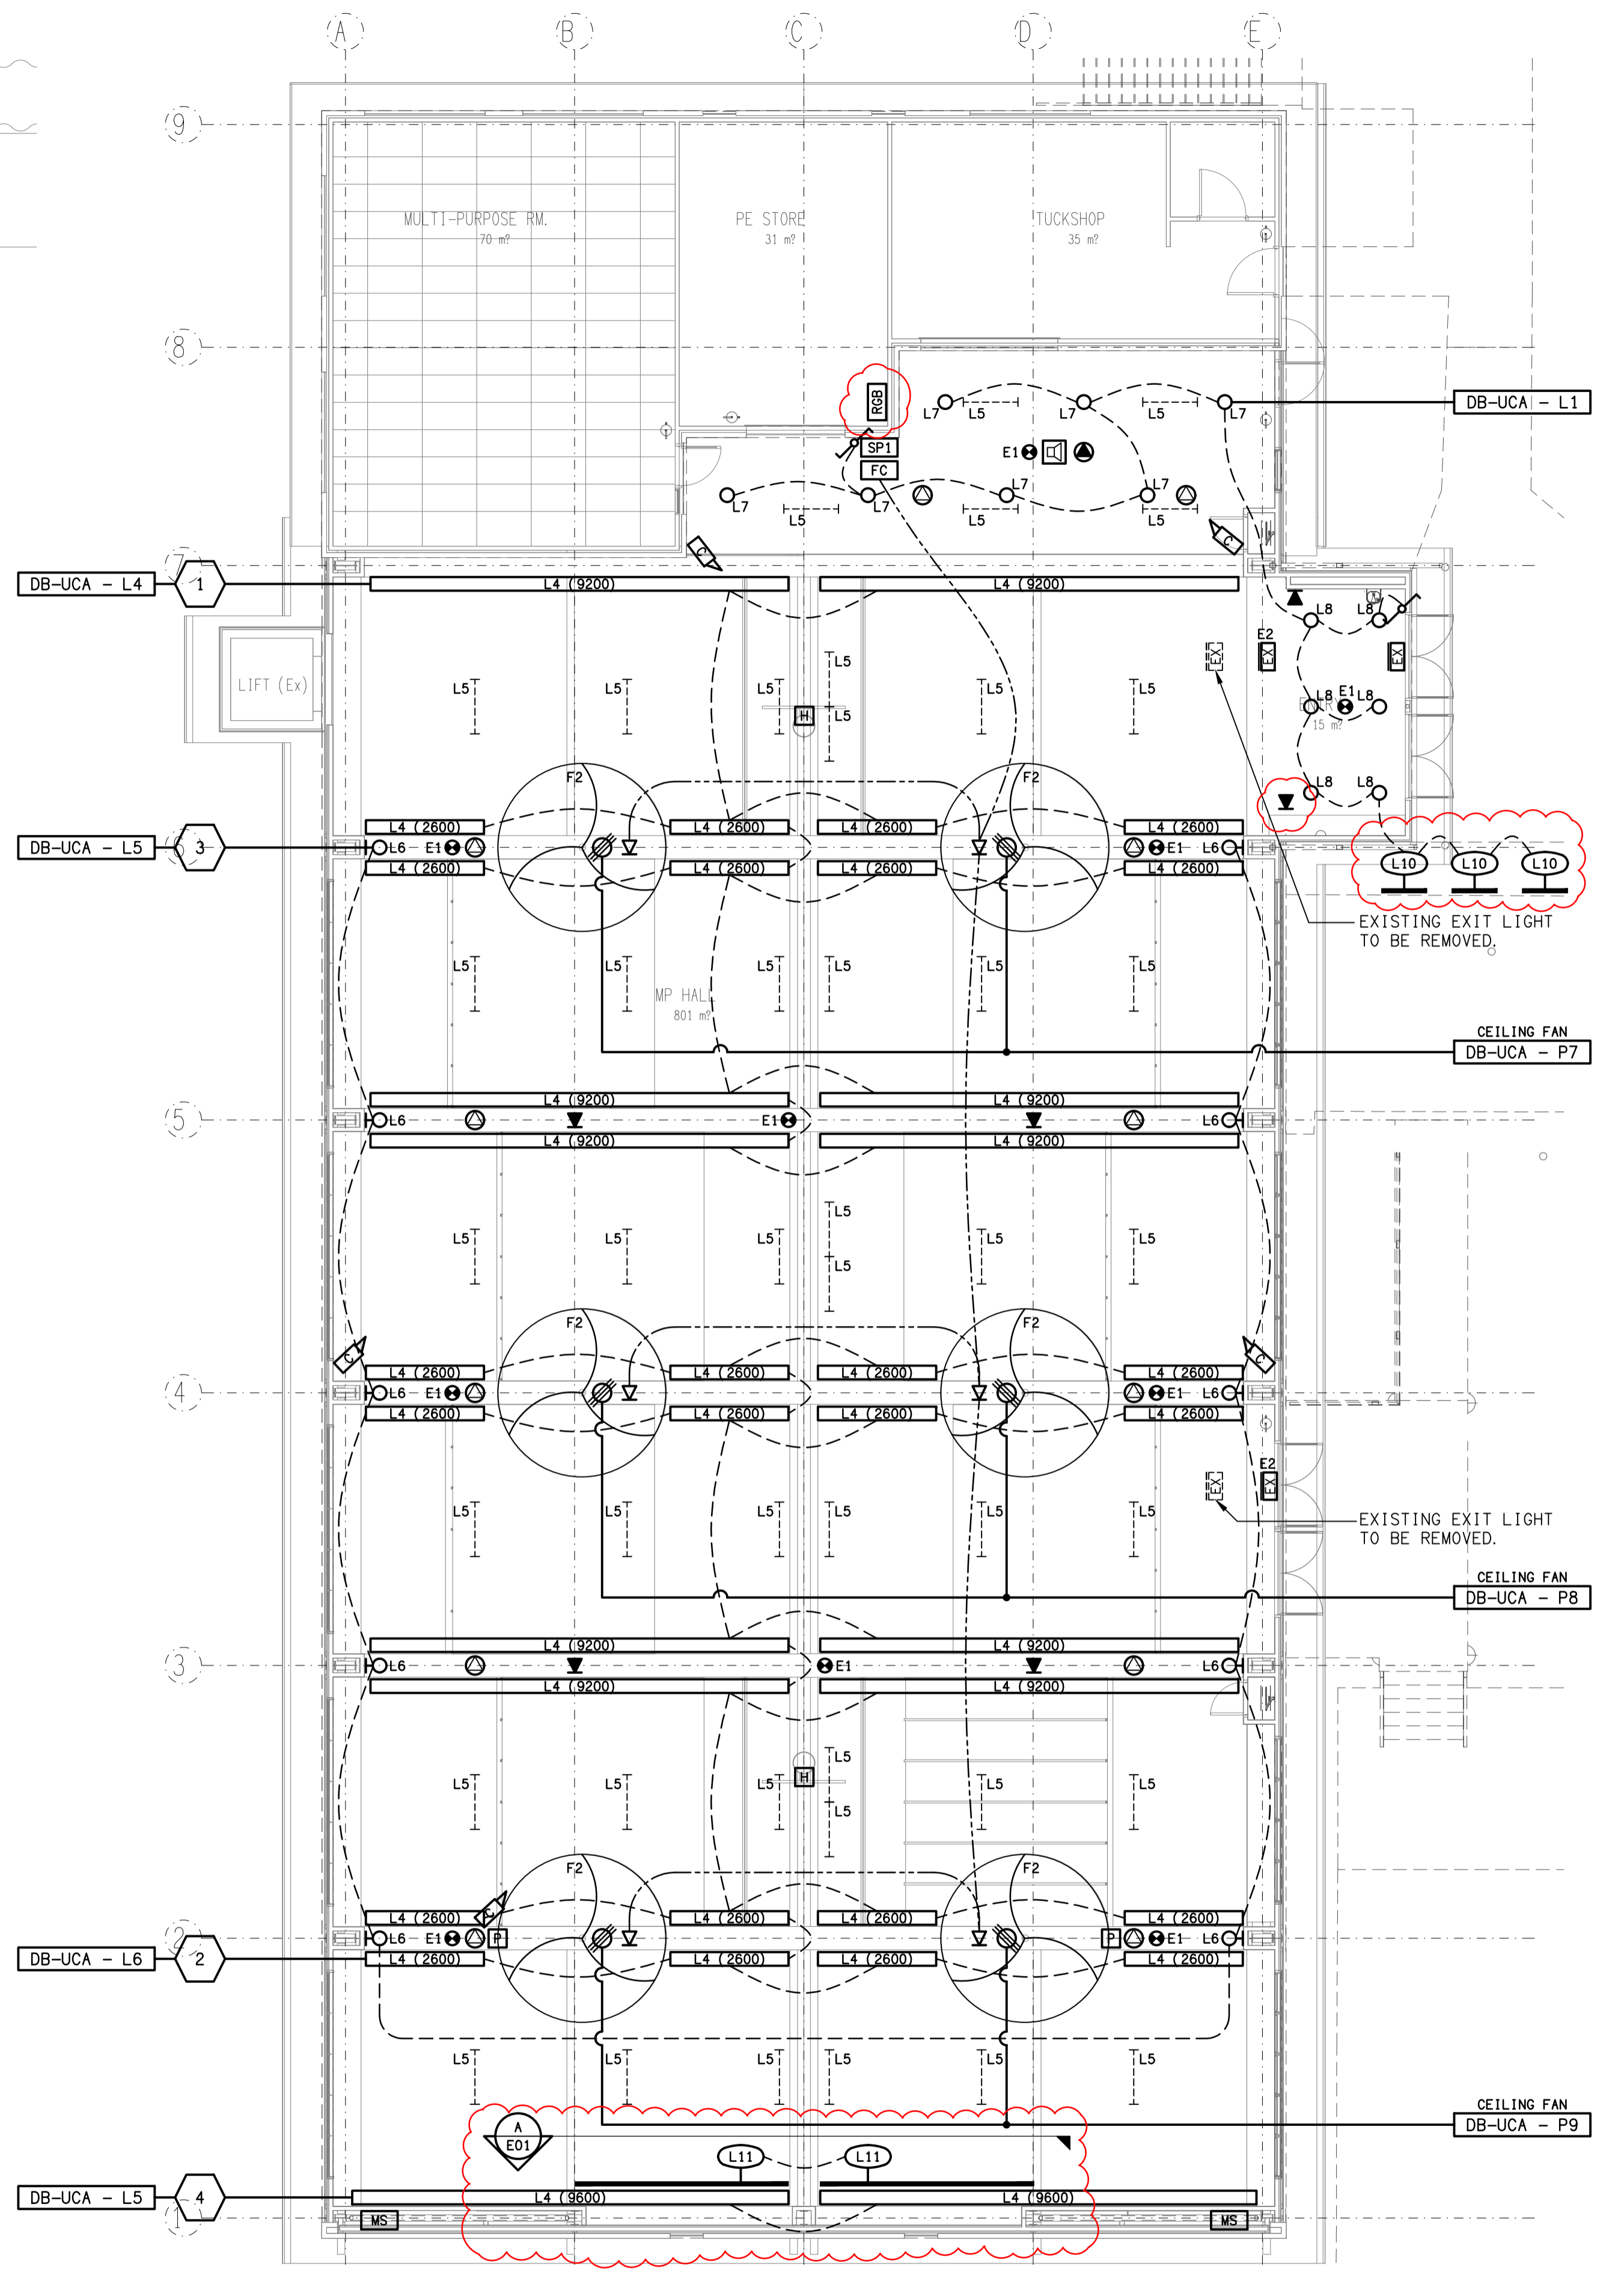

REFLECTED CEILING PLAN
HALL REFURBISHMENT
SCALE 1:100

ELECTRICAL DESIGN GROUP BRISBANE
PTY LTD
ACN 092 710 793
TRADING AS:
ELECTRICAL DESIGN GROUP

THE COPYRIGHT OF THIS DRAWING
REMAINS THE PROPERTY OF THE
ELECTRICAL DESIGN GROUP.
USE FIGURED DIMENSIONS
IN PREFERENCE TO SCALE.
ALL DIMENSIONS TO BE
VERIFIED ONSITE.

ELECTRICAL DESIGN GROUP
ELECTRICAL BUILDING SERVICES CONSULTANTS
BRISBANE GOLD COAST
P.O. Box 15, Sherwood Q.4075
Phone: (07) 3278 4375
Email: brisbane@edg.net.au
Web: www.edg.net.au

PROJECT:
**ST PIUS PRIMARY SCHOOL, BANYO
HALL & GLA REFURBISHMENT**
APPERLEY STREET, BANYO, QUEENSLAND

D	CONSTRUCTION	20/03/2026
REV:	DESCRIPTION:	DATE:
DRAWING: ELECTRICAL SERVICES HALL PLANS		
SCALE: 1:100	PROJECT NO: C3491a	DRAWING NO: E03
AT A1	REVISION: D	