














 




 









 
 


 


 
 
 
 
 


 
 


 





 
 
 





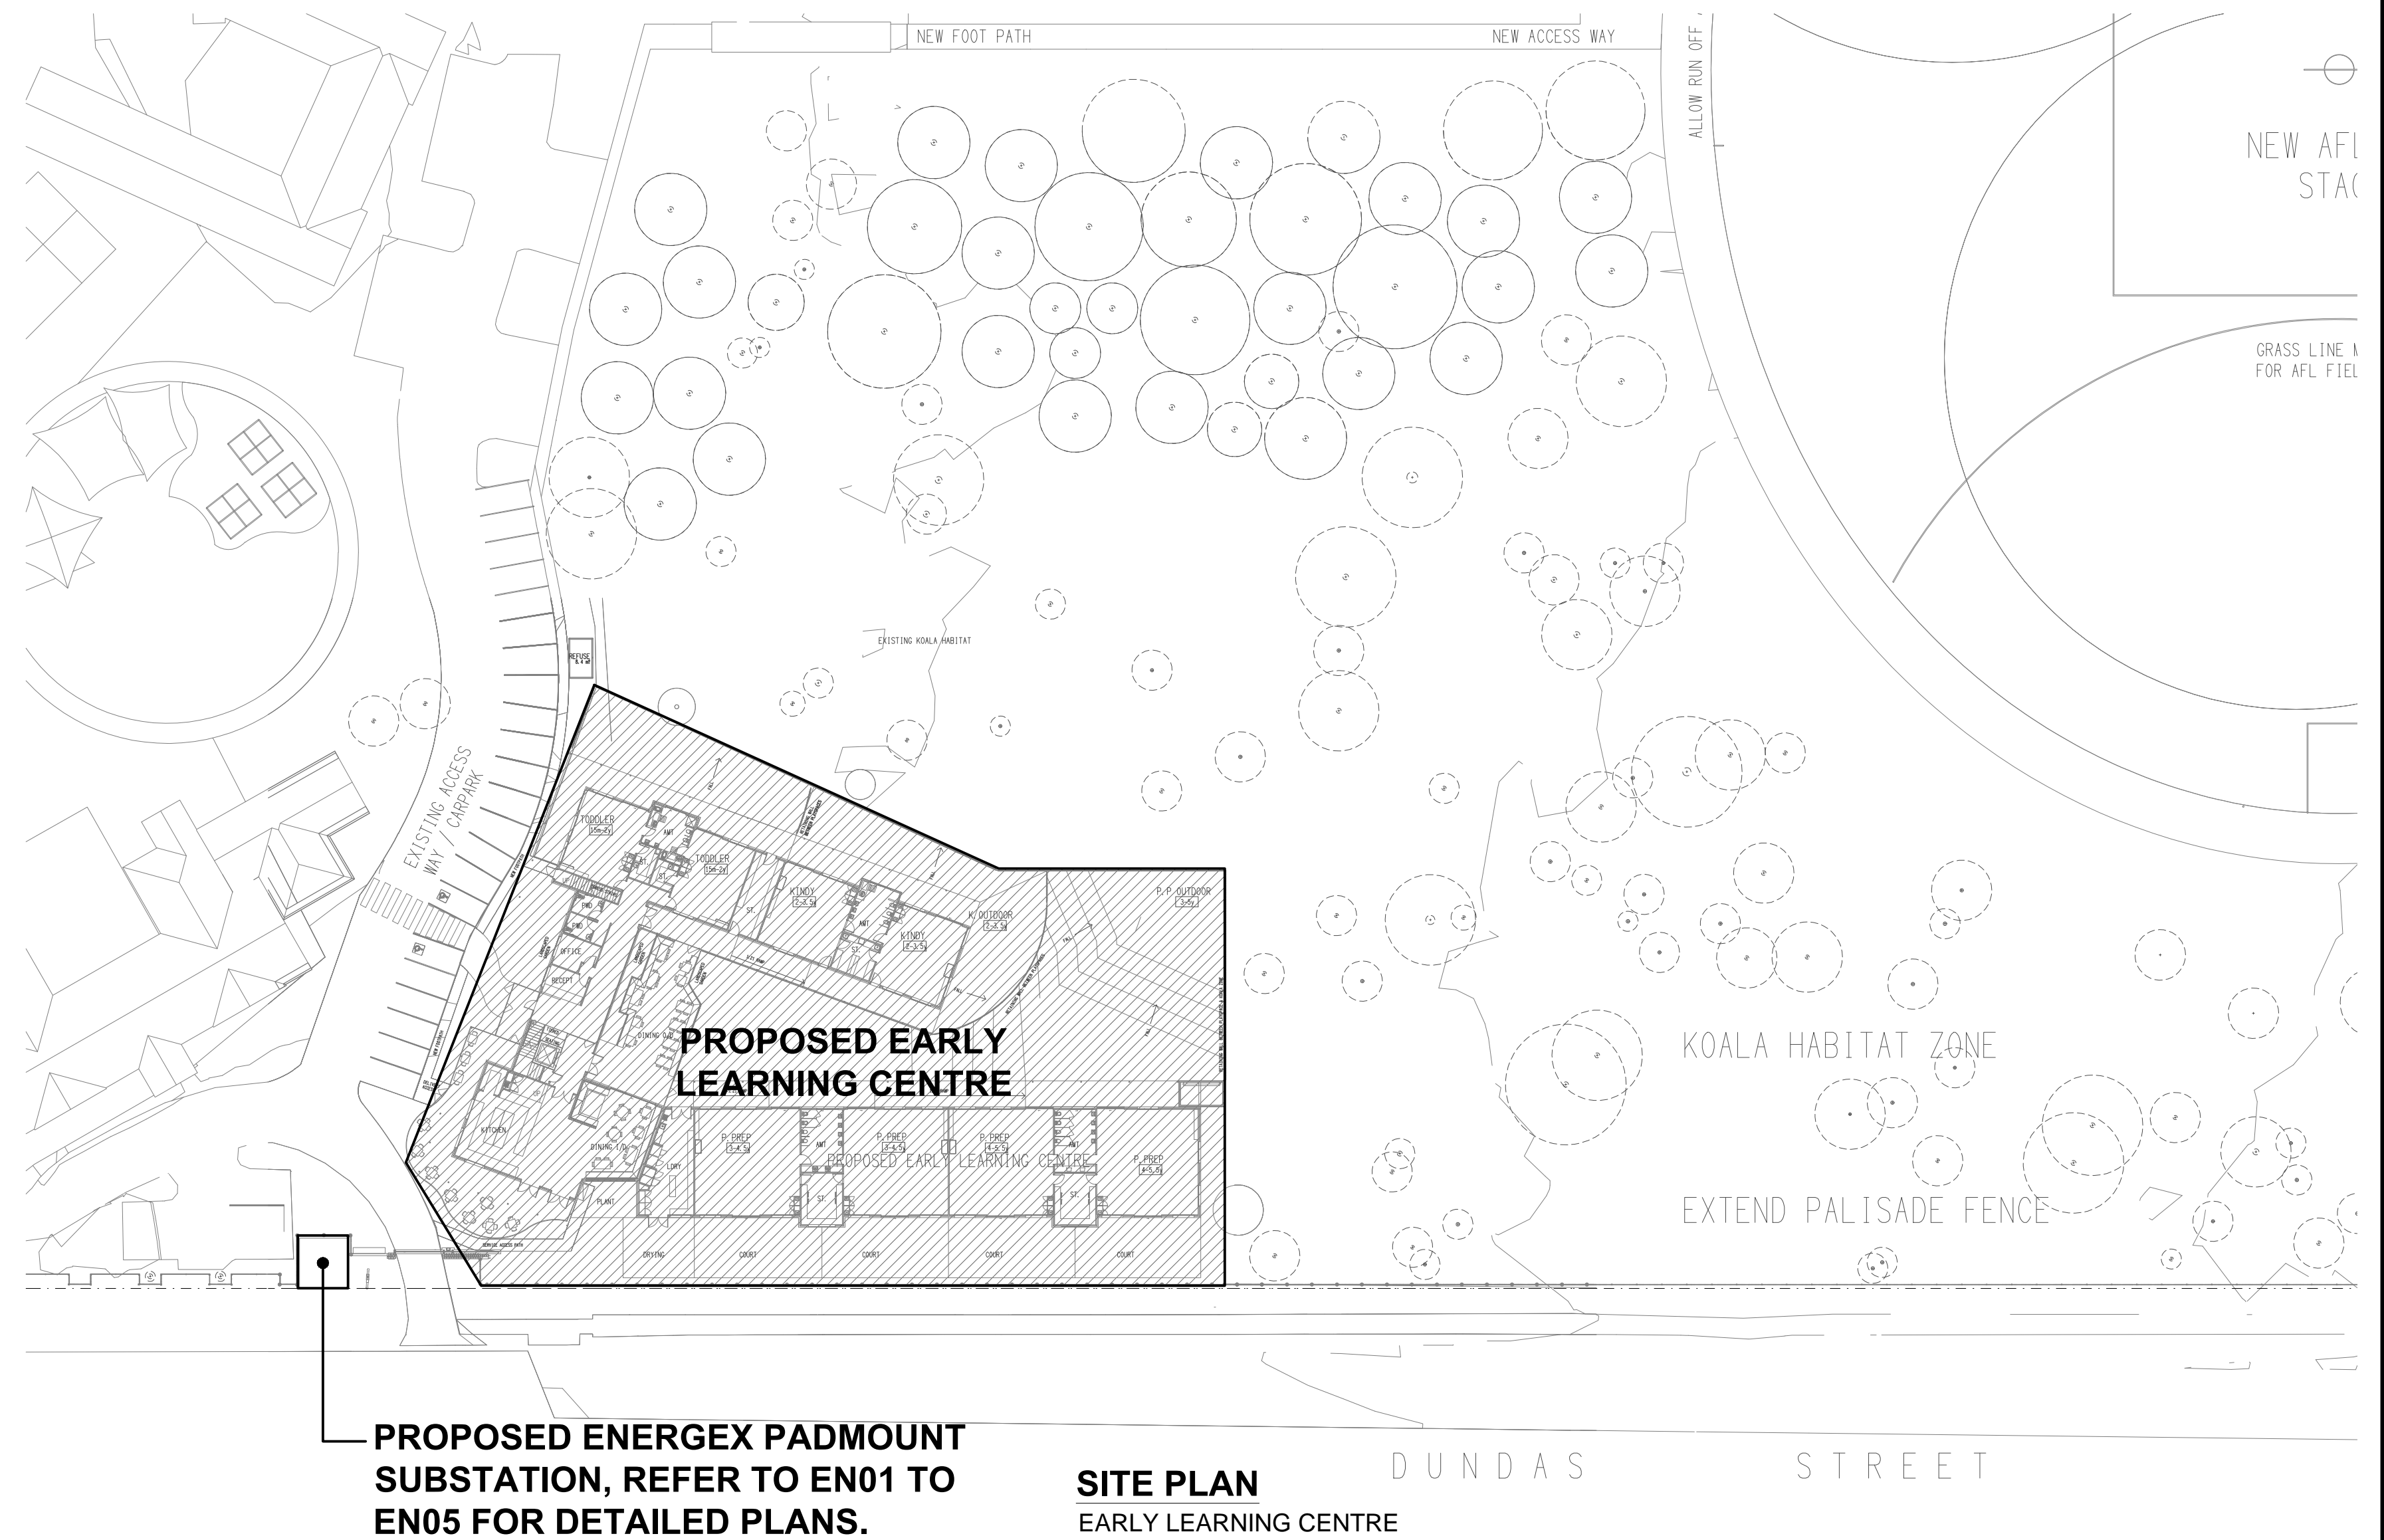


LEGEND

	ELECTRICAL SERVICES SWITCHBOARD.
	SWITCHBOARD / CONTROL PANEL NOT PROVIDED AS PART OF THE ELECTRICAL SUBCONTRACT.
	SINGLE POWER OUTLET.
	DOUBLE POWER OUTLET.
USB 	DOUBLE POWER OUTLET C/W USB CHARGER.
	SPECIAL PURPOSE POWER OUTLET.
	SINGLE PHASE ISOLATOR.
	THREE PHASE ISOLATOR.
	JUNCTION BOX.
— x —	x DENOTES CONDUIT TYPE.
PIT x 	ELECTRICAL PIT, TYPE AS NOTED.
	HAND DRYER CONNECTION.
	LIGHTING PRESENCE DETECTOR SWITCH.
	ONE-WAY LIGHT SWITCH.
	TWO-WAY LIGHT SWITCH.
	MANUAL DALI POT DIMMER.
—	CIRCUIT LINE.
— — —	SWITCH LINE.
	POWER CIRCUIT DESIGNATION. DENOTES DB AND CIRCUIT.
	MAIN DISTRIBUTION FRAME.
	ELECTRICAL EQUIPMENT AS NOTED.
RK	OUTLET MOUNTED IN RECESS KIT.
	HDMI OUTLET.
	RJ45 COMMUNICATIONS OUTLET.
	ACCESS CONTROL CARD READER.
	ACCESS CONTROL DOOR ELECTRIC STRIKE.
	SECURITY KEY PAD.
	SECURITY DIRECTIONAL MOTION DETECTOR.
	SECURITY SIREN STROBE.
	SECURITY PIEZO SIREN.
	SECURITY OVER RIDE SWITCH.
	PA HORN / HOOTER.
	PA MULTI-TAP CONE SPEAKER.

LEGEND

	PRIVATE METER.
	FUSE.
	SINGLE PHASE.
	THREE PHASE.
	CURRENT TRANSFORMER C/W REMOVABLE LINK.
	FUSE LINK.
	COMBINED FUSE SWITCH.
	CIRCUIT BREAKER.
	ISOLATOR.
	RESIDUAL CURRENT DEVICE.
	CONTACTOR - NORMALLY OPEN.
	CONTACTOR - NORMALLY CLOSED.
	REFER TO DETAIL NOTED FOR THE AREA SHOWN HATCHED. ADDITIONAL OUTLETS & FITTINGS MAY BE SHOWN ON DETAIL.
	E1: GENERAL RECESSED LED EMERGENCY LIGHT.
	EX: EMERGENCY LED EXIT LIGHT.
	L1: 600 x 600 RECESSED DALI DIMMABLE LED PANEL LIGHT.
	L2: 600 x 600 RECESSED LED PANEL LIGHT.
	L3: RECESSED DALI DIMMABLE LED DOWNLIGHT.
	L4: SMALL RECESSED DALI DIMMABLE LED DOWNLIGHT.
	L5: 300 x 1200 RECESSED LED PANEL LIGHT.
	L6: ADJUSTABLE EXTERNAL RECESSED LED DOWNLIGHT.
	L7: DALI DIMMABLE LED SUSPENDED EXTRUSION.
	L8: RECEPTION SUSPENDED LED EXTRUSION.
	L9: RECESSED LED DOWNLIGHT.
	L10: KITCHEN RECESSED LED DOWNLIGHT.
	L11: ENTRY WALL LIGHT.
	L12: AMENITY RECESSED LED DOWNLIGHT.
	L13: RECESSED DALI DIMMABLE LED DOWNLIGHT.
	L14: SUSPENDED DALI DIMMABLE LED EXTRUSION.
	L15: SUSPENDED CUSTOM CURVED LED EXTRUSION.
	L16: SUSPENDED CUSTOM CURVED LED EXTRUSION.
	L17: SUSPENDED CUSTOM CURVED LED EXTRUSION.
	L18: SUSPENDED CUSTOM CURVED LED EXTRUSION.



A	PRELIMINARY	02/03/2026	
REV:	DESCRIPTION:	DATE:	
DRAWING: ELECTRICAL SERVICES LEGEND & SITE PLAN			
SCALE: 1:500 & 1:250	AT A1	PROJECT NO: C3514a	DRAWING NO: E01
		REVISION: A	