


THE COPYRIGHT OF THIS DRAWING REMAINS THE PROPERTY OF THE ELECTRICAL DESIGN GROUP.

USE FIGURED DIMENSIONS IN PREFERENCE TO SCALE.

ALL DIMENSIONS TO BE VERIFIED ONSITE.

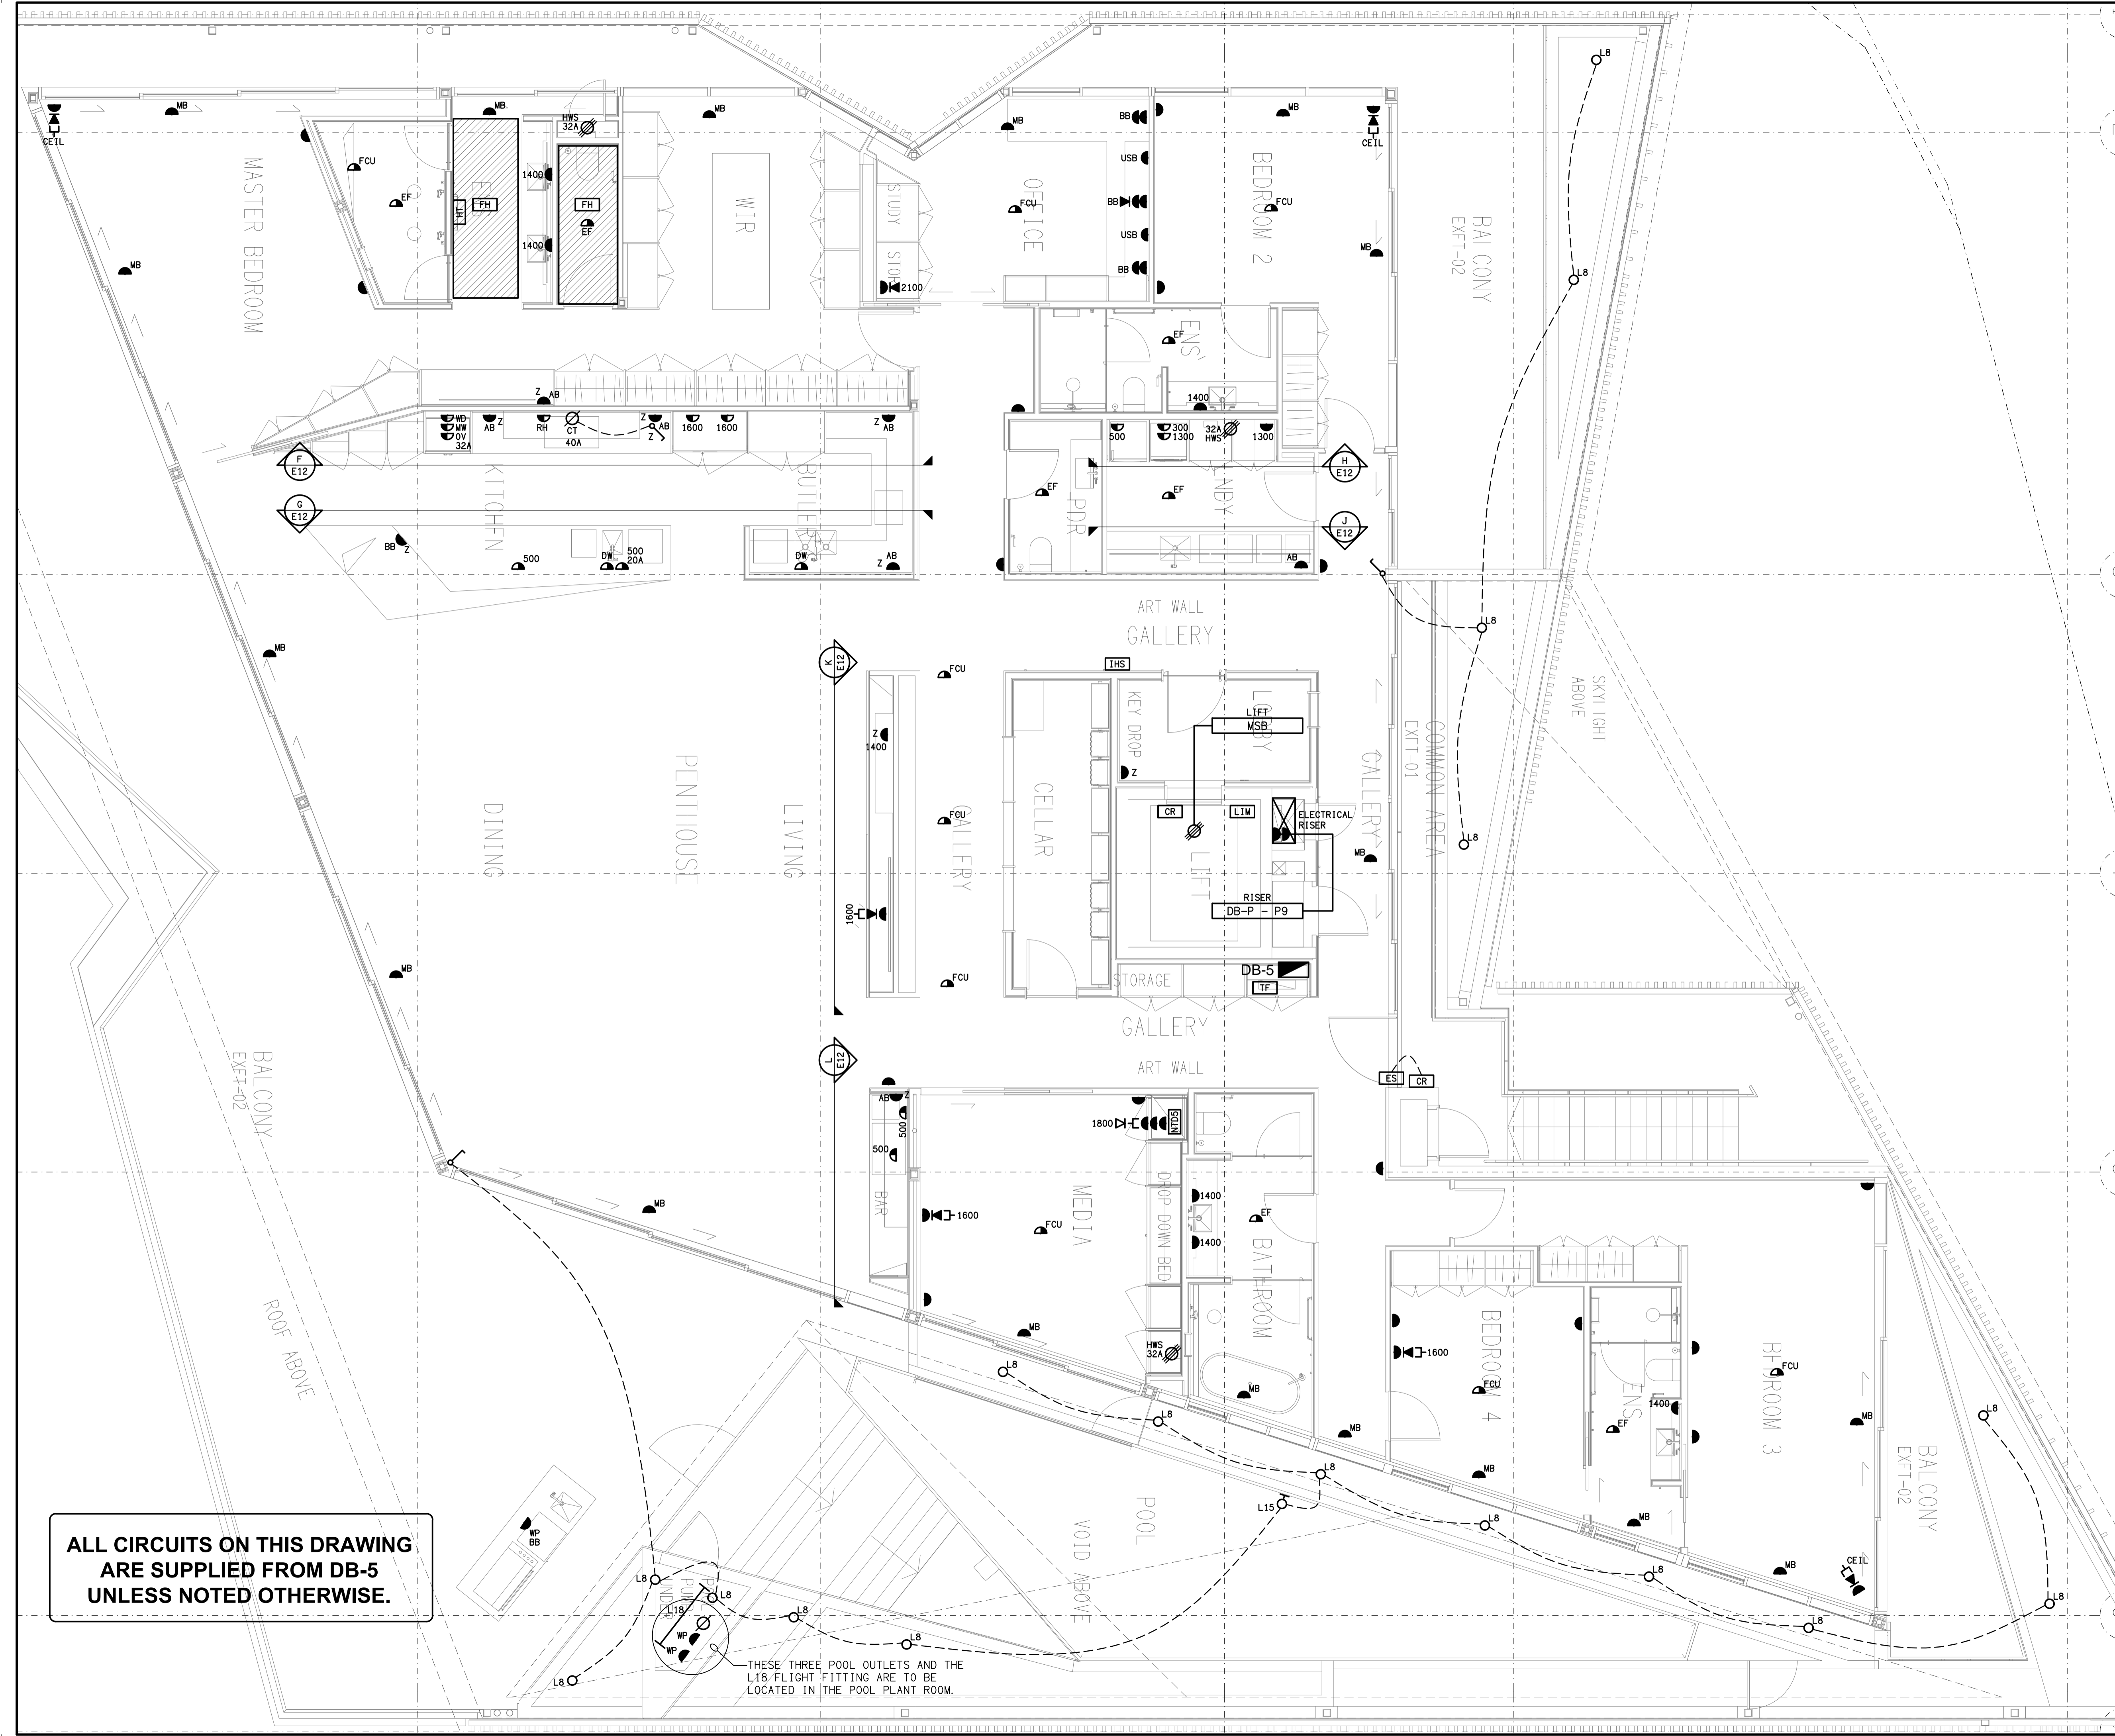

ALL CIRCUITS ON THIS DRAWING ARE SUPPLIED FROM DB-5 UNLESS NOTED OTHERWISE.

THESE THREE POOL OUTLETS AND THE L18 FLIGHT FITTING ARE TO BE LOCATED IN THE POOL PLANT ROOM.

C	TENDER	28/04/2026
REV:	DESCRIPTION:	DATE:

ELECTRICAL DESIGN GROUP
ELECTRICAL BUILDING SERVICES CONSULTANTS

BRISBANE: P.O. Box 15 Sherwood Qld 4075
Phone: (07) 3278 4375
Email: brisbane@edg.net.au
Web: www.edg.net.au

ELECTRICAL DESIGN GROUP BRISBANE PTY LTD
ACN 092 710 793

TRADING AS:
ELECTRICAL DESIGN GROUP

PROJECT:
TI-TREE COLLECTIVE

SITE ADDRESS:
294-298 GIVEN TERRACE, PADDINGTON
BRISBANE, QUEENSLAND

SCALE: 1:50 SHEET SIZE: AT A1

DRAWING TITLE:
**ELECTRICAL SERVICES
LEVEL 2
FLOOR PLAN**

PROJECT NO. DRAWING NO. REVISION:
C3599a E10 C