


THE COPYRIGHT OF THIS DRAWING REMAINS THE PROPERTY OF THE ELECTRICAL DESIGN GROUP.

USE FIGURED DIMENSIONS IN PREFERENCE TO SCALE.

ALL DIMENSIONS TO BE VERIFIED ONSITE.

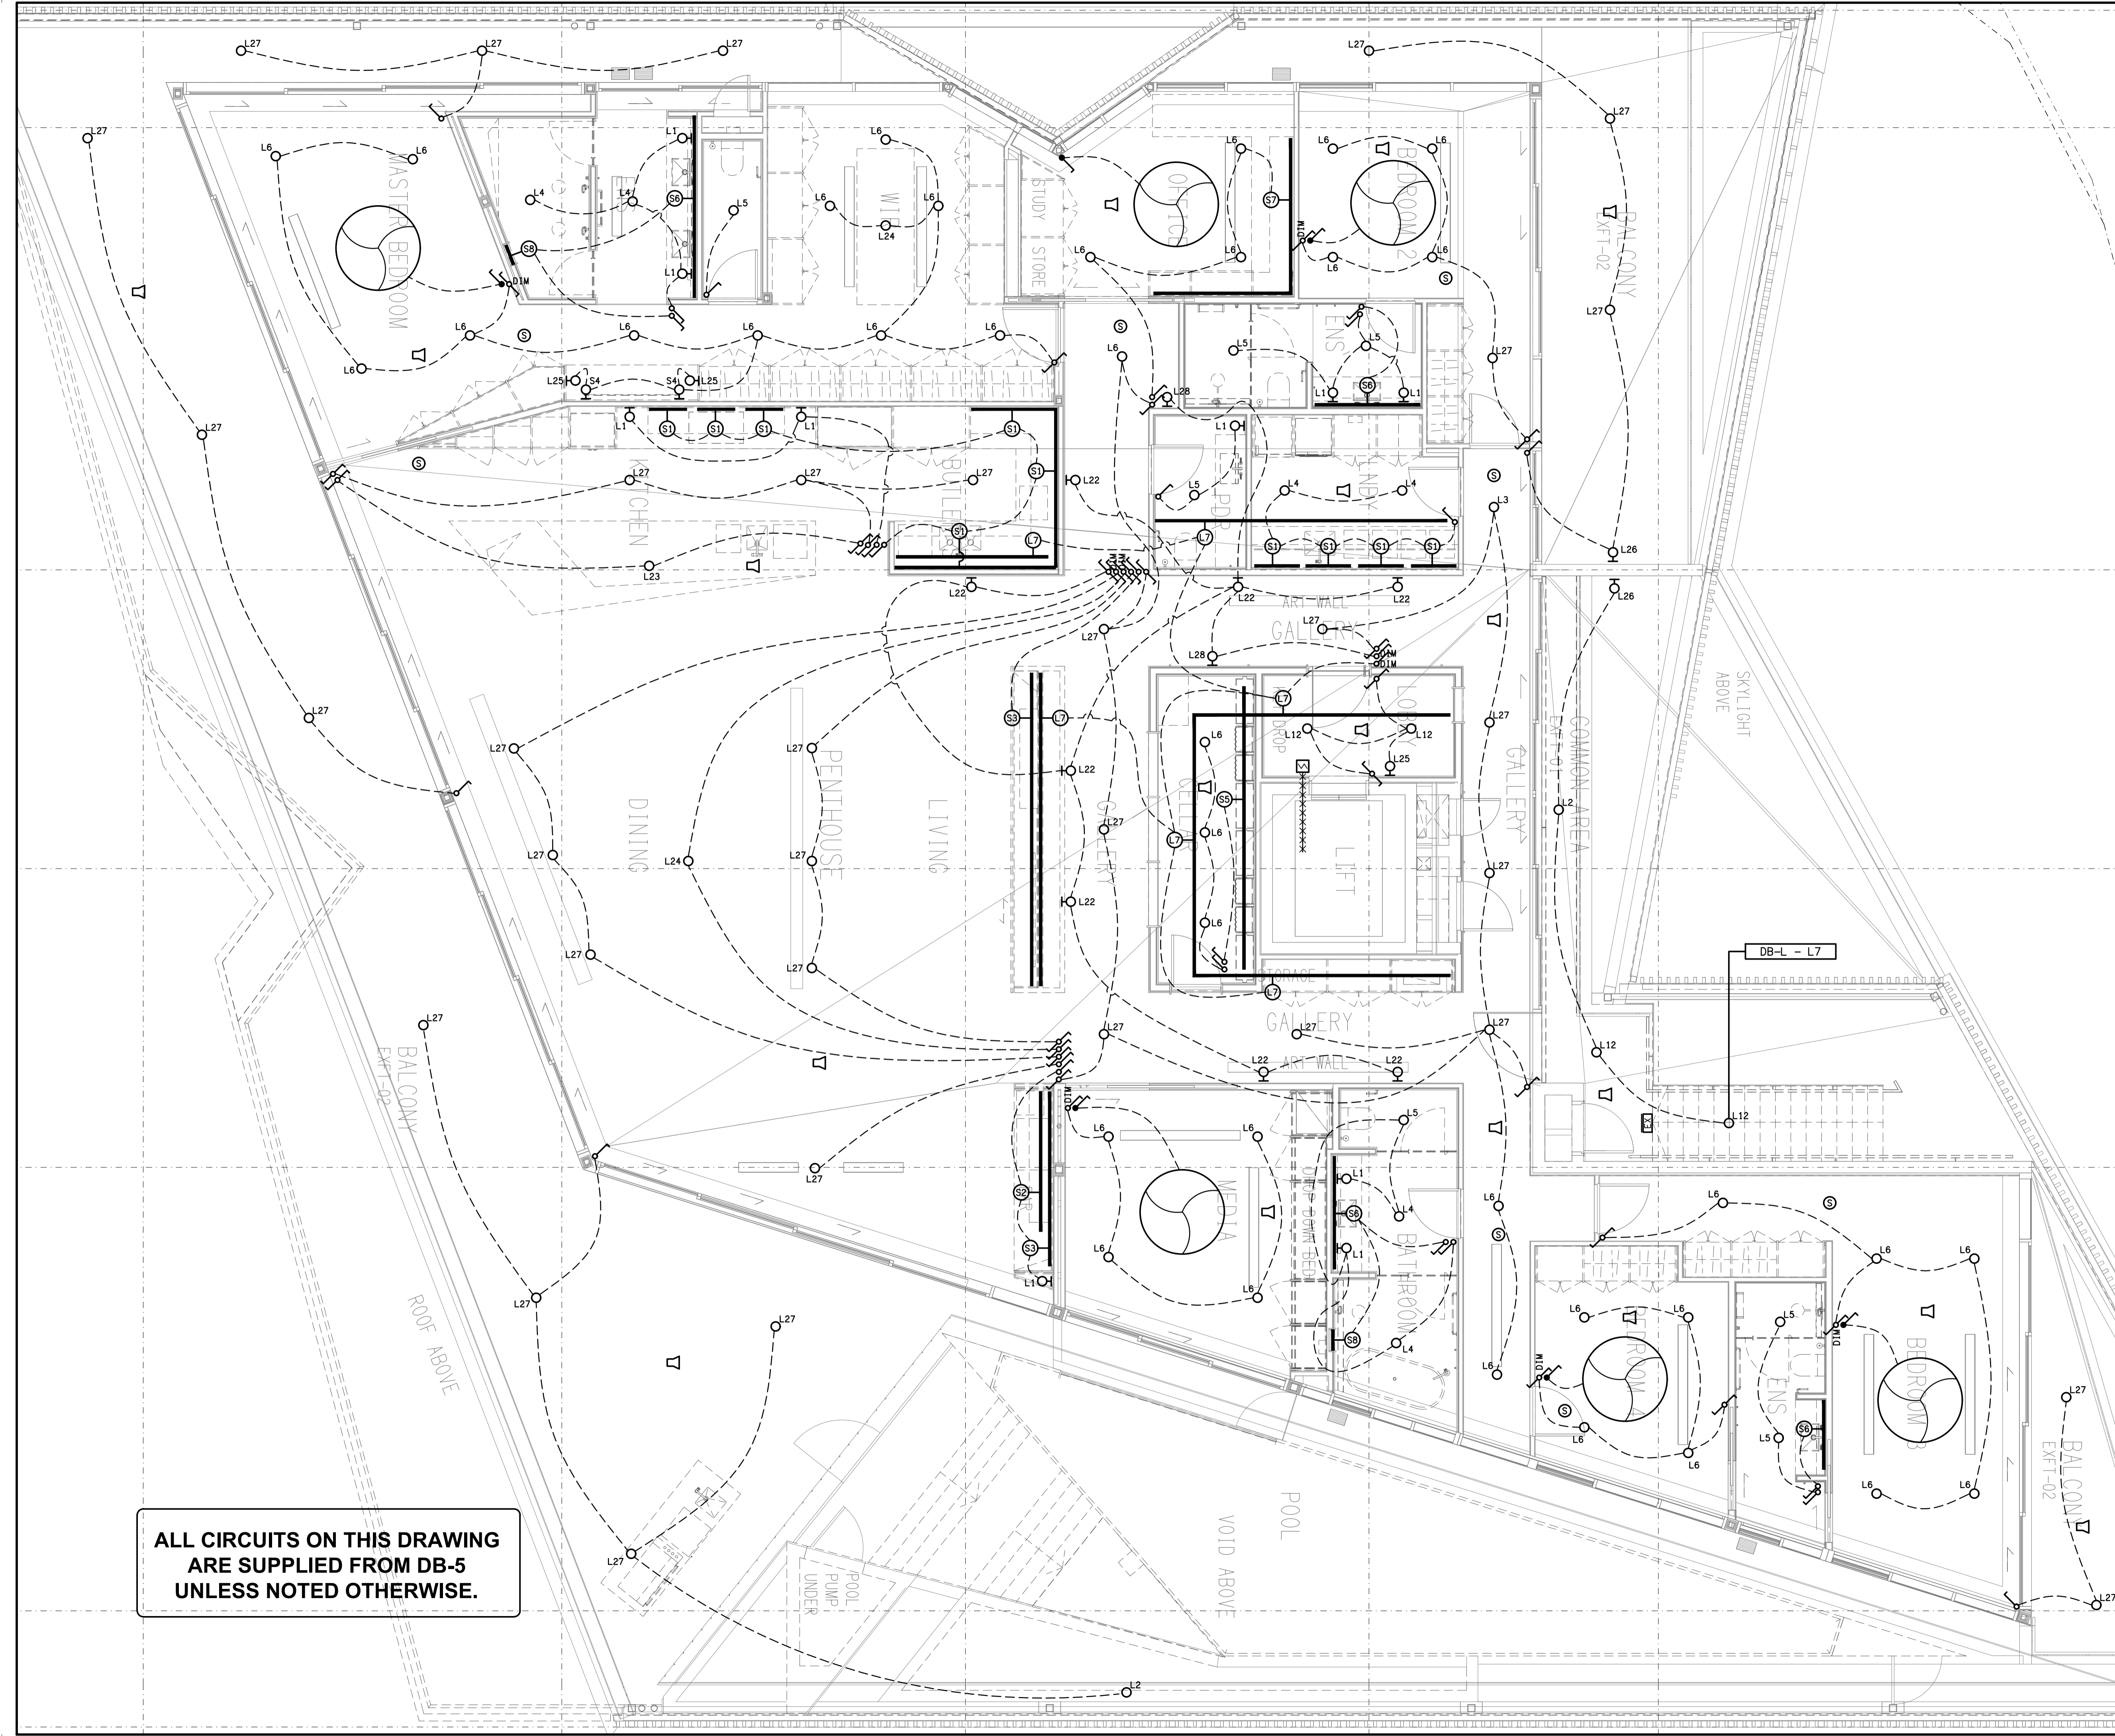

C	TENDER	28/04/2026
REV:	DESCRIPTION:	DATE:

ELECTRICAL DESIGN GROUP
ELECTRICAL BUILDING SERVICES CONSULTANTS

BRISBANE: P.O. Box 15 Sherwood Qld 4075
Phone: (07) 3278 4375
Email: brisbane@edg.net.au
Web: www.edg.net.au

ELECTRICAL DESIGN GROUP BRISBANE PTY LTD
ACN 092 710 793

TRADING AS:
ELECTRICAL DESIGN GROUP

PROJECT:
TI-TREE COLLECTIVE

SITE ADDRESS:
294-298 GIVEN TERRACE, PADDINGTON
BRISBANE, QUEENSLAND

SCALE: 1:50 SHEET SIZE: AT A1

DRAWING TITLE:
**ELECTRICAL SERVICES
LEVEL 2
REFLECTED CEILING PLAN**

PROJECT NO. DRAWING NO. REVISION:

C3599a E11 C

**ALL CIRCUITS ON THIS DRAWING
ARE SUPPLIED FROM DB-5
UNLESS NOTED OTHERWISE.**