


CONFIRM THE COFFEE OUTLET TYPE AND SIZE WITH THE COFFEE MACHINE SUPPLIER PRIOR TO ORDERING.

**ALL EXISTING ELECTRICAL SERVICES WITHIN THIS AREA TO BE REMOVED, UNLESS NOTED OTHERWISE.**

**FLOOR PLAN**  
GAMING ROOM  
SCALE 1:50

**NOTE:**  
THE LIGHTING CONTROL CHANNELS THAT CONTROL THE DB-G CIRCUITS ARE TO CONTAIN FACILITY IN DB-D TO ALLOW THE GAMING ELECTRICIAN TO CONNECT THE CIRCUITS TO THE CONTROLLERS IN DB-D.

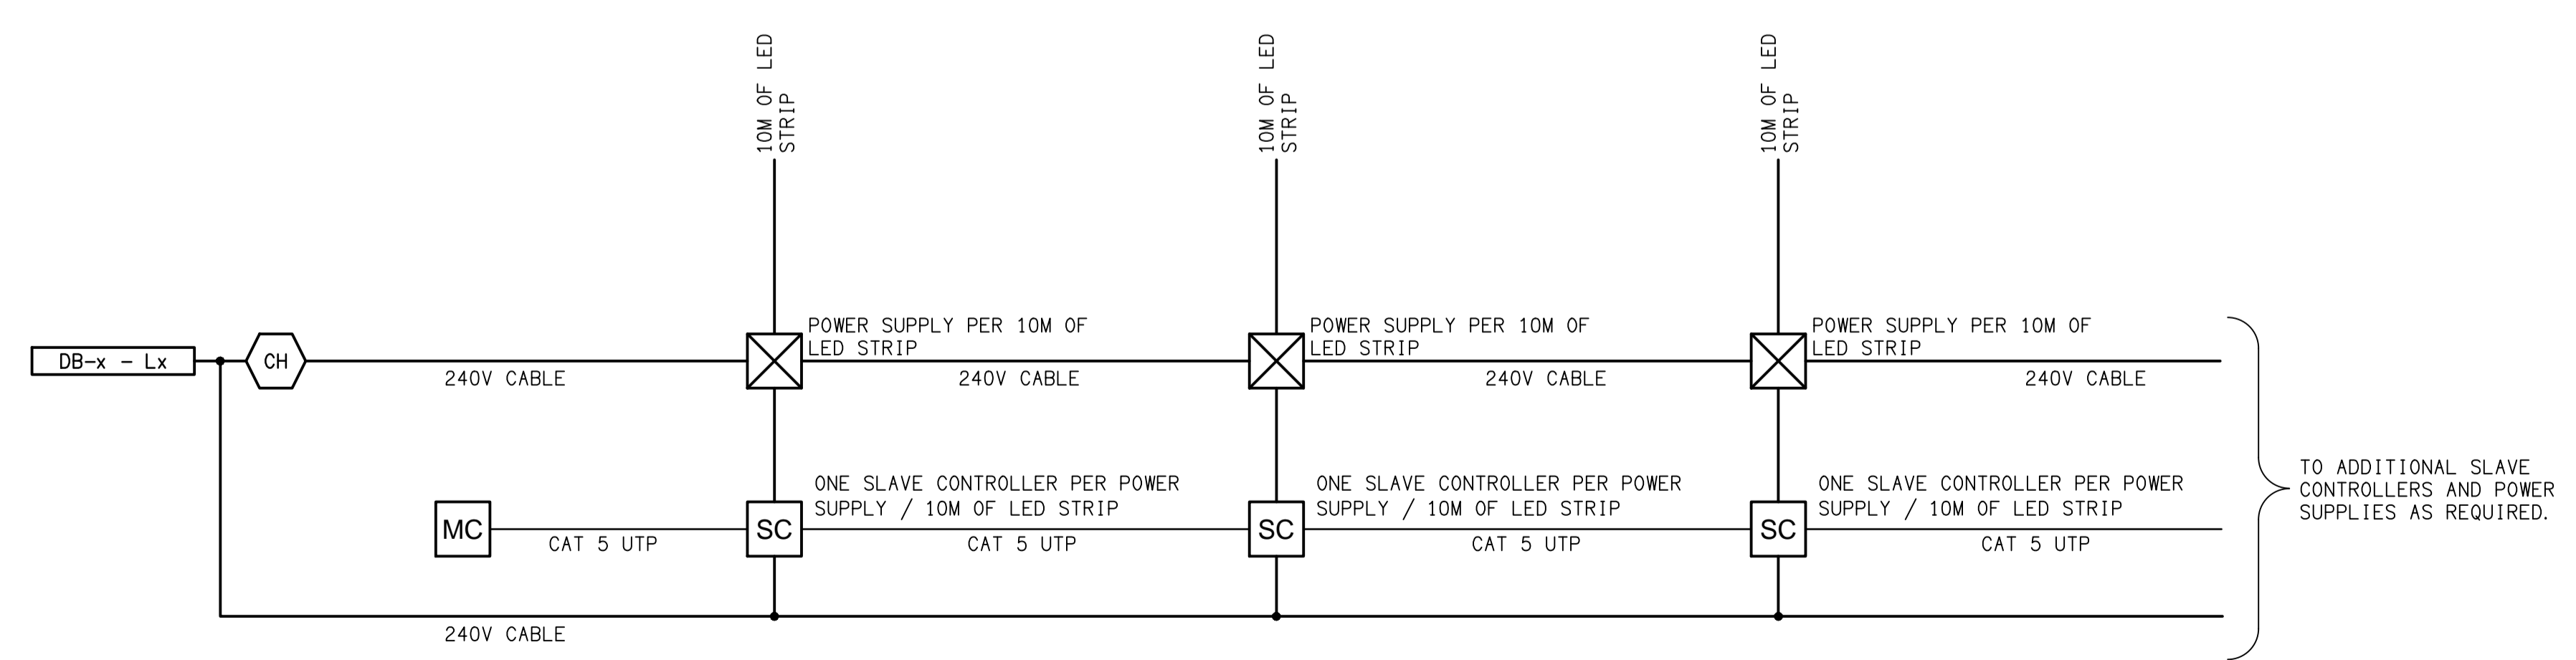

**SCHEMATIC**  
RGB CONTROL  
NOT TO SCALE

TO ADDITIONAL SLAVE CONTROLLERS AND POWER SUPPLIES AS REQUIRED.

F	CONSTRUCTION	07/04/2026
REV:	DESCRIPTION:	DATE:

**ELECTRICAL DESIGN GROUP**  
ELECTRICAL BUILDING SERVICES CONSULTANTS

BRISBANE: P.O. Box 15 Sherwood Qld 4075  
Phone: (07) 3278 4375  
Email: brisbane@edg.net.au  
Web: www.edg.net.au

ELECTRICAL DESIGN GROUP BRISBANE PTY LTD  
ACN 092 710 793

TRADING AS:  
ELECTRICAL DESIGN GROUP

PROJECT:  
**BENOWA TAVERN**

SITE ADDRESS:  
117 ASHMORE ROAD, BENOWA  
GOLD COAST

SCALE: 1:50 SHEET SIZE: AT A1

DRAWING TITLE:

**ELECTRICAL SERVICES**  
GAMING ROOM  
FLOOR PLAN

PROJECT NO. DRAWING NO. REVISION:

**C3600a E06 F**