


THE COPYRIGHT OF THIS DRAWING REMAINS THE PROPERTY OF THE ELECTRICAL DESIGN GROUP.

USE FIGURED DIMENSIONS IN PREFERENCE TO SCALE.

ALL DIMENSIONS TO BE VERIFIED ONSITE.

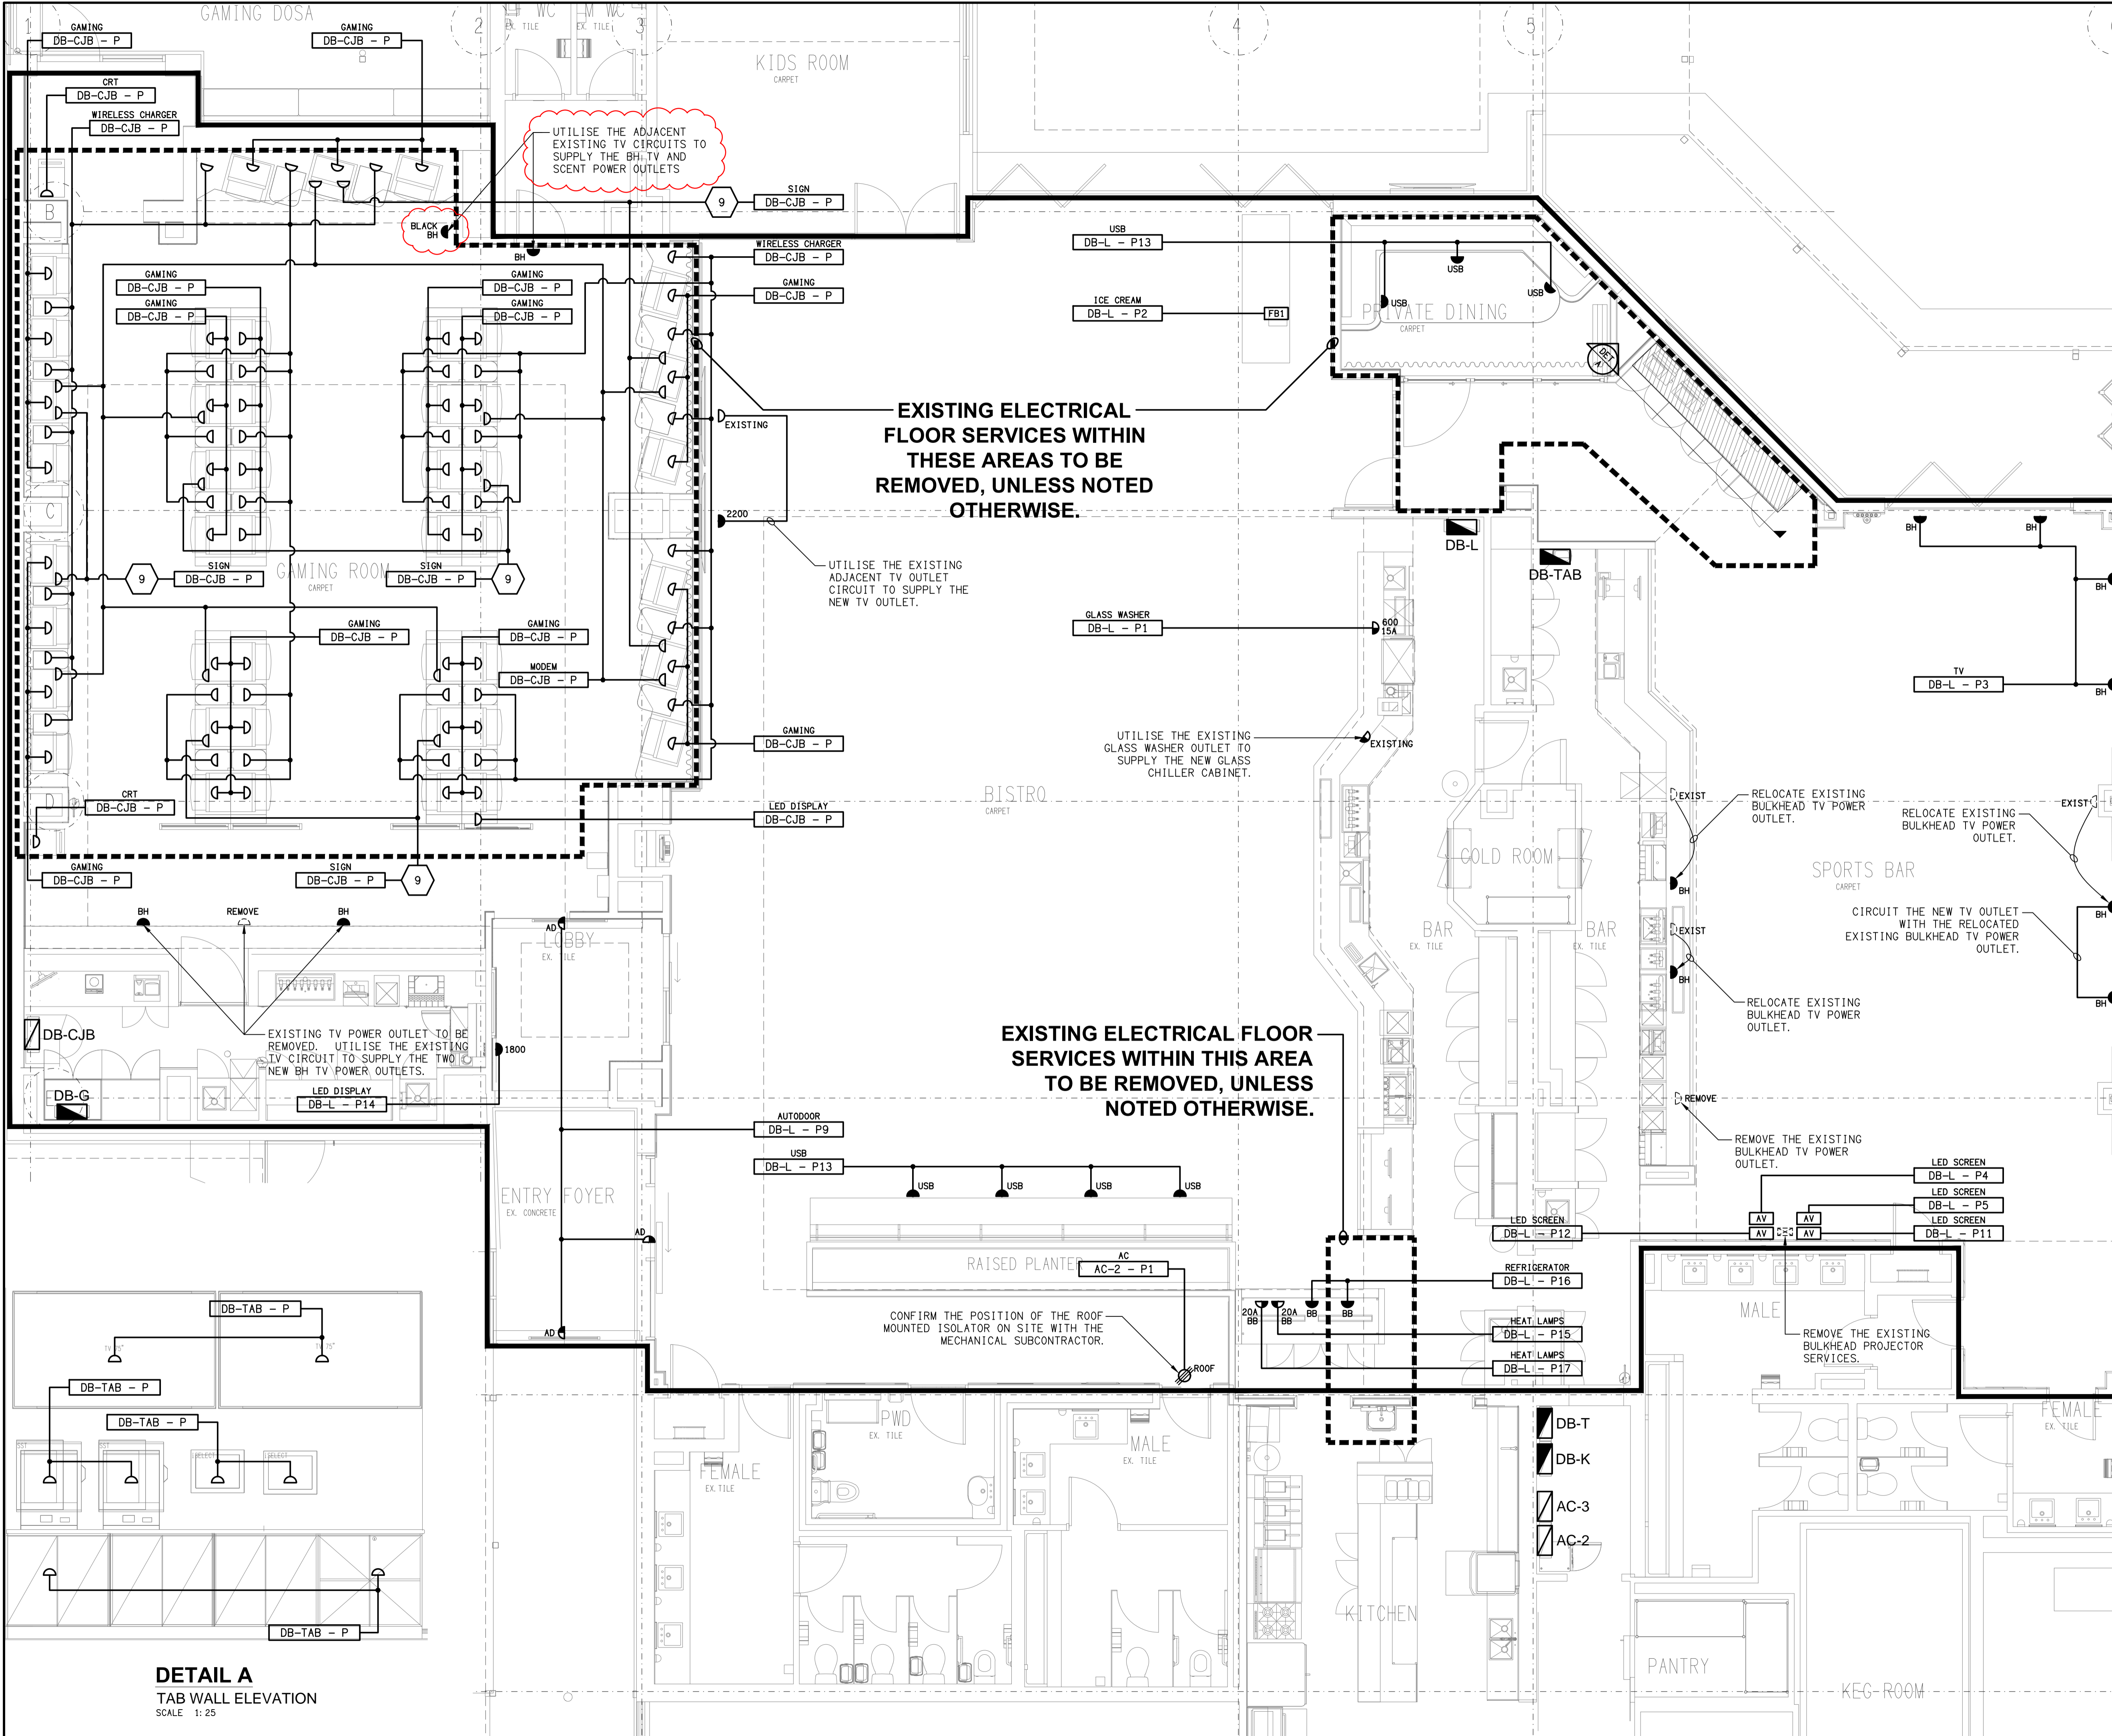

EXISTING ELECTRICAL FLOOR SERVICES WITHIN THESE AREAS TO BE REMOVED, UNLESS NOTED OTHERWISE.

EXISTING ELECTRICAL FLOOR SERVICES WITHIN THIS AREA TO BE REMOVED, UNLESS NOTED OTHERWISE.

UTILISE THE ADJACENT EXISTING TV CIRCUITS TO SUPPLY THE BH TV AND SCENT POWER OUTLETS

UTILISE THE EXISTING ADJACENT TV OUTLET CIRCUIT TO SUPPLY THE NEW TV OUTLET.

UTILISE THE EXISTING GLASS WASHER OUTLET TO SUPPLY THE NEW GLASS CHILLER CABINET.

EXISTING TV POWER OUTLET TO BE REMOVED. UTILISE THE EXISTING TV CIRCUIT TO SUPPLY THE TWO NEW BH TV POWER OUTLETS.

CONFIRM THE POSITION OF THE ROOF MOUNTED ISOLATOR ON SITE WITH THE MECHANICAL SUBCONTRACTOR.

REMOVE THE EXISTING BULKHEAD TV POWER OUTLET.

RELOCATE EXISTING BULKHEAD TV POWER OUTLET.

RELOCATE EXISTING BULKHEAD TV POWER OUTLET.

DETAIL A
TAB WALL ELEVATION
SCALE 1:25

G	CONSTRUCTION	14/04/2026
REV:	DESCRIPTION:	DATE:

ELECTRICAL DESIGN GROUP
ELECTRICAL BUILDING SERVICES CONSULTANTS

BRISBANE: P.O. Box 15 Sherwood Qld 4075
Phone: (07) 3278 4375
Email: brisbane@edg.net.au
Web: www.edg.net.au

ELECTRICAL DESIGN GROUP BRISBANE PTY LTD
ACN 092 710 793

PROJECT:
JIMBOOMBA TAVERN

SITE ADDRESS:
CORNER MT LINDESAY HIGHWAY &
CUSACKS LANE, JIMBOOMBA

SCALE: 1:50 SHEET SIZE: AT A1

DRAWING TITLE:
ELECTRICAL SERVICES FLOOR PLAN

PROJECT NO. DRAWING NO. REVISION:
C3630a E04 G