


THE COPYRIGHT OF THIS DRAWING REMAINS THE PROPERTY OF THE ELECTRICAL DESIGN GROUP.

USE FIGURED DIMENSIONS IN PREFERENCE TO SCALE.

ALL DIMENSIONS TO BE VERIFIED ONSITE.

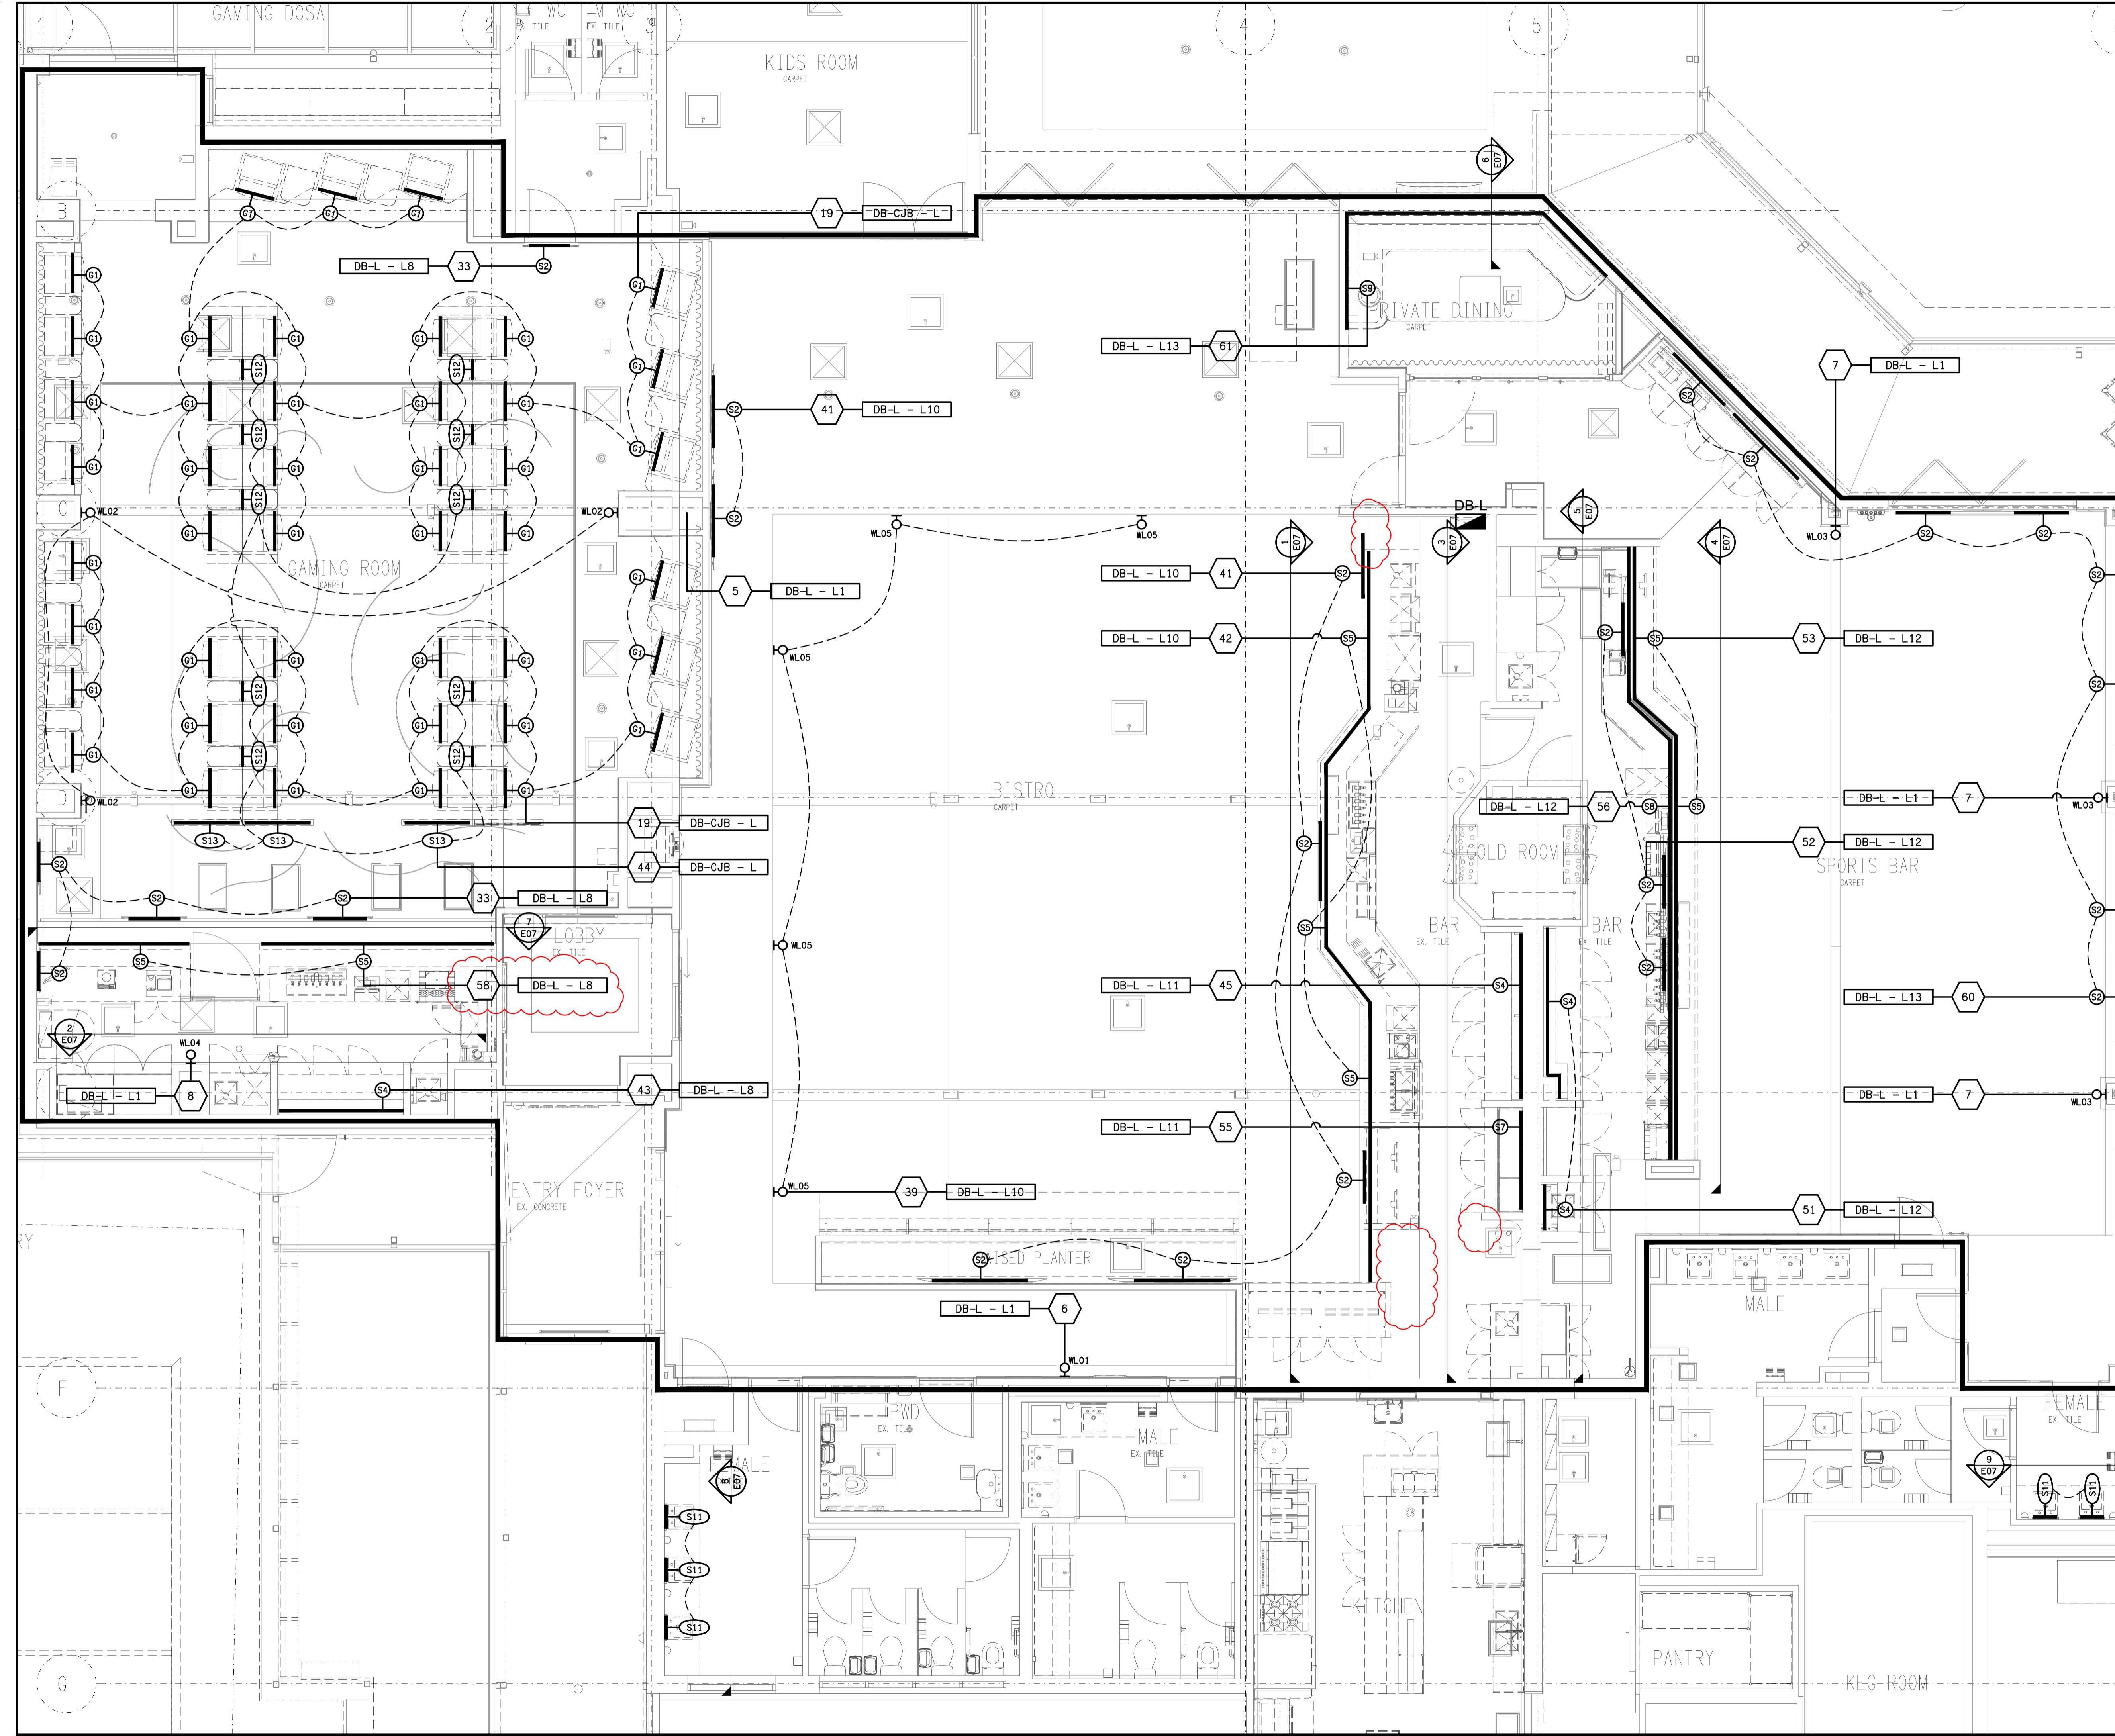

E	CONSTRUCTION	19/03/2026
REV:	DESCRIPTION:	DATE:

ELECTRICAL DESIGN GROUP
ELECTRICAL BUILDING SERVICES CONSULTANTS

BRISBANE: P.O. Box 15 Sherwood Qld 4075
Phone: (07) 3278 4375
Email: brisbane@edg.net.au
Web: www.edg.net.au

ELECTRICAL DESIGN GROUP BRISBANE / TRADING AS: ELECTRICAL DESIGN GROUP
PTY LTD / ACN 092 710 793

PROJECT:
JIMBOOMBA TAVERN

SITE ADDRESS:
CORNER MT LINDESAY HIGHWAY &
CUSACKS LANE, JIMBOOMBA

SCALE: 1:50 SHEET SIZE: AT A1

DRAWING TITLE:
**ELECTRICAL SERVICES
JOINERY & WALL
LIGHTING PLAN**

PROJECT NO. DRAWING NO. REVISION:
C3630a E06 E