


SCHMATIC NO LONGER REQUIRED

REMOVE THE EXISTING LIGHTING WITHIN THIS AREA.

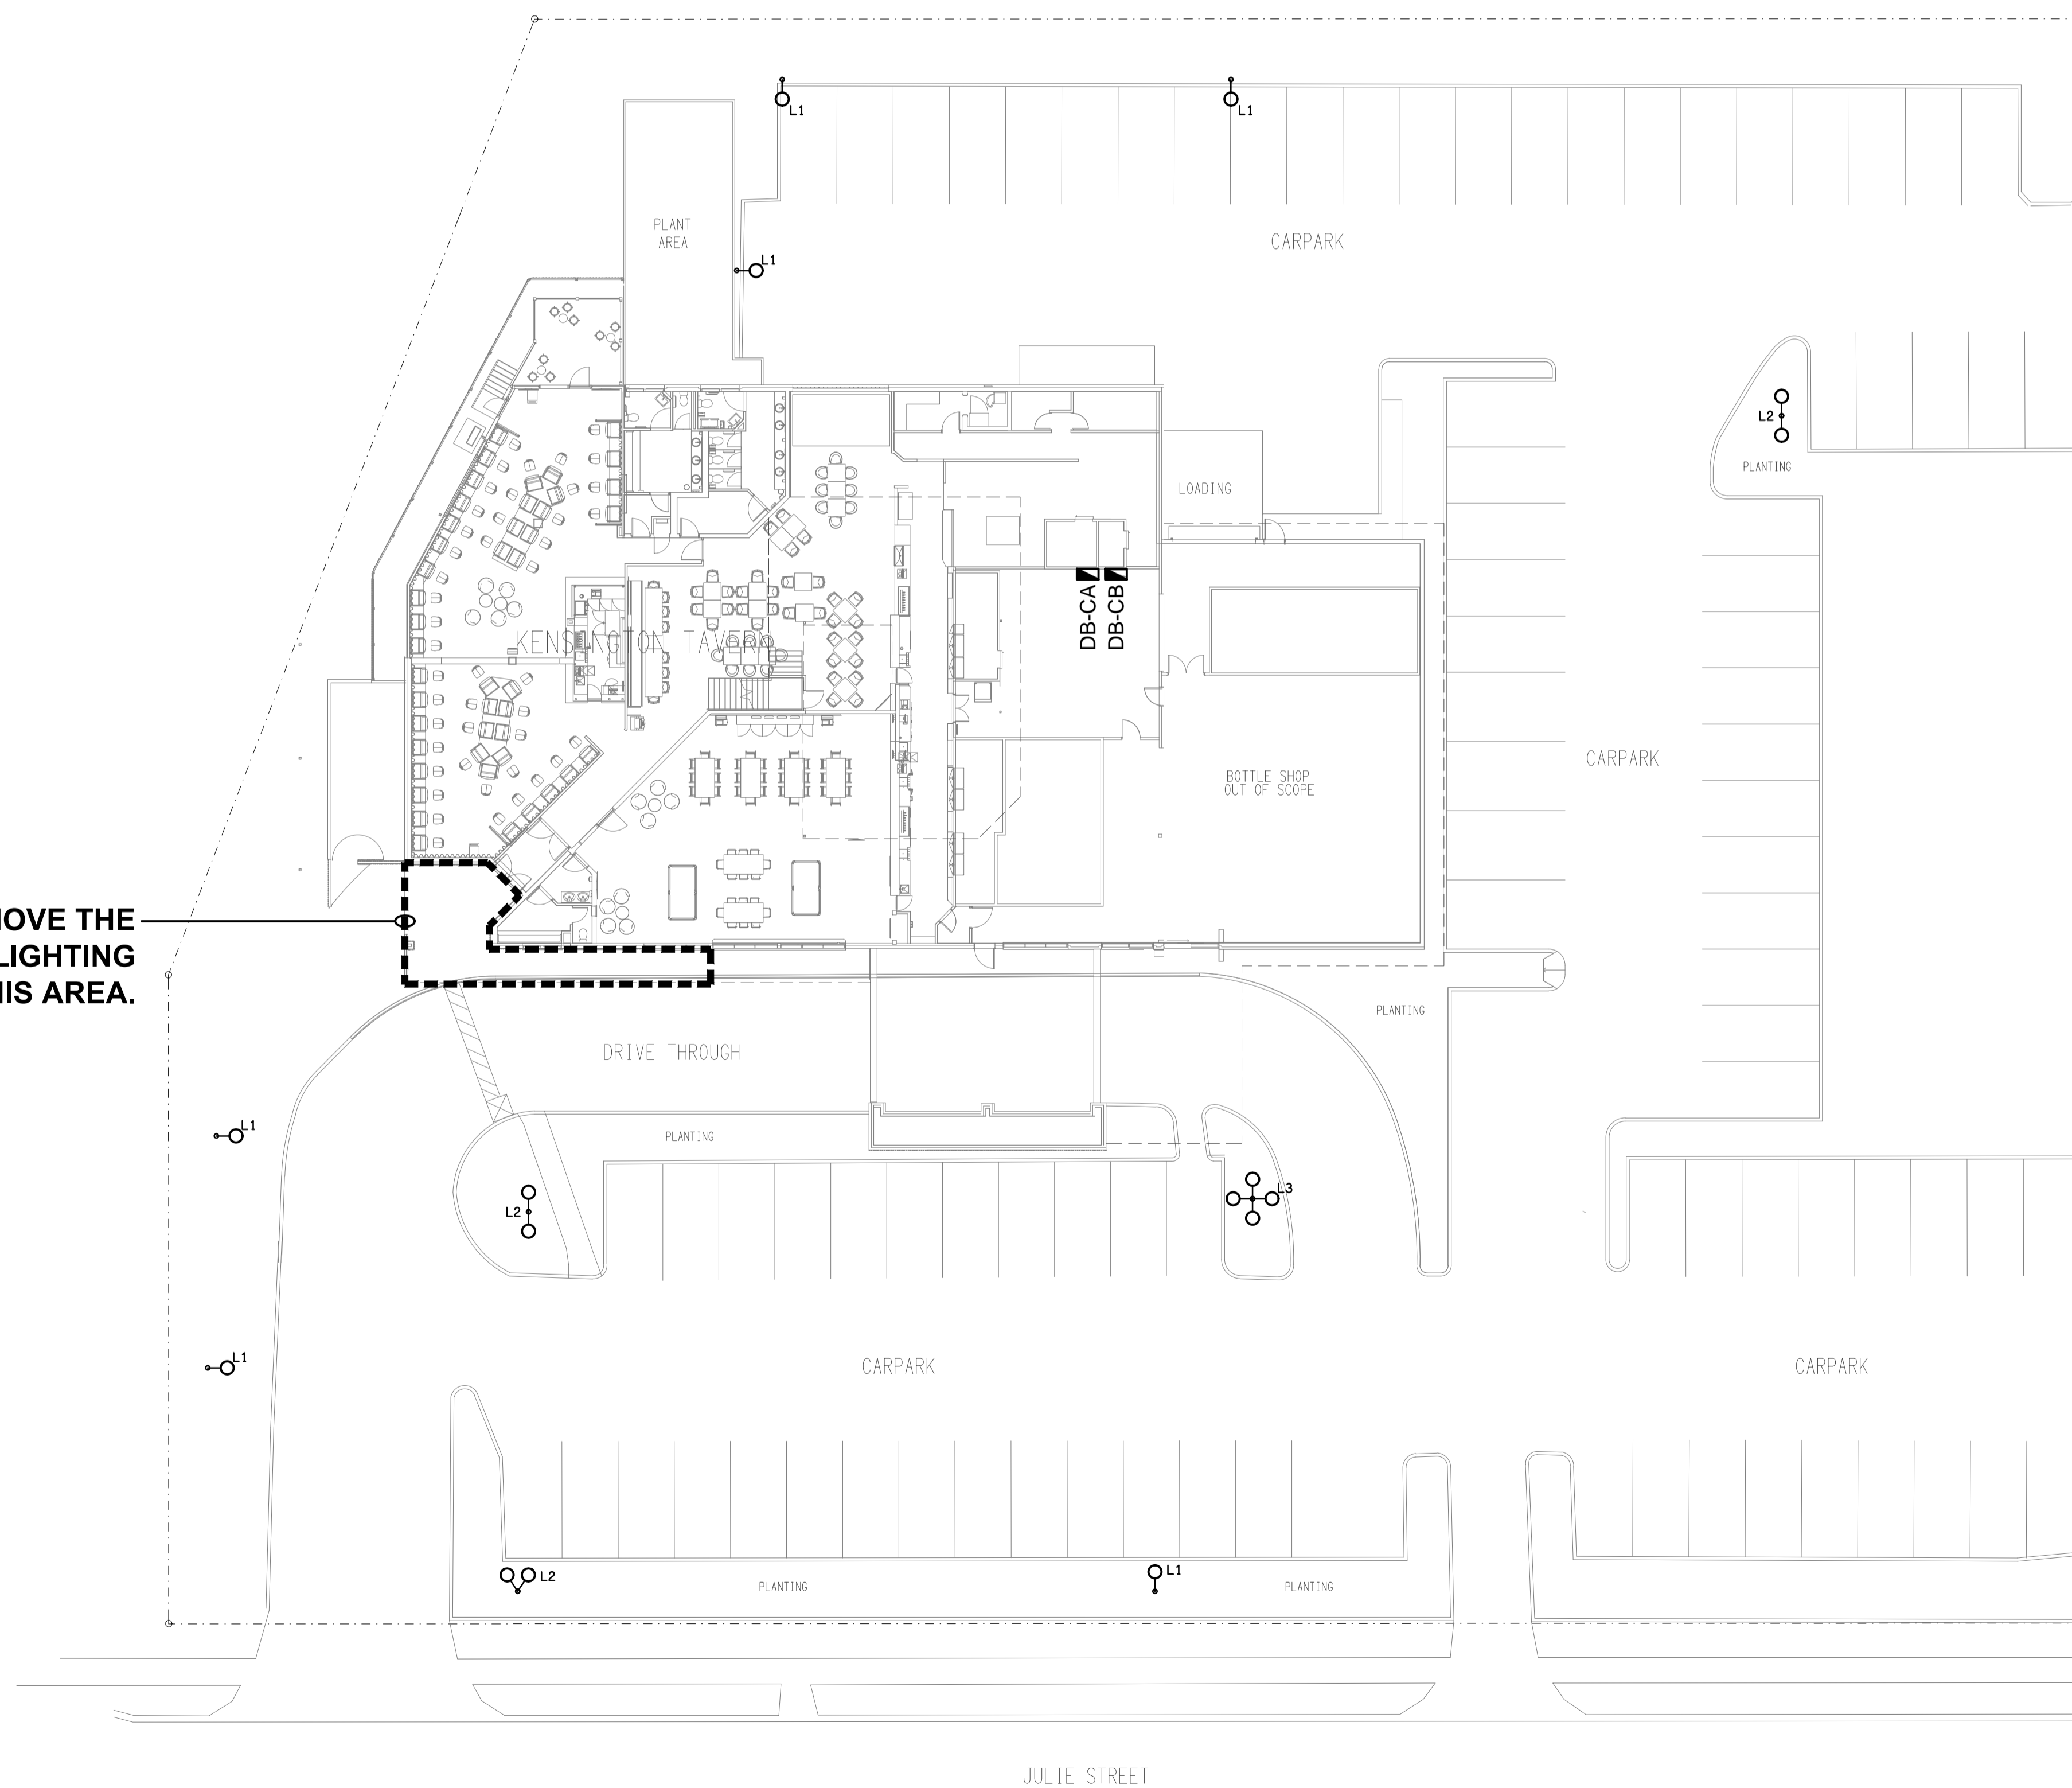

D	CONSTRUCTION	18/03/2026
REV:	DESCRIPTION:	DATE:

ELECTRICAL DESIGN GROUP
ELECTRICAL BUILDING SERVICES CONSULTANTS

BRISBANE: P.O. Box 15 Sherwood Qld 4075
Phone: (07) 3278 4375
Email: brisbane@edg.net.au
Web: www.edg.net.au

ELECTRICAL DESIGN GROUP BRISBANE / TRADING AS: ELECTRICAL DESIGN GROUP
PTY LTD / ACN 092 710 793

PROJECT:
KENSINGTON TAVERN

SITE ADDRESS:
**25 JULIE STREET, CRESTMEAD
QUEENSLAND**

SCALE: 1:200 SHEET SIZE: AT A1

DRAWING TITLE:
**ELECTRICAL SERVICES
SITE PLAN & SCHEMATIC**

PROJECT NO. DRAWING NO. REVISION:
C3638a E03 D