



FLOOR PLAN
LEVEL 1
SCALE 1:50

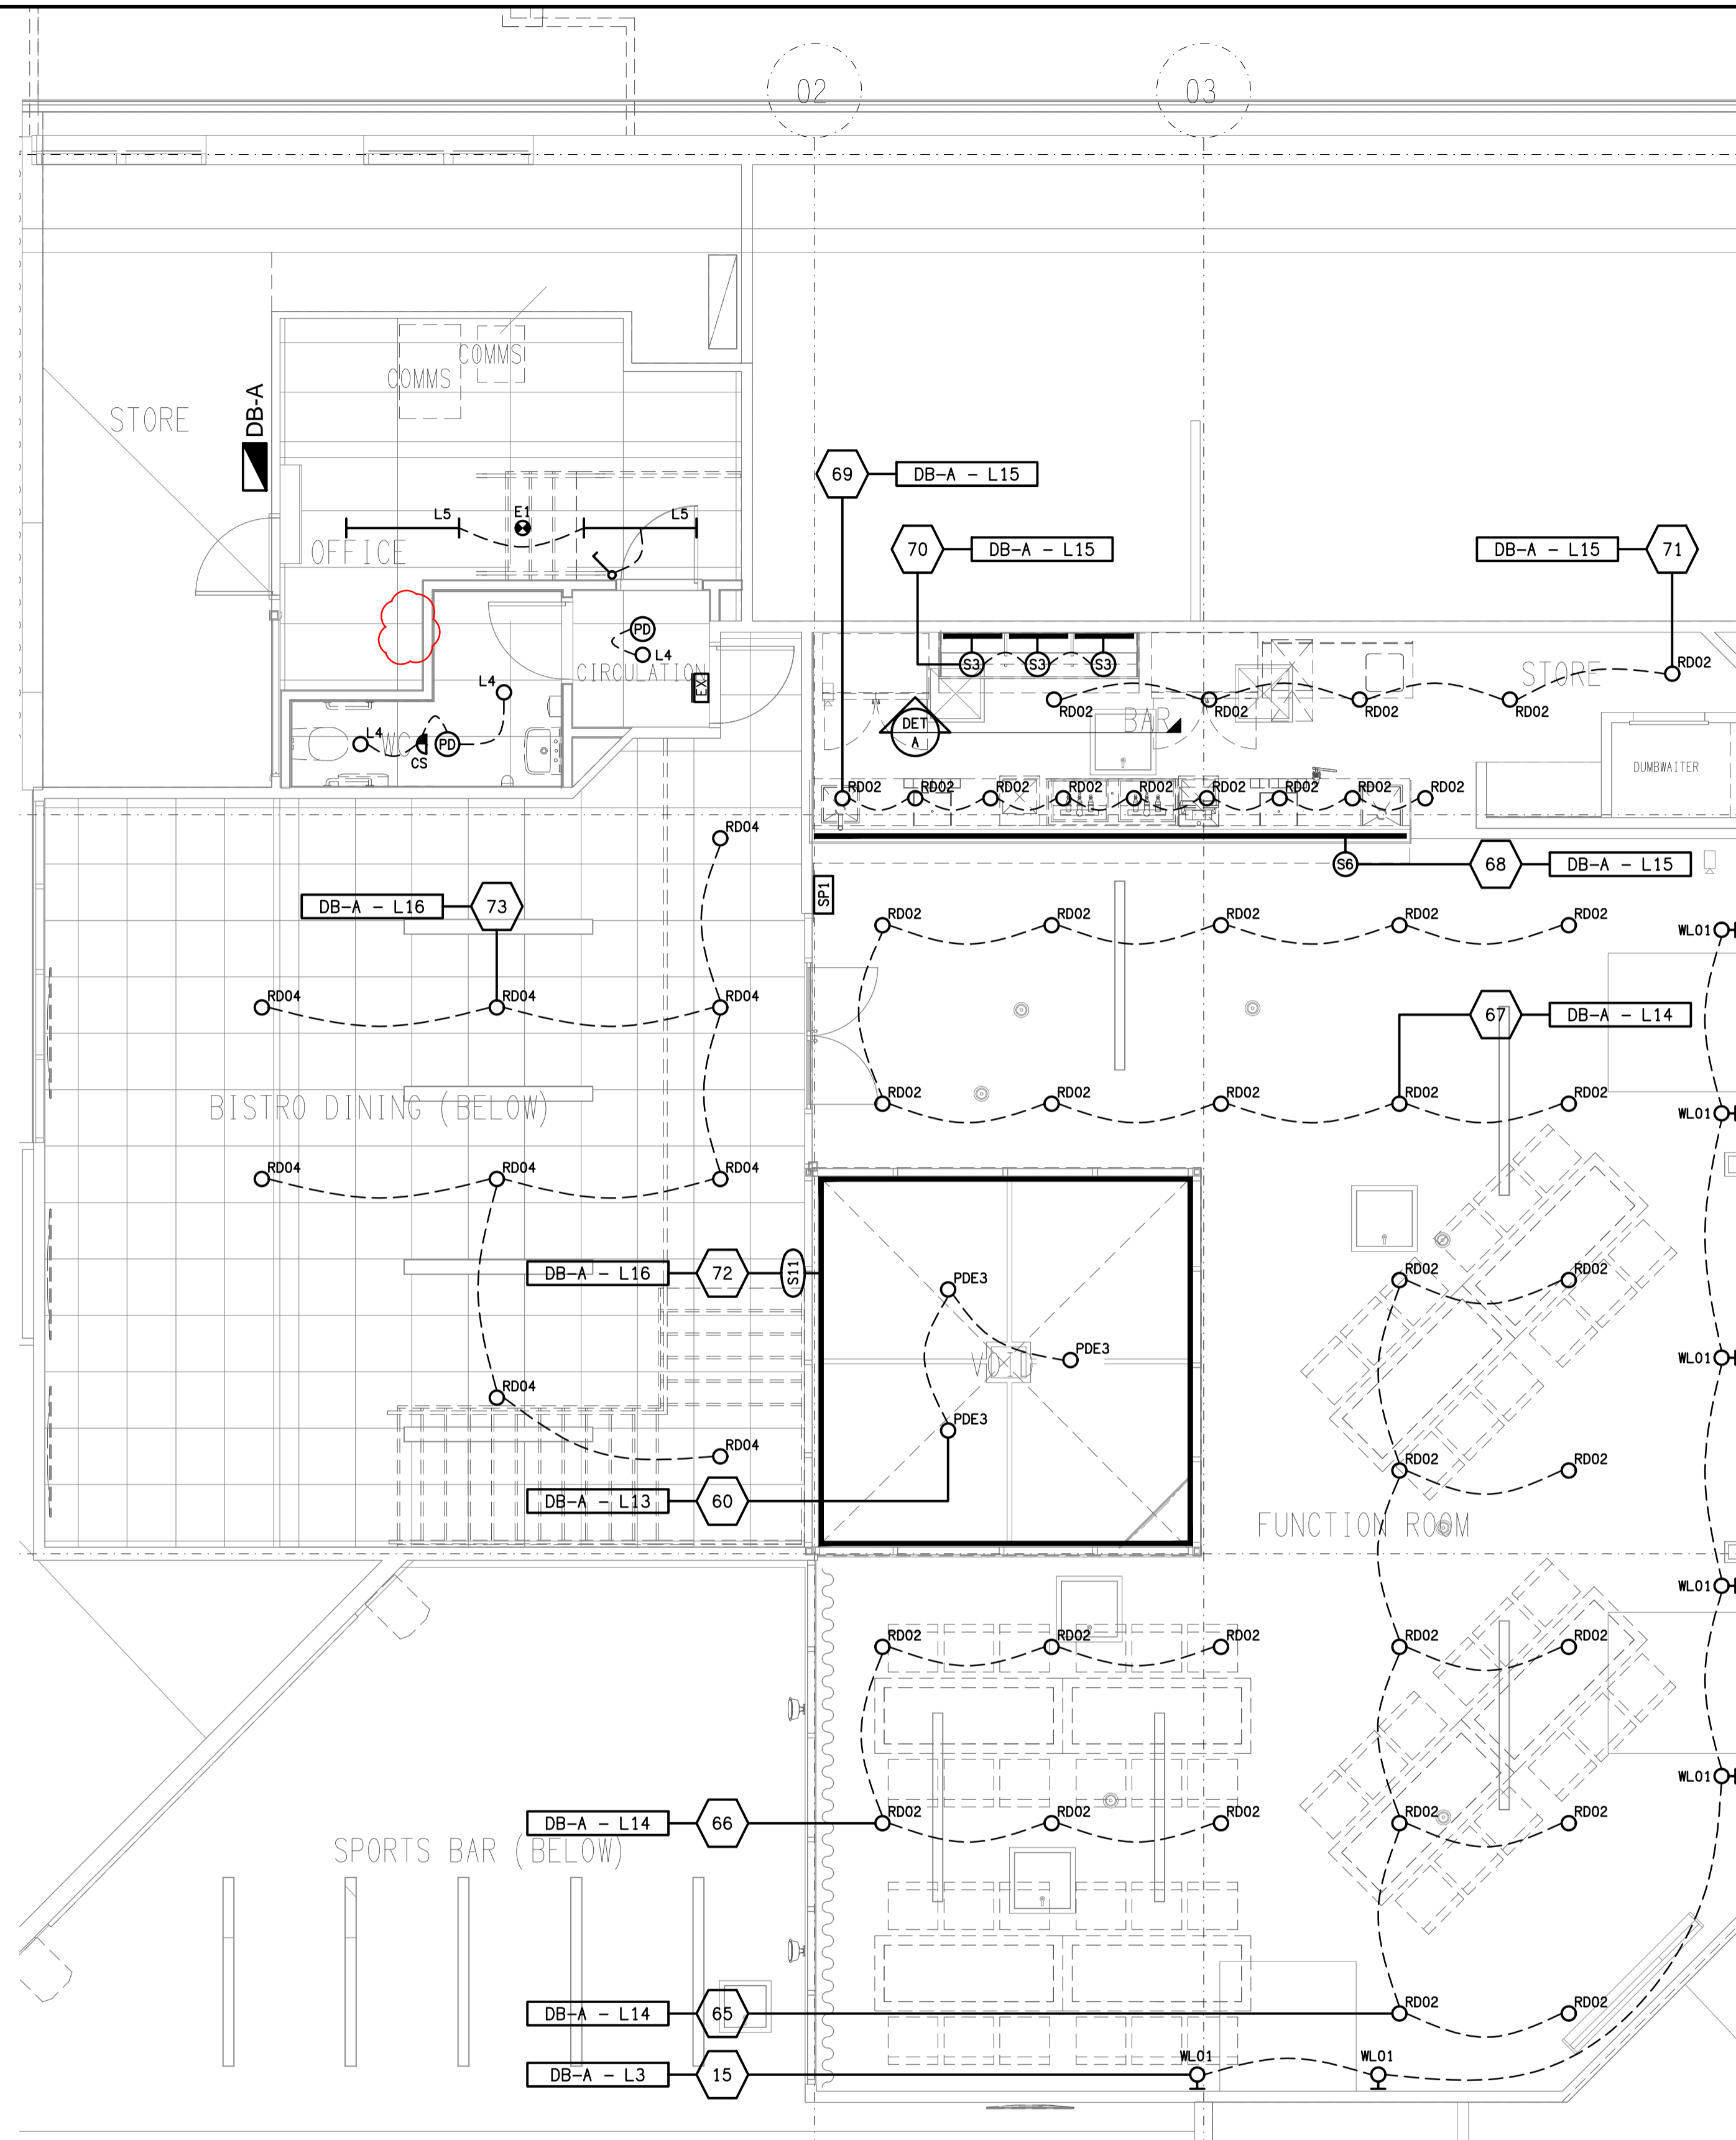

REFLECTED CEILING PLAN
LEVEL 1
SCALE 1:50

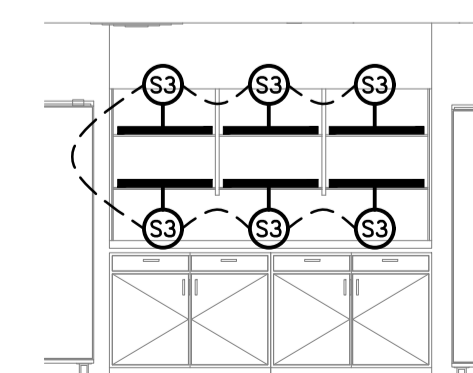

DETAIL A
LEVEL 1 BAR ELEVATION
SCALE 1:50

E	CONSTRUCTION	18/03/2026
REV:	DESCRIPTION:	DATE:

ELECTRICAL DESIGN GROUP
ELECTRICAL BUILDING SERVICES CONSULTANTS

BRISBANE: P.O. Box 15 Sherwood Qld 4075
Phone: (07) 3278 4375
Email: brisbane@edg.net.au
Web: www.edg.net.au

ELECTRICAL DESIGN GROUP BRISBANE / TRADING AS:
PTY LTD ACN 092 710 793 / ELECTRICAL DESIGN GROUP

PROJECT:
KENSINGTON TAVERN

SITE ADDRESS:
25 JULIE STREET, CRESTMEAD
QUEENSLAND

SCALE: 1:50 SHEET SIZE: AT A1

DRAWING TITLE:
ELECTRICAL SERVICES
LEVEL 1
FLOOR PLAN &
REFLECTED CEILING PLAN

PROJECT NO. DRAWING NO. REVISION:
C3638a E08 E