


DETAIL A
TAB WALL ELEVATION
SCALE 1:25

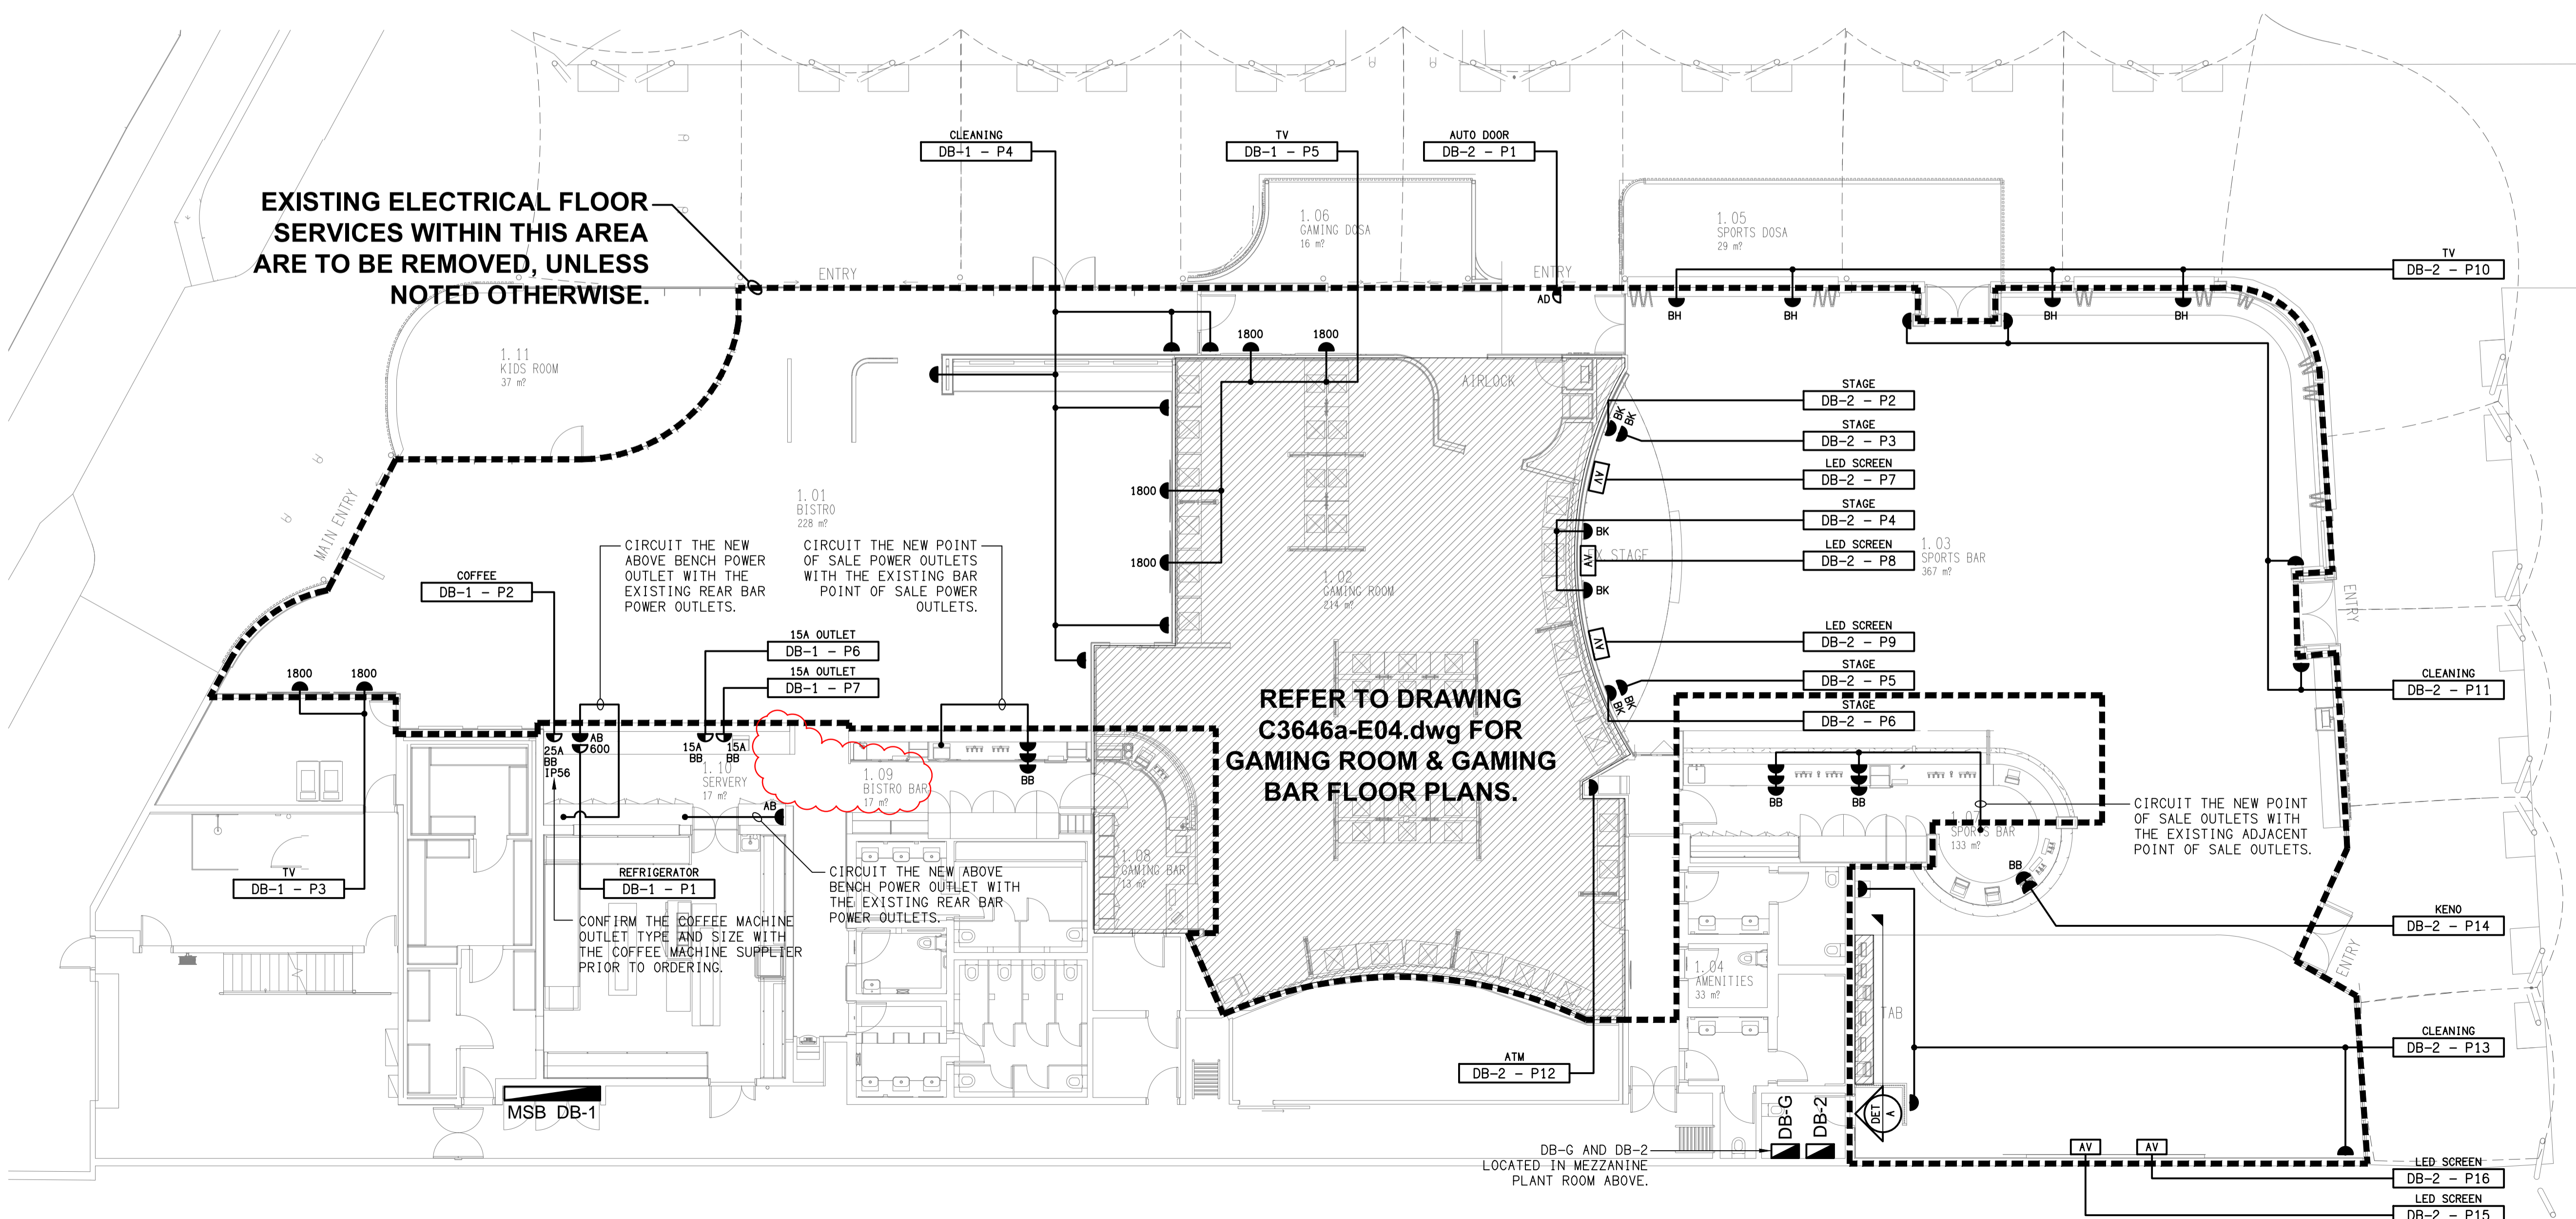

E	CONSTRUCTION	29/05/2026
REV:	DESCRIPTION:	DATE:

ELECTRICAL DESIGN GROUP
ELECTRICAL BUILDING SERVICES CONSULTANTS

BRISBANE: P.O. Box 15 Sherwood Qld 4075
Phone: (07) 3278 4375
Email: brisbane@edg.net.au
Web: www.edg.net.au

ELECTRICAL DESIGN GROUP BRISBANE PTY LTD
ACN 092 710 793

TRADING AS:
ELECTRICAL DESIGN GROUP

PROJECT:
CLUB TAVERN CABOOLTURE

SITE ADDRESS:
16 MATTHEW TERRACE, CABOOLTURE

SCALE: 1:100 SHEET SIZE: AT A1

DRAWING TITLE:
ELECTRICAL SERVICES FLOOR PLAN

PROJECT NO. DRAWING NO. REVISION:
C3646a E03 E