


**NOTE:**  
REFER TO DRAWING C3646a-E06.dwg FOR THE ADDITIONAL JOINERY AND WALL LIGHTING PLAN.

**THE EXISTING ELECTRICAL CEILING SERVICES WITHIN THIS AREA ARE TO REMAIN AS IS, UNLESS NOTED OTHERWISE.**

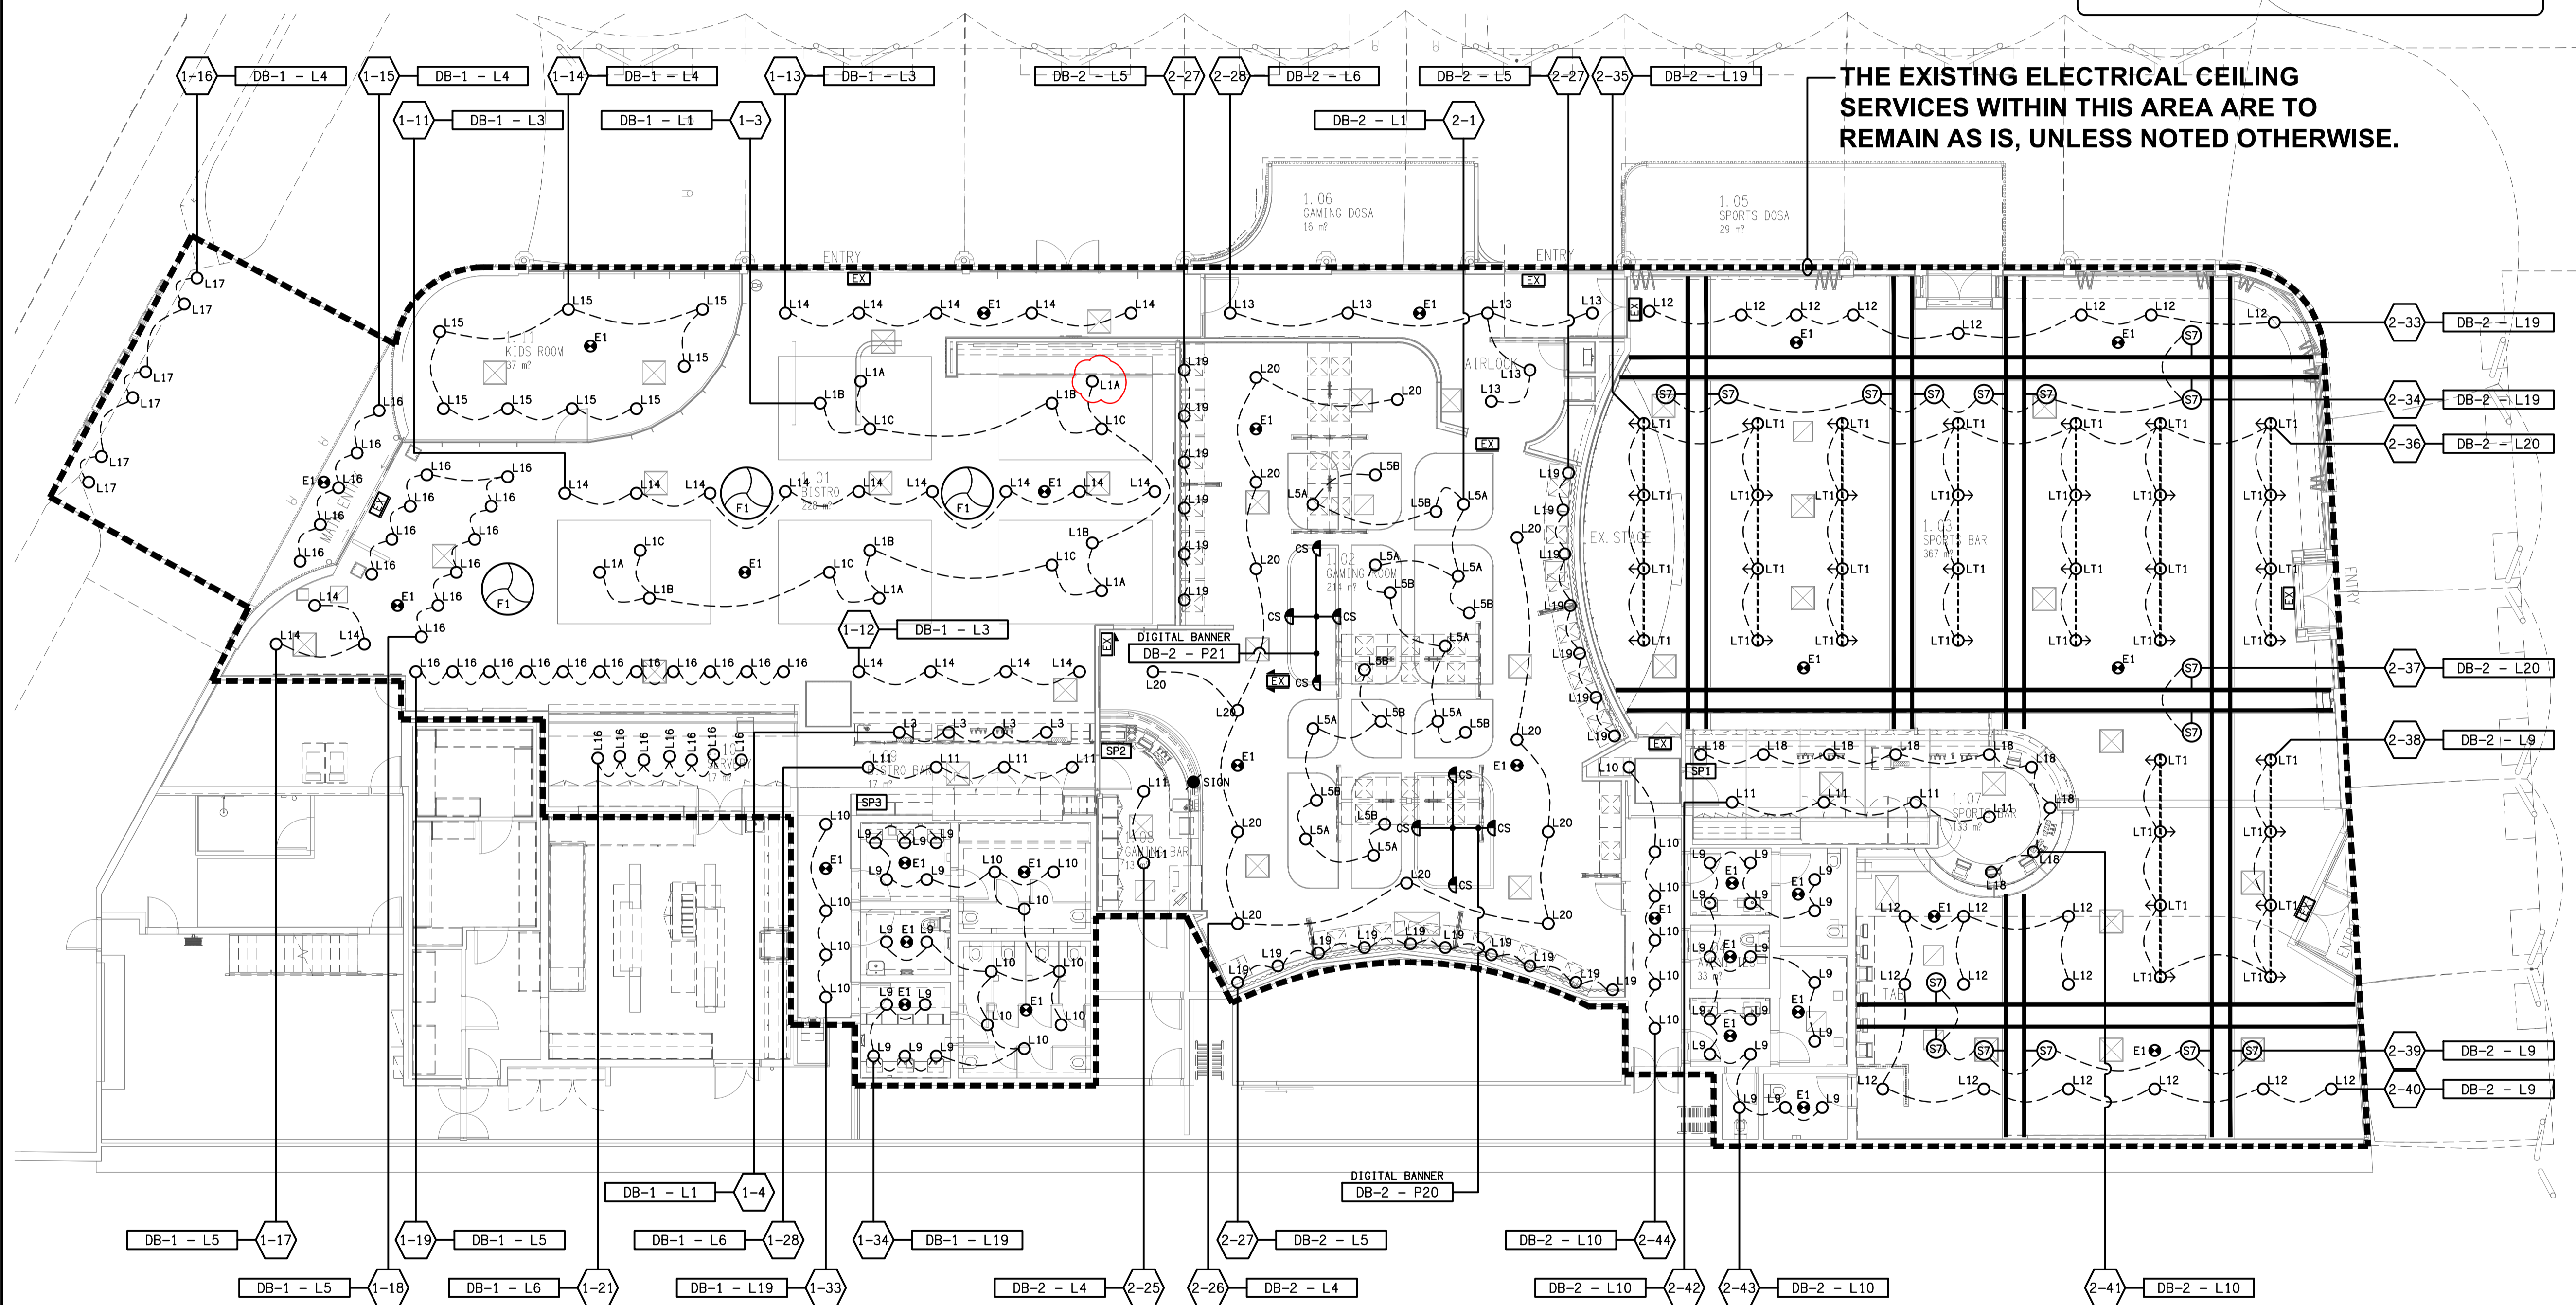

C	CONSTRUCTION	23/03/2026
REV:	DESCRIPTION:	DATE:

**ELECTRICAL DESIGN GROUP**  
ELECTRICAL BUILDING SERVICES CONSULTANTS

BRISBANE: P.O. Box 15 Sherwood Qld 4075  
Phone: (07) 3278 4375  
Email: brisbane@edg.net.au  
Web: www.edg.net.au

ELECTRICAL DESIGN GROUP BRISBANE PTY LTD  
ACN 092 710 793

TRADING AS:  
ELECTRICAL DESIGN GROUP

PROJECT:

**CLUB TAVERN  
CABOOLTURE**

SITE ADDRESS:  
16 MATTHEW TERRACE, CABOOLTURE

SCALE: SHEET SIZE:

1:100 AT A1

DRAWING TITLE:

**ELECTRICAL SERVICES  
REFLECTED CEILING PLAN**

PROJECT NO. DRAWING NO. REVISION:

**C3646a E05 C**