



REFER TO DRAWING C3648a-E04 FOR THE GAMING ROOM FLOOR PLAN & C3648a-E05 FOR THE GAMING ROOM JOINERY LIGHTING PLAN.

EXISTING FLOOR ELECTRICAL SERVICES WITHIN THIS AREA ARE TO BE REMOVED, UNLESS NOTED OTHERWISE.

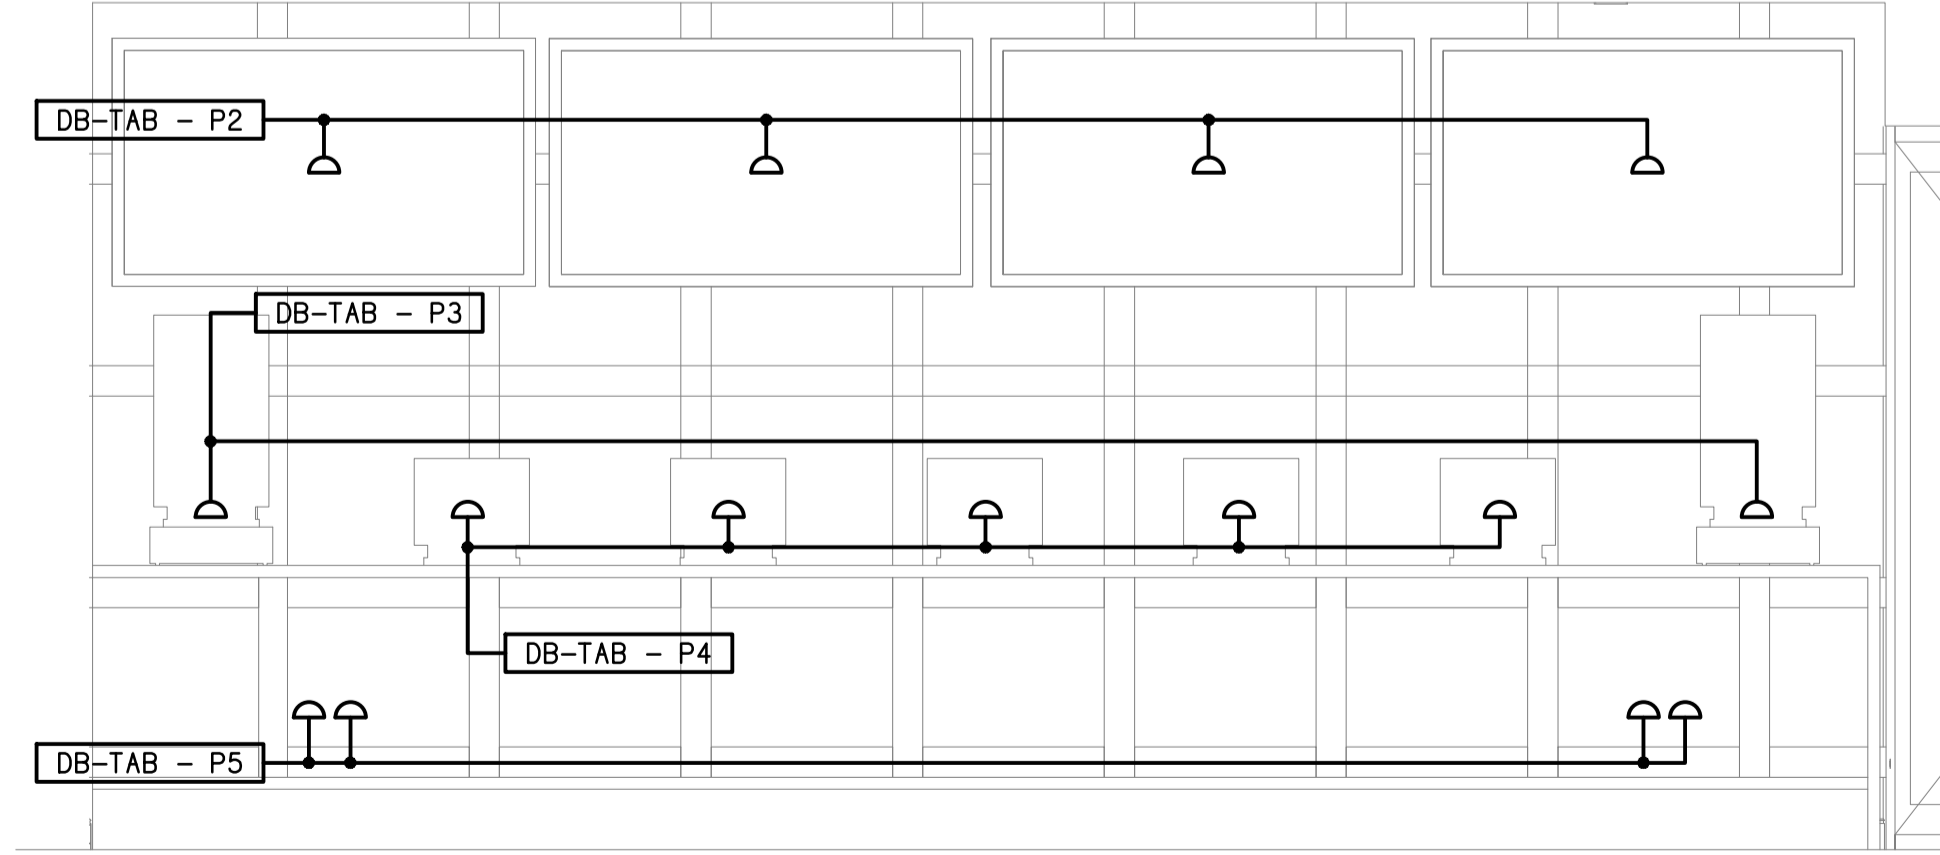

**DETAIL A**  
TAB WALL ELEVATION  
SCALE 1:25

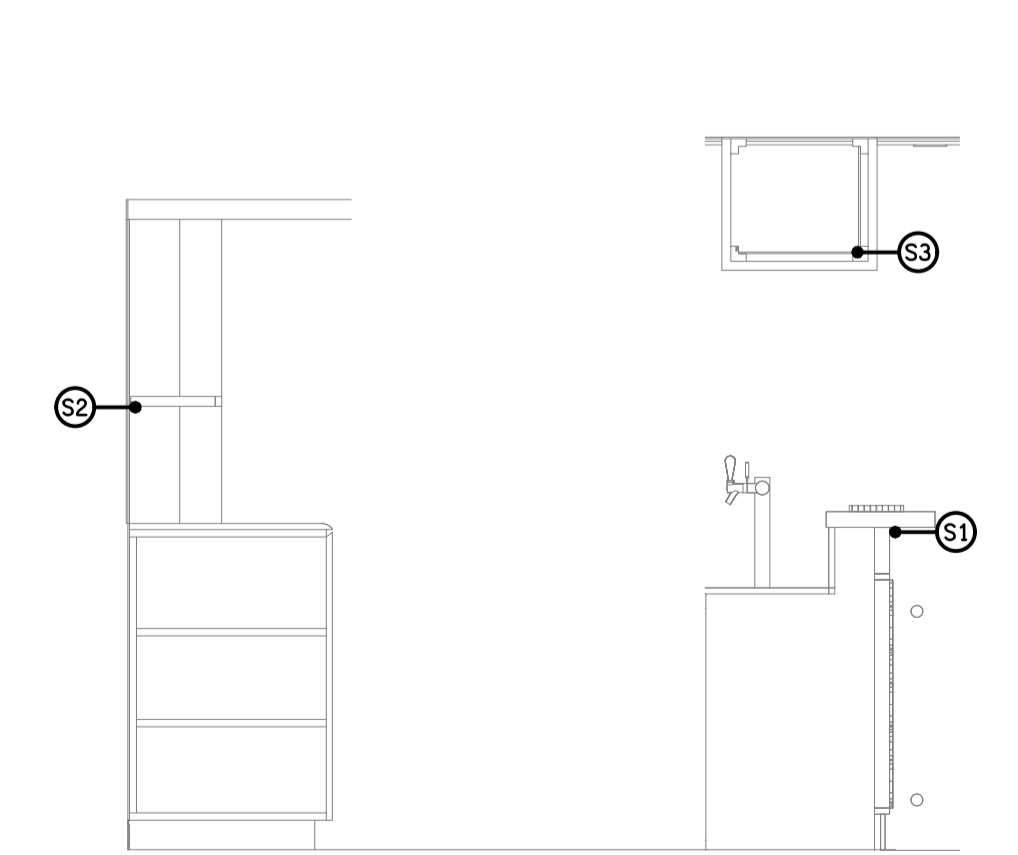

**DETAIL B**  
BISTRO BAR SECTION  
SCALE 1:25

ELECTRICAL DESIGN GROUP BRISBANE PTY LTD  
ACN 092 710 793  
TRADING AS:  
ELECTRICAL DESIGN GROUP

THE COPYRIGHT OF THIS DRAWING REMAINS THE PROPERTY OF THE ELECTRICAL DESIGN GROUP.  
USE FIGURED DIMENSIONS IN PREFERENCE TO SCALE.  
ALL DIMENSIONS TO BE VERIFIED ONSITE.

**ELECTRICAL DESIGN GROUP**  
ELECTRICAL BUILDING SERVICES CONSULTANTS  
BRISBANE GOLD COAST  
P.O. Box 15, Sherwood Q.4075  
Phone: (07) 3278 4375  
Email: brisbane@edg.net.au  
Web: www.edg.net.au

PROJECT:  
**KALLANGUR TAVERN**  
1517 ANZAC AVENUE, KALLANGUR

C	CONSTRUCTION	12/05/2026
REV:	DESCRIPTION:	DATE:
DRAWING: <b>ELECTRICAL SERVICES FLOOR PLAN</b>		
SCALE: 1:100 & 1:25	AT A1	PROJECT NO: <b>C3648a</b>
		DRAWING NO: <b>E03</b>
		REVISION: <b>C</b>