
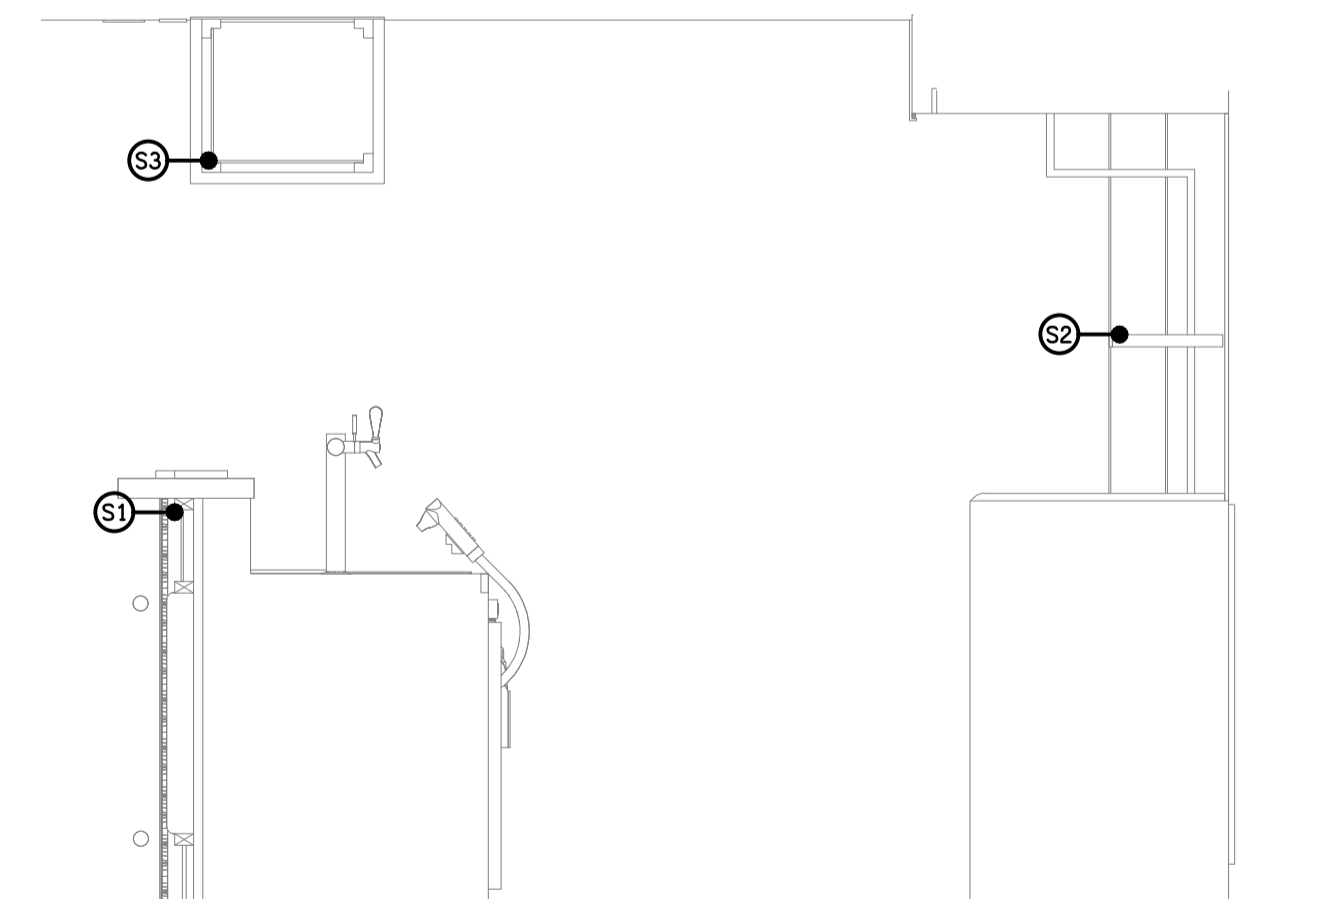


NOTE:
EACH L8 CONTAINS THE NUMBER OF LED PIN LIGHTS AS NOTED AT THE BASE OF THE FEATURE SCREEN.

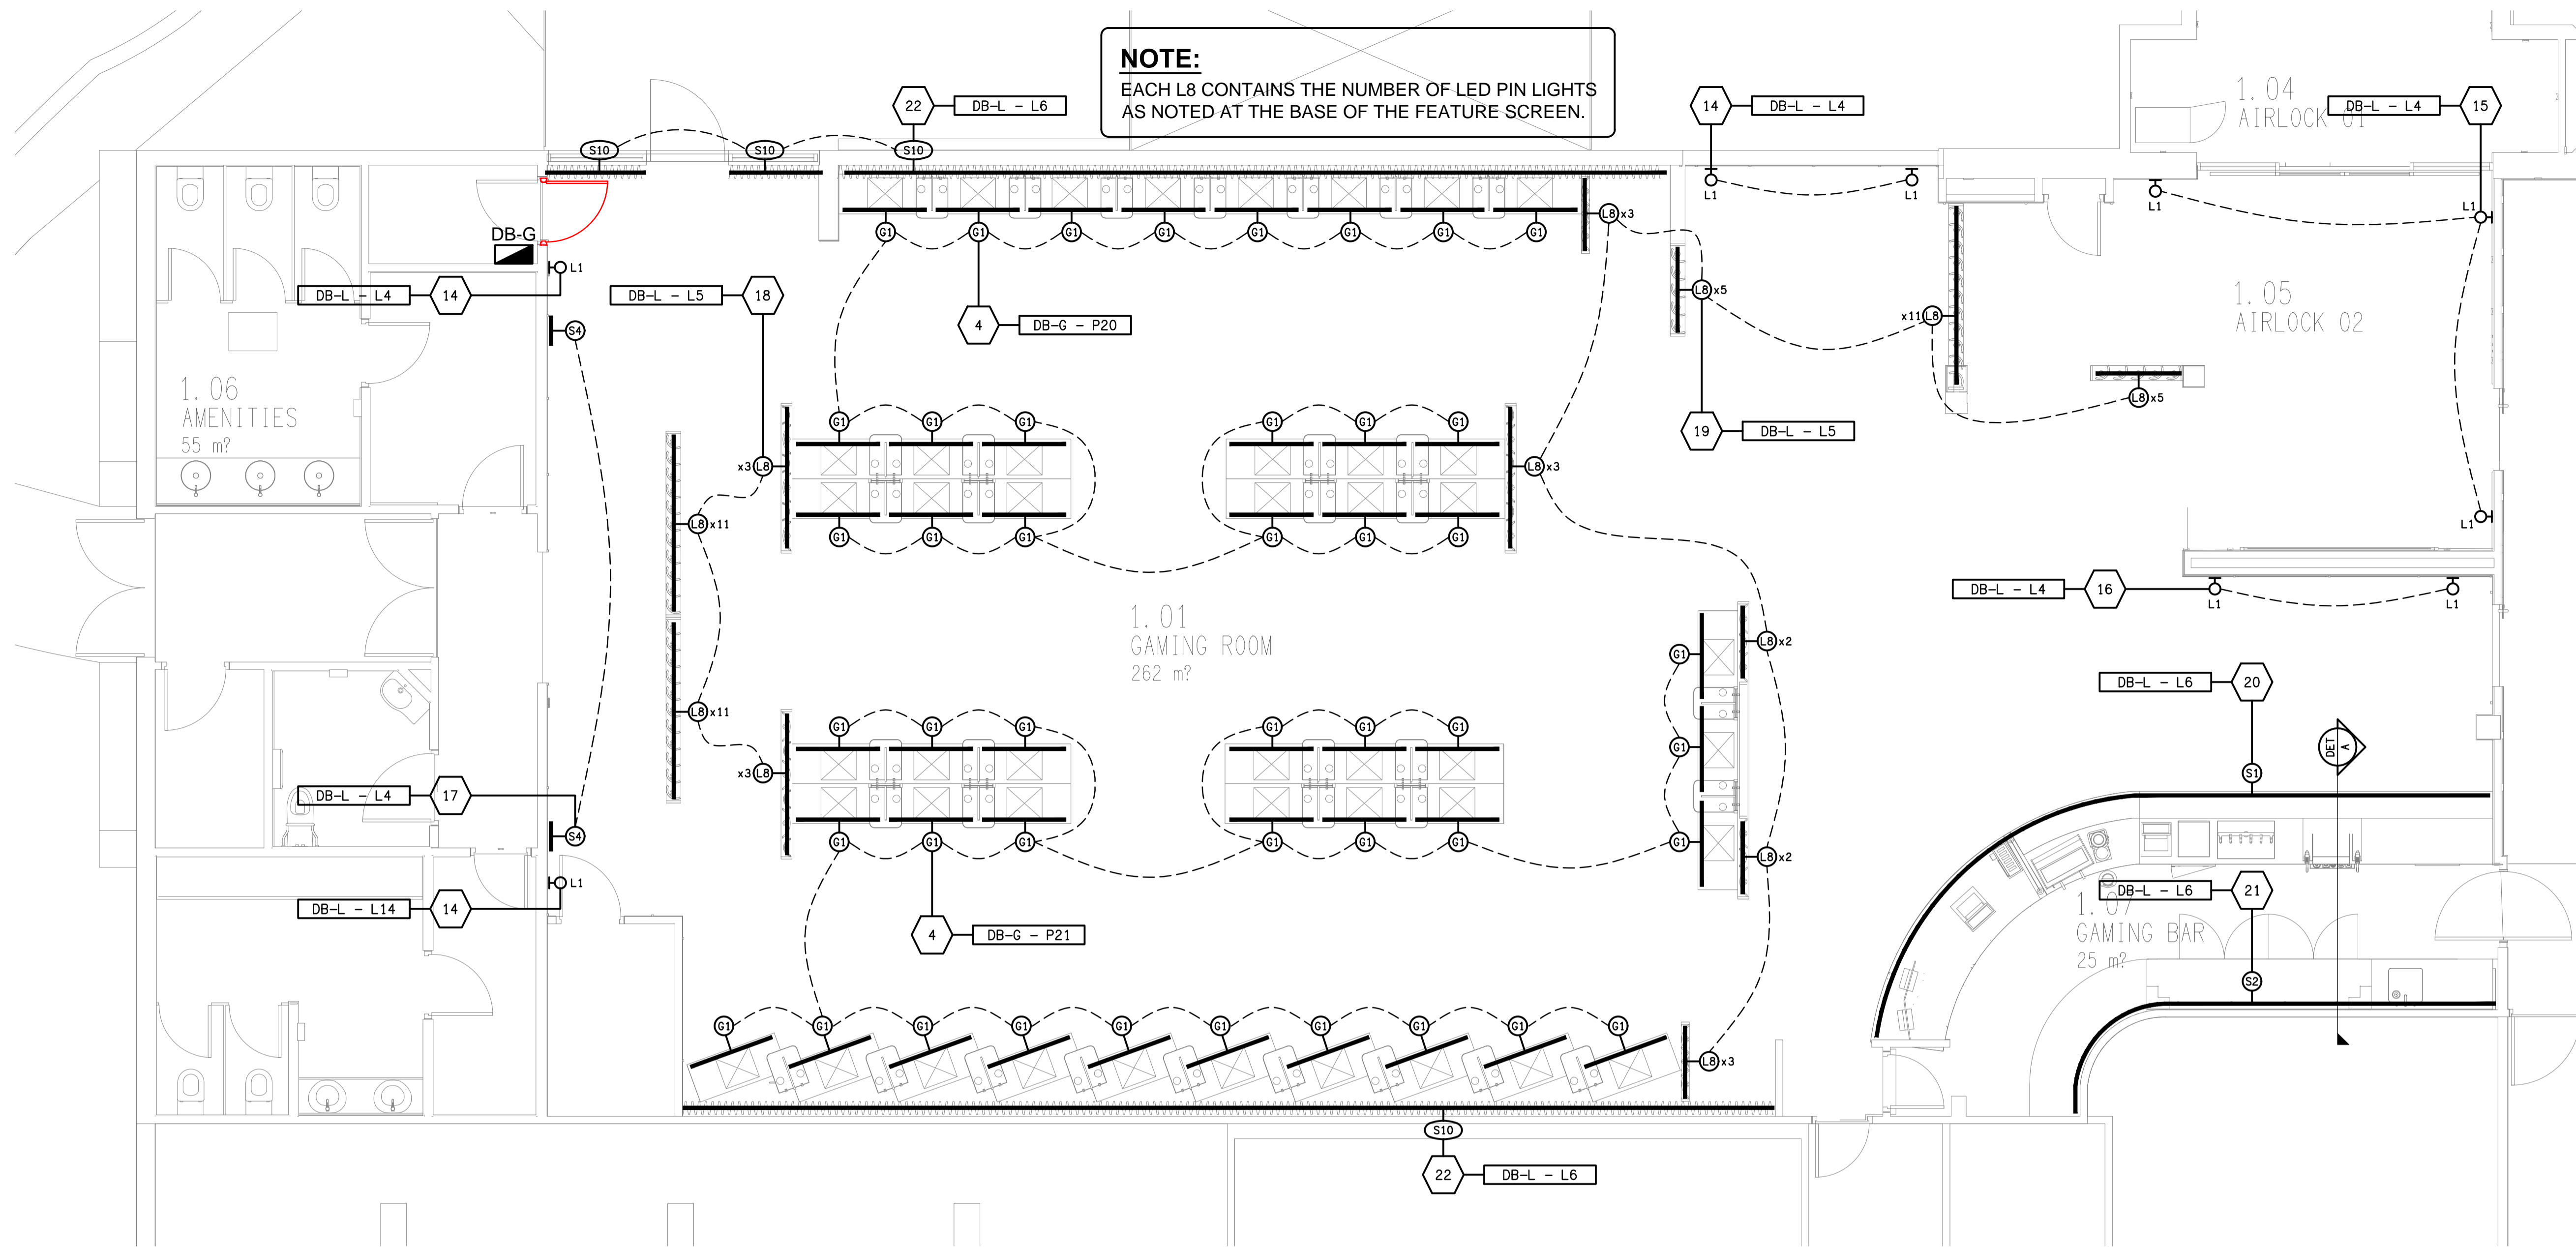

DETAIL A
GAMING BAR SECTION
SCALE 1:20

ELECTRICAL DESIGN GROUP BRISBANE
PTY LTD
ACN 092 710 793
TRADING AS:
ELECTRICAL DESIGN GROUP

THE COPYRIGHT OF THIS DRAWING
REMAINS THE PROPERTY OF THE
ELECTRICAL DESIGN GROUP.
USE FIGURED DIMENSIONS
IN PREFERENCE TO SCALE.
ALL DIMENSIONS TO BE
VERIFIED ONSITE.

ELECTRICAL DESIGN GROUP
ELECTRICAL BUILDING SERVICES CONSULTANTS
BRISBANE GOLD COAST
P.O. Box 15, Sherwood Q.4075
Phone: (07) 3278 4375
Email: brisbane@edg.net.au
Web: www.edg.net.au

PROJECT:
KALLANGUR TAVERN
1517 ANZAC AVENUE, KALLANGUR

C	CONSTRUCTION	12/05/2026
REV.	DESCRIPTION:	DATE:
DRAWING: ELECTRICAL SERVICES GAMING ROOM & BAR JOINERY LIGHTING PLAN		
SCALE: 1:50 UNO	PROJECT NO: C3648a	DRAWING NO: E05
AT A1	REVISION: C	