


ALL EXISTING CEILING ELECTRICAL SERVICES WITHIN THIS AREA ARE TO BE REMOVED, UNLESS NOTED OTHERWISE.

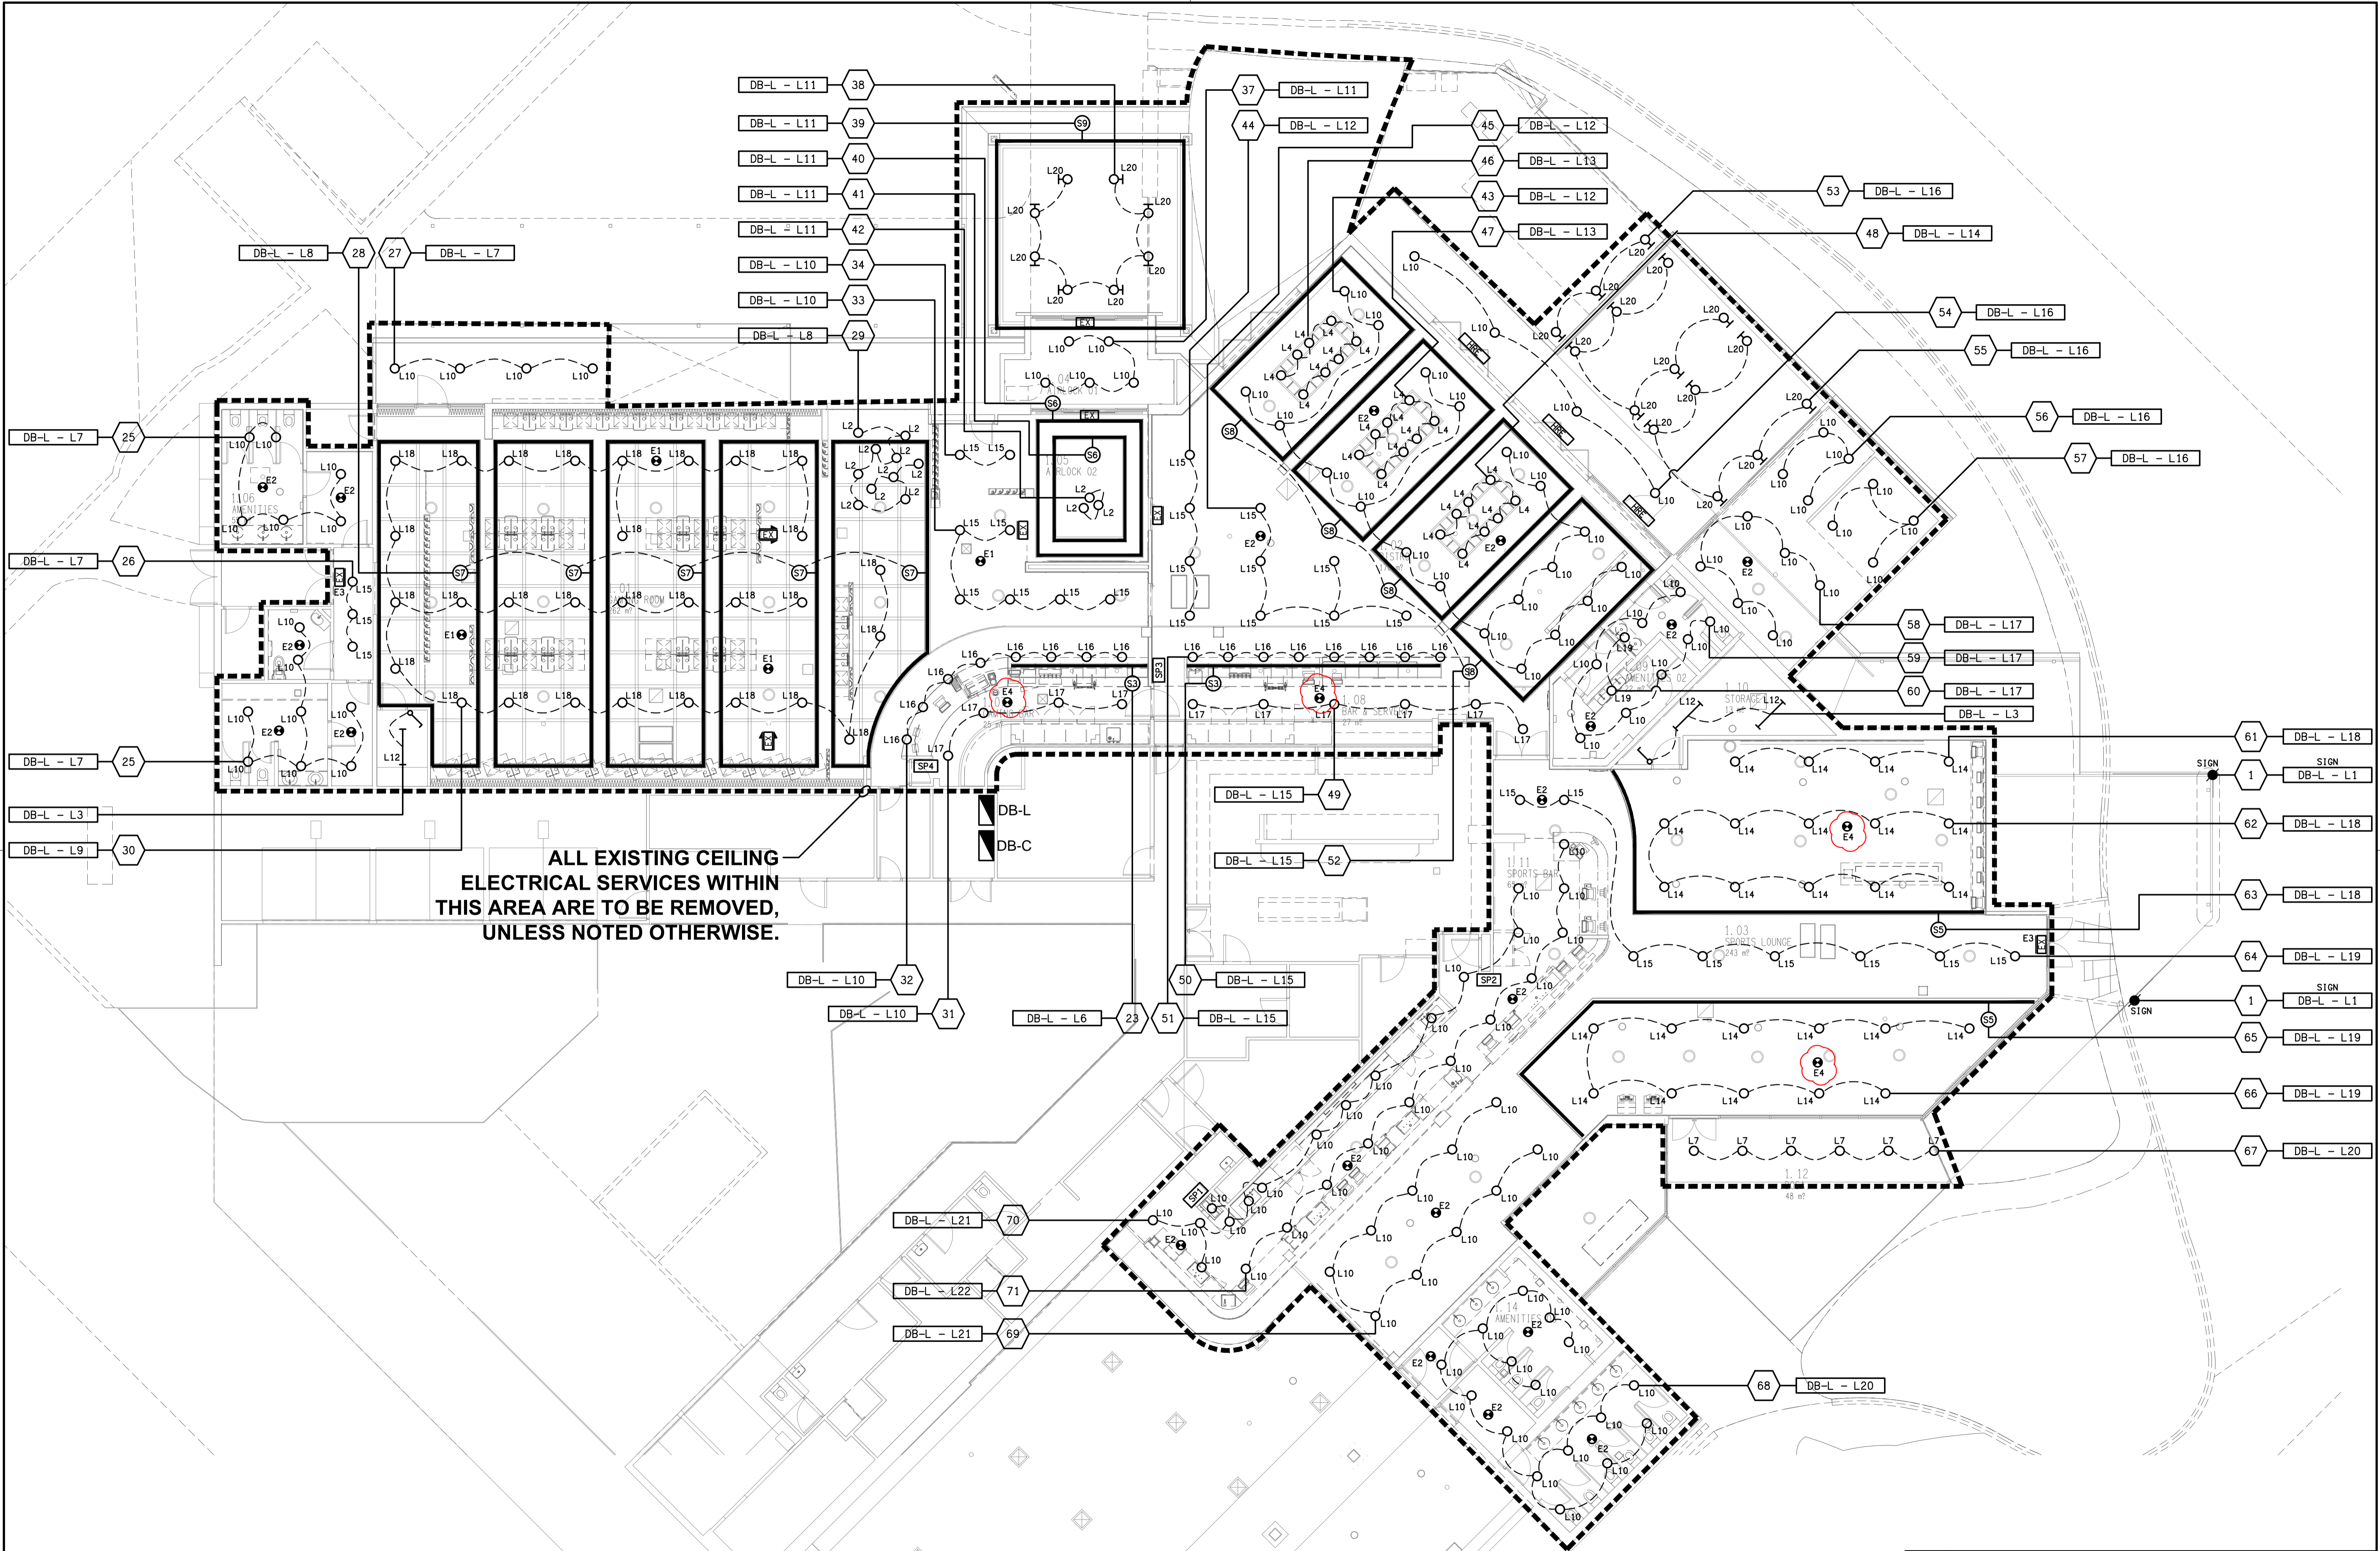

ELECTRICAL DESIGN GROUP BRISBANE PTY LTD
ACN 092 710 793
TRADING AS:
ELECTRICAL DESIGN GROUP

THE COPYRIGHT OF THIS DRAWING REMAINS THE PROPERTY OF THE ELECTRICAL DESIGN GROUP.
USE FIGURED DIMENSIONS IN PREFERENCE TO SCALE.
ALL DIMENSIONS TO BE VERIFIED ONSITE.

ELECTRICAL DESIGN GROUP
ELECTRICAL BUILDING SERVICES CONSULTANTS
BRISBANE GOLD COAST
P.O. Box 15, Sherwood Q.4075
Phone: (07) 3278 4375
Email: brisbane@edg.net.au
Web: www.edg.net.au

PROJECT:
KALLANGUR TAVERN
1517 ANZAC AVENUE, KALLANGUR

C	CONSTRUCTION	12/05/2026
REV:	DESCRIPTION:	DATE:
DRAWING: ELECTRICAL SERVICES REFLECTED CEILING PLAN		
SCALE: 1:100	PROJECT NO: C3648a	DRAWING NO: E06
AT A1	REVISION: C	