


SCHEMATIC
MSB-A CONFIGURATION
NOT TO SCALE

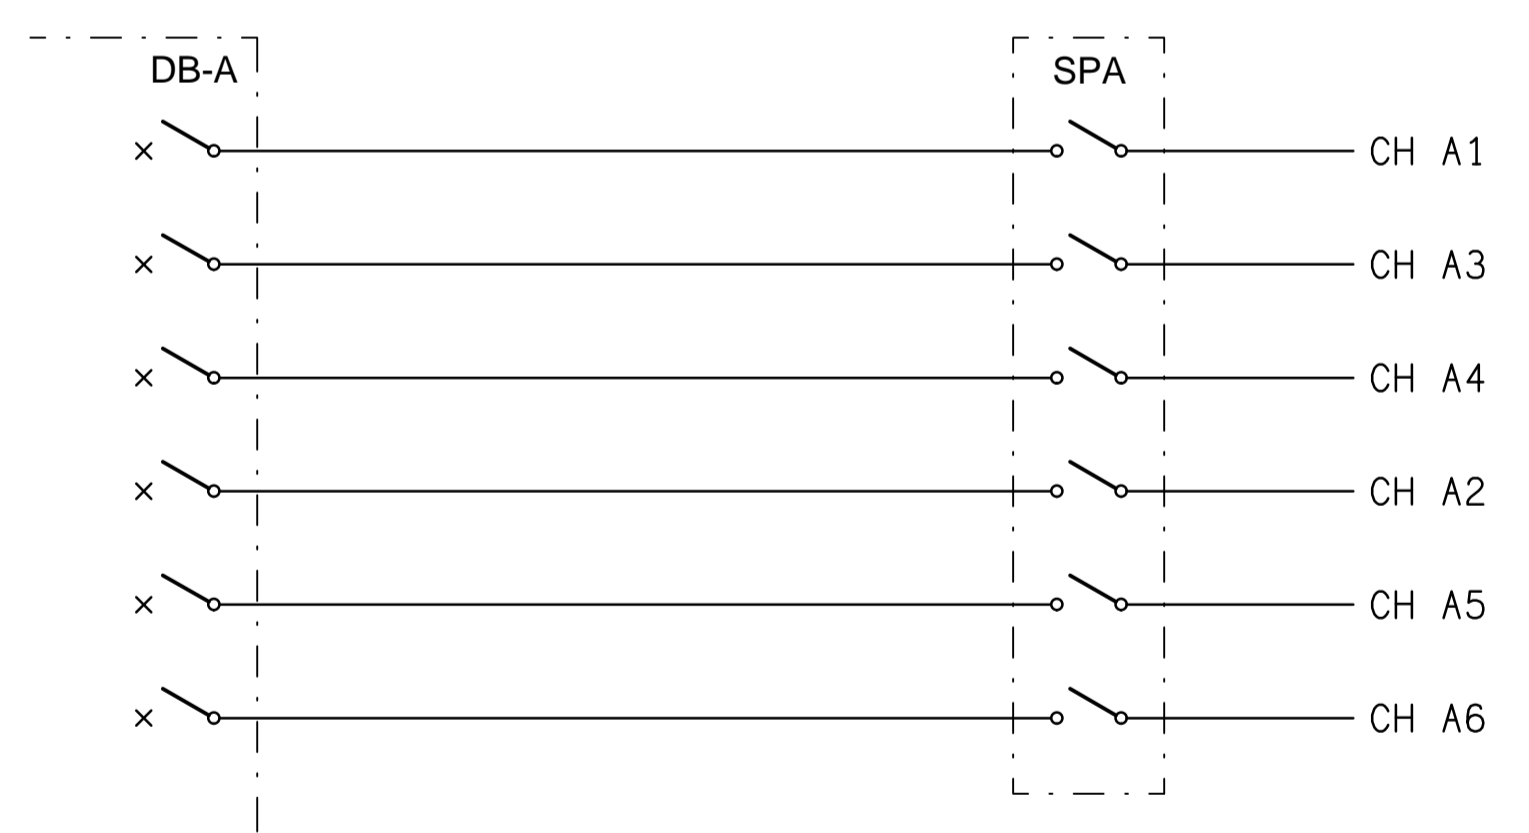

SCHEMATIC
LIGHTING CONTROL
NOT TO SCALE

ELECTRICAL DESIGN GROUP BRISBANE
PTY LTD
ACN 092 710 793

TRADING AS:
ELECTRICAL DESIGN GROUP

THE COPYRIGHT OF THIS DRAWING
REMAINS THE PROPERTY OF THE
ELECTRICAL DESIGN GROUP.

USE FIGURED DIMENSIONS
IN PREFERENCE TO SCALE.

ALL DIMENSIONS TO BE
VERIFIED ONSITE.

ELECTRICAL DESIGN GROUP
ELECTRICAL BUILDING SERVICES CONSULTANTS
BRISBANE GOLD COAST

P.O.Box 15, Sherwood Q.4075
Phone: (07) 3278 4375
Email: brisbane@edg.net.au
Web: www.edg.net.au

PROJECT:
EAGERS BYD CAPALABA

104 REDLAND BAY ROAD, CAPALABA, QUEENSLAND

E	CONSTRUCTION	17/03/2026
REV:	DESCRIPTION:	DATE:
DRAWING: ELECTRICAL SERVICES POWER & LIGHTING CONTROL SCHEMATICS		
SCALE: NOT TO SCALE AT A1	PROJECT NO: C3665a	DRAWING NO: E03
	REVISION: E	