


**NOTE:**  
REFER TO DRAWING C3666a-E06.dwg FOR  
THE TYPICAL OFFICE DESK ELEVATION.

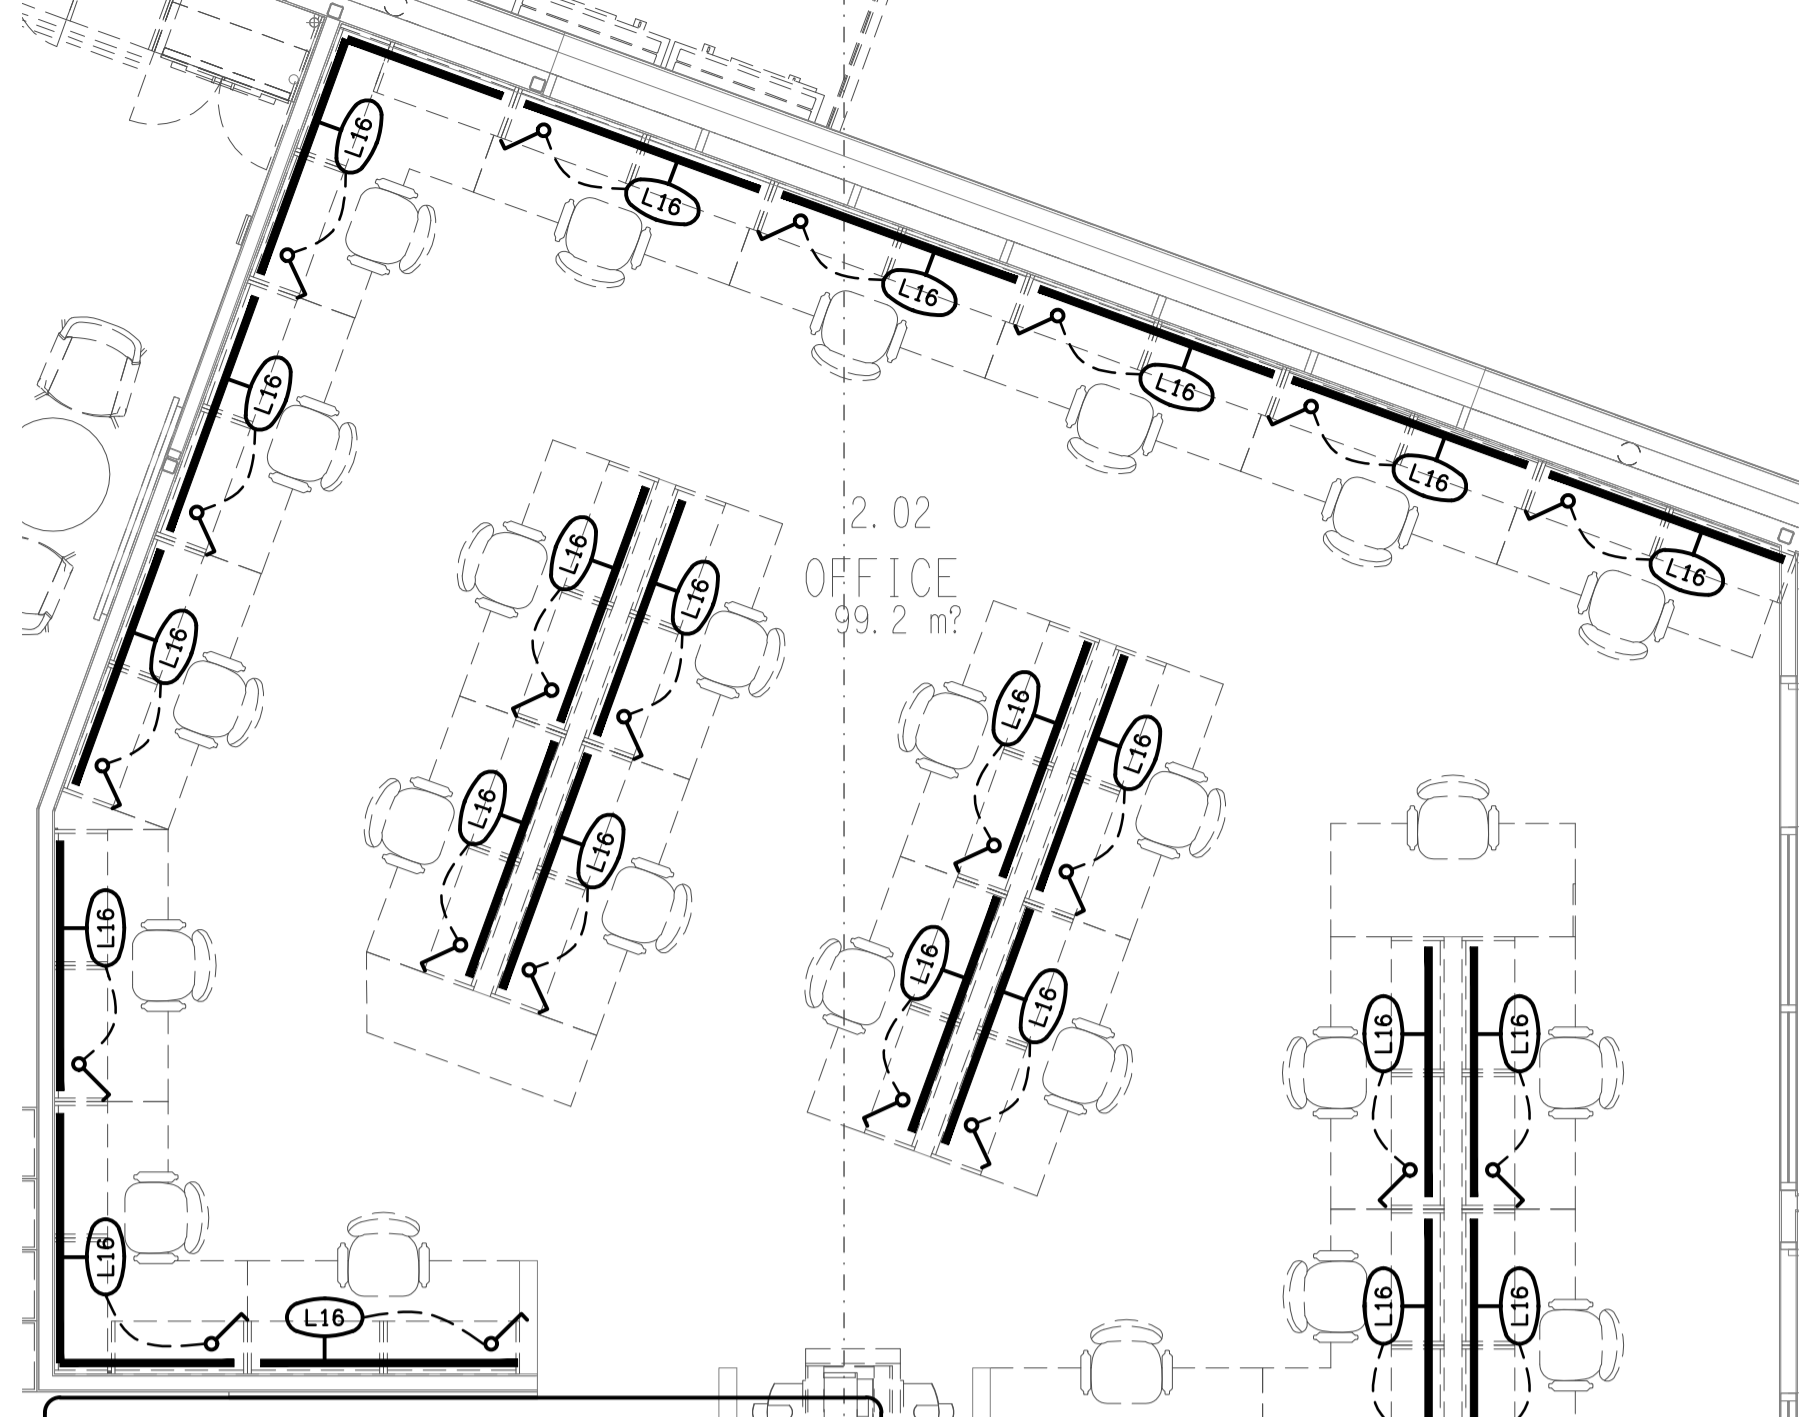

**DETAIL**  
L16 OFFICE DESK LIGHTING  
SCALE 1:50

ELECTRICAL DESIGN GROUP BRISBANE  
PTY LTD  
ACN 092 710 793  
TRADING AS:  
ELECTRICAL DESIGN GROUP

THE COPYRIGHT OF THIS DRAWING  
REMAINS THE PROPERTY OF THE  
ELECTRICAL DESIGN GROUP.  
USE FIGURED DIMENSIONS  
IN PREFERENCE TO SCALE.  
ALL DIMENSIONS TO BE  
VERIFIED ONSITE.

**ELECTRICAL DESIGN GROUP**  
ELECTRICAL BUILDING SERVICES CONSULTANTS  
BRISBANE GOLD COAST  
P.O. Box 15, Sherwood Q. 4075  
Phone: (07) 3278 4375  
Email: brisbane@edg.net.au  
Web: www.edg.net.au

PROJECT:  
**ORMISTON COLLEGE  
BUSINESS & ARTS PRECINCT**  
97 DUNDAS STREET WEST, ORMISTON

B	TENDER	21/04/2026
REV:	DESCRIPTION:	DATE:
DRAWING: <b>ELECTRICAL SERVICES LEVEL 1 REFLECTED CEILING PLAN</b>		
SCALE: 1:100 UNO	PROJECT NO: <b>C3666a</b>	DRAWING NO: <b>E07</b>
AT A1	REVISION: <b>B</b>	