


FLOOR PLAN
MEZZANINE LEVEL
SCALE 1: 100

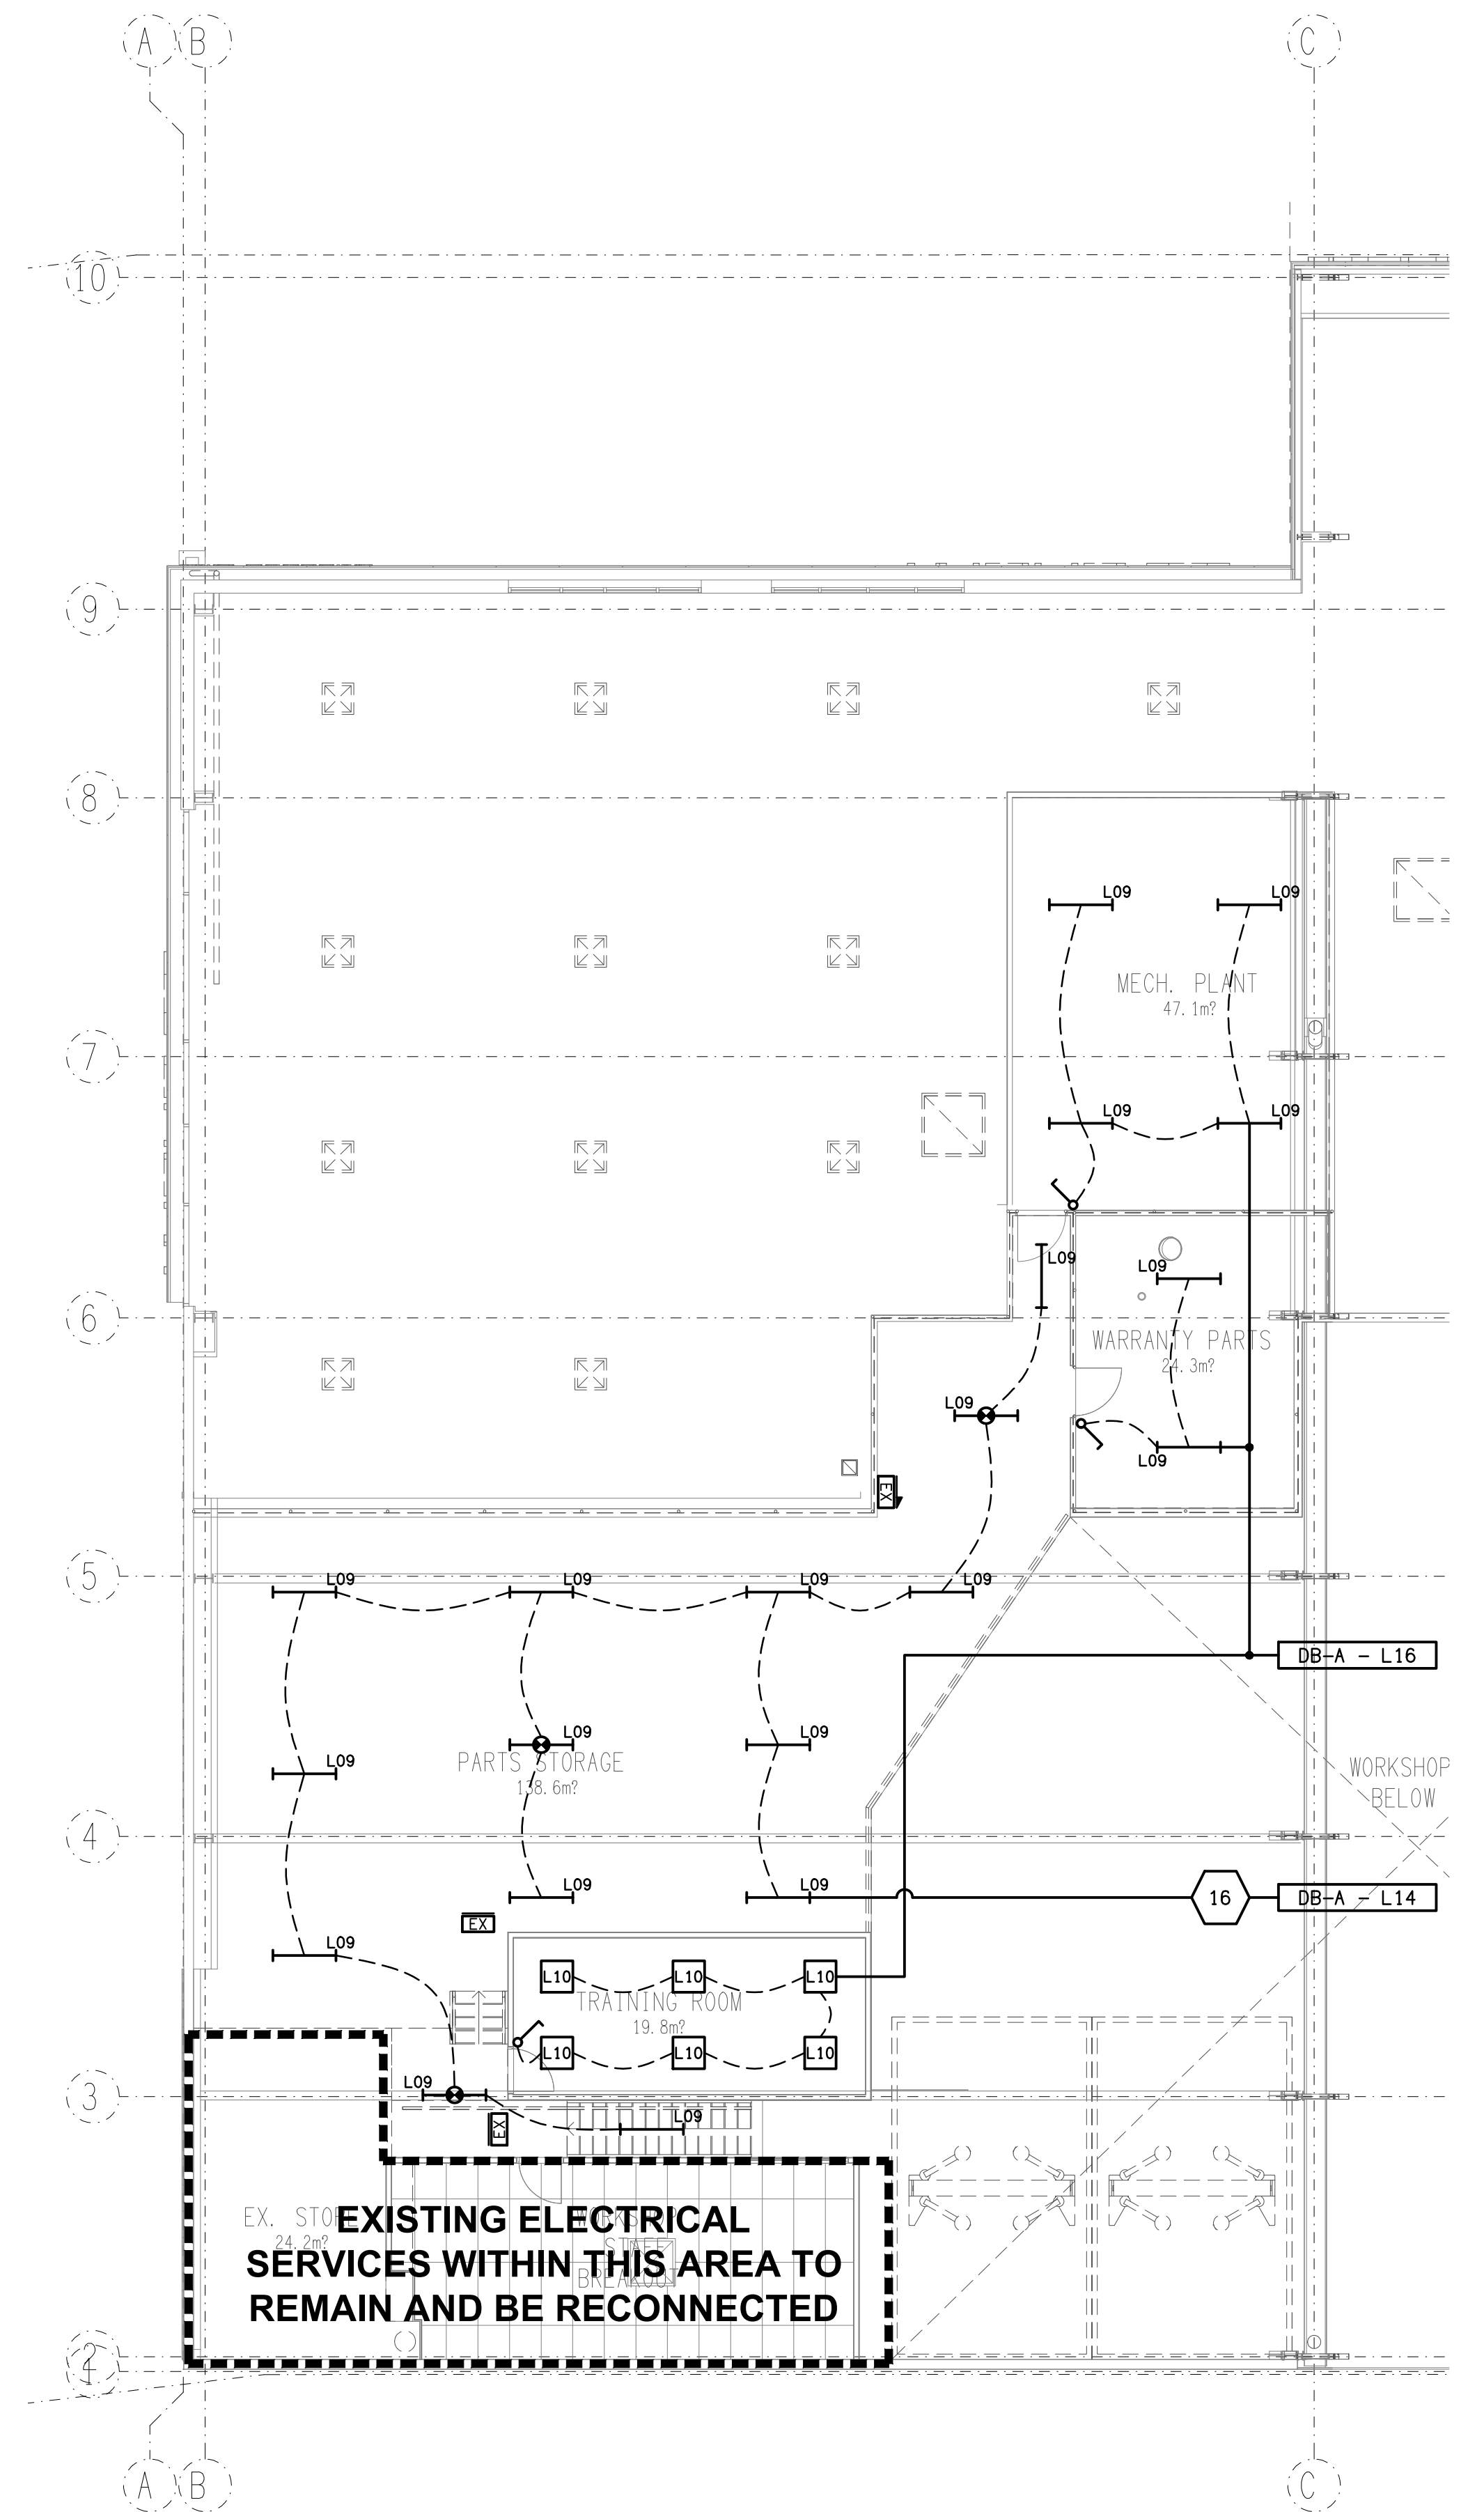

REFLECTED CEILING PLAN
MEZZANINE LEVEL
SCALE 1: 100

ELECTRICAL DESIGN GROUP BRISBANE
PTY LTD
ACN 092 710 793
TRADING AS:
ELECTRICAL DESIGN GROUP

THE COPYRIGHT OF THIS DRAWING
REMAINS THE PROPERTY OF THE
ELECTRICAL DESIGN GROUP.
USE FIGURED DIMENSIONS
IN PREFERENCE TO SCALE.
ALL DIMENSIONS TO BE
VERIFIED ONSITE.

ELECTRICAL DESIGN GROUP
ELECTRICAL BUILDING SERVICES CONSULTANTS
BRISBANE GOLD COAST

P.O.Box 15, Sherwood Q.4075
Phone: (07) 3278 4375
Email: brisbane@edg.net.au
Web: www.edg.net.au

PROJECT:
CBMG BOWEN HILLS

16 BURROWS STREET, BOWEN HILLS

B	TENDER	05/05/2026
REV:	DESCRIPTION:	DATE:

DRAWING:
ELECTRICAL SERVICES
MEZZANINE LEVEL PLANS

SCALE:
1:100

AT A1

PROJECT NO:
C3684a

DRAWING NO:
E06

REVISION:
B