



LEVEL 3
FLOOR / REFLECTED CEILING PLAN
SCALE 1: 200

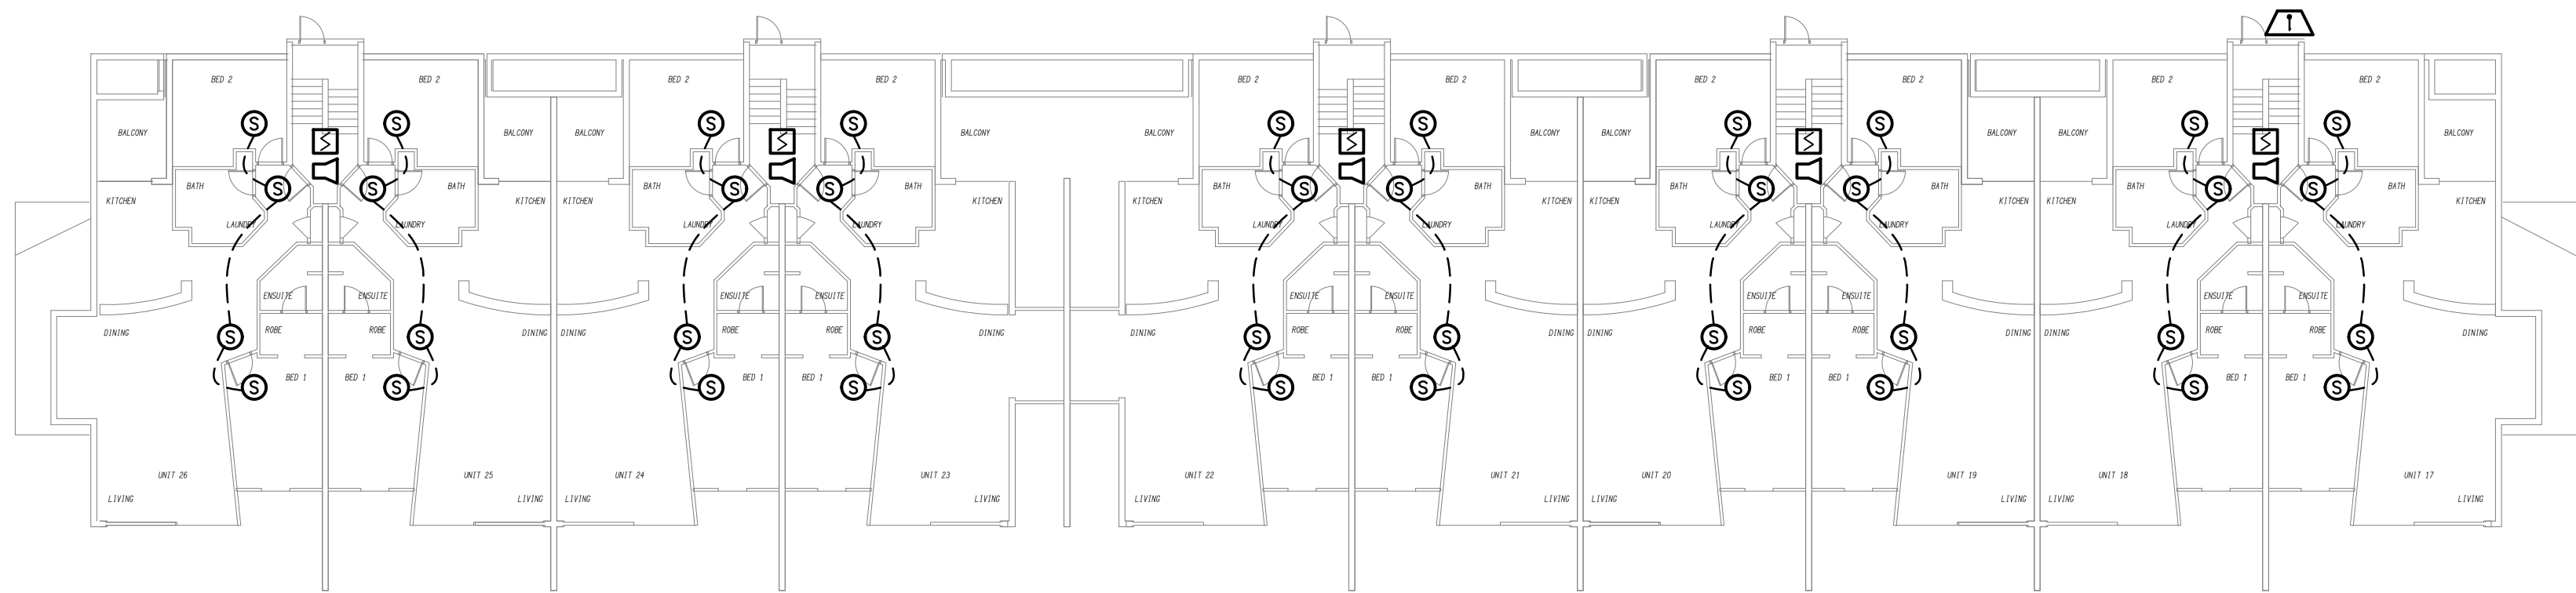

LEVEL 2
FLOOR / REFLECTED CEILING PLAN
SCALE 1: 200

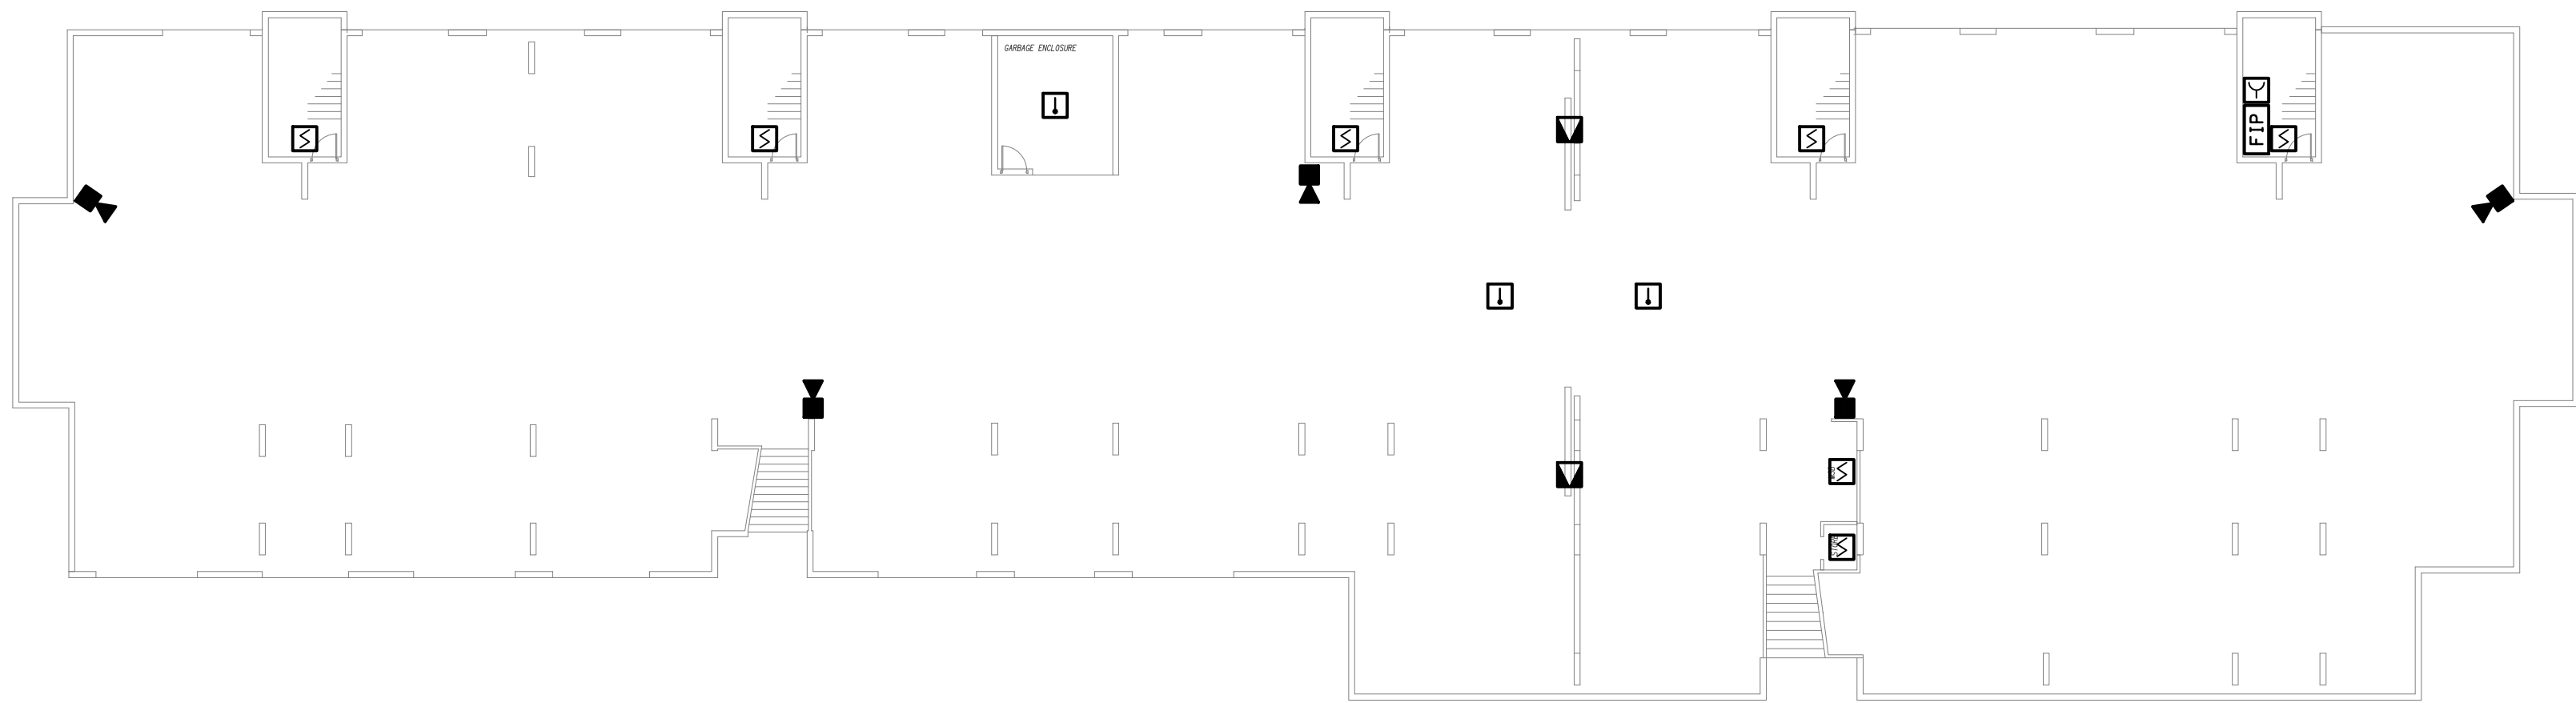

LEVEL 1
FLOOR / REFLECTED CEILING PLAN
SCALE 1: 200

ELECTRICAL DESIGN GROUP BRISBANE
PTY LTD
ACN 092 710 793
TRADING AS:
ELECTRICAL DESIGN GROUP

THE COPYRIGHT OF THIS DRAWING
REMAINS THE PROPERTY OF THE
ELECTRICAL DESIGN GROUP.
USE FIGURED DIMENSIONS
IN PREFERENCE TO SCALE.
ALL DIMENSIONS TO BE
VERIFIED ONSITE.

ELECTRICAL DESIGN GROUP
ELECTRICAL BUILDING SERVICES CONSULTANTS
BRISBANE GOLD COAST
P.O.Box 15, Sherwood Q.4075
Phone: (07) 3278 4375
Email: brisbane@edg.net.au
Web: www.edg.net.au

PROJECT:
MERCANTILE, DALGETY PLACE
135 MACQUARIE STREET, TENERIFFE

A	INFORMATION	01/06/2026
REV:	DESCRIPTION:	DATE:
DRAWING: ELECTRICAL SERVICES BLOCKS A & B LEVEL 1, 2 & 3 PLANS		
SCALE: 1:200	PROJECT NO: C3700a	DRAWING NO: E02
AT A1	REVISION: A	