




CURTIN AVENUE EAST

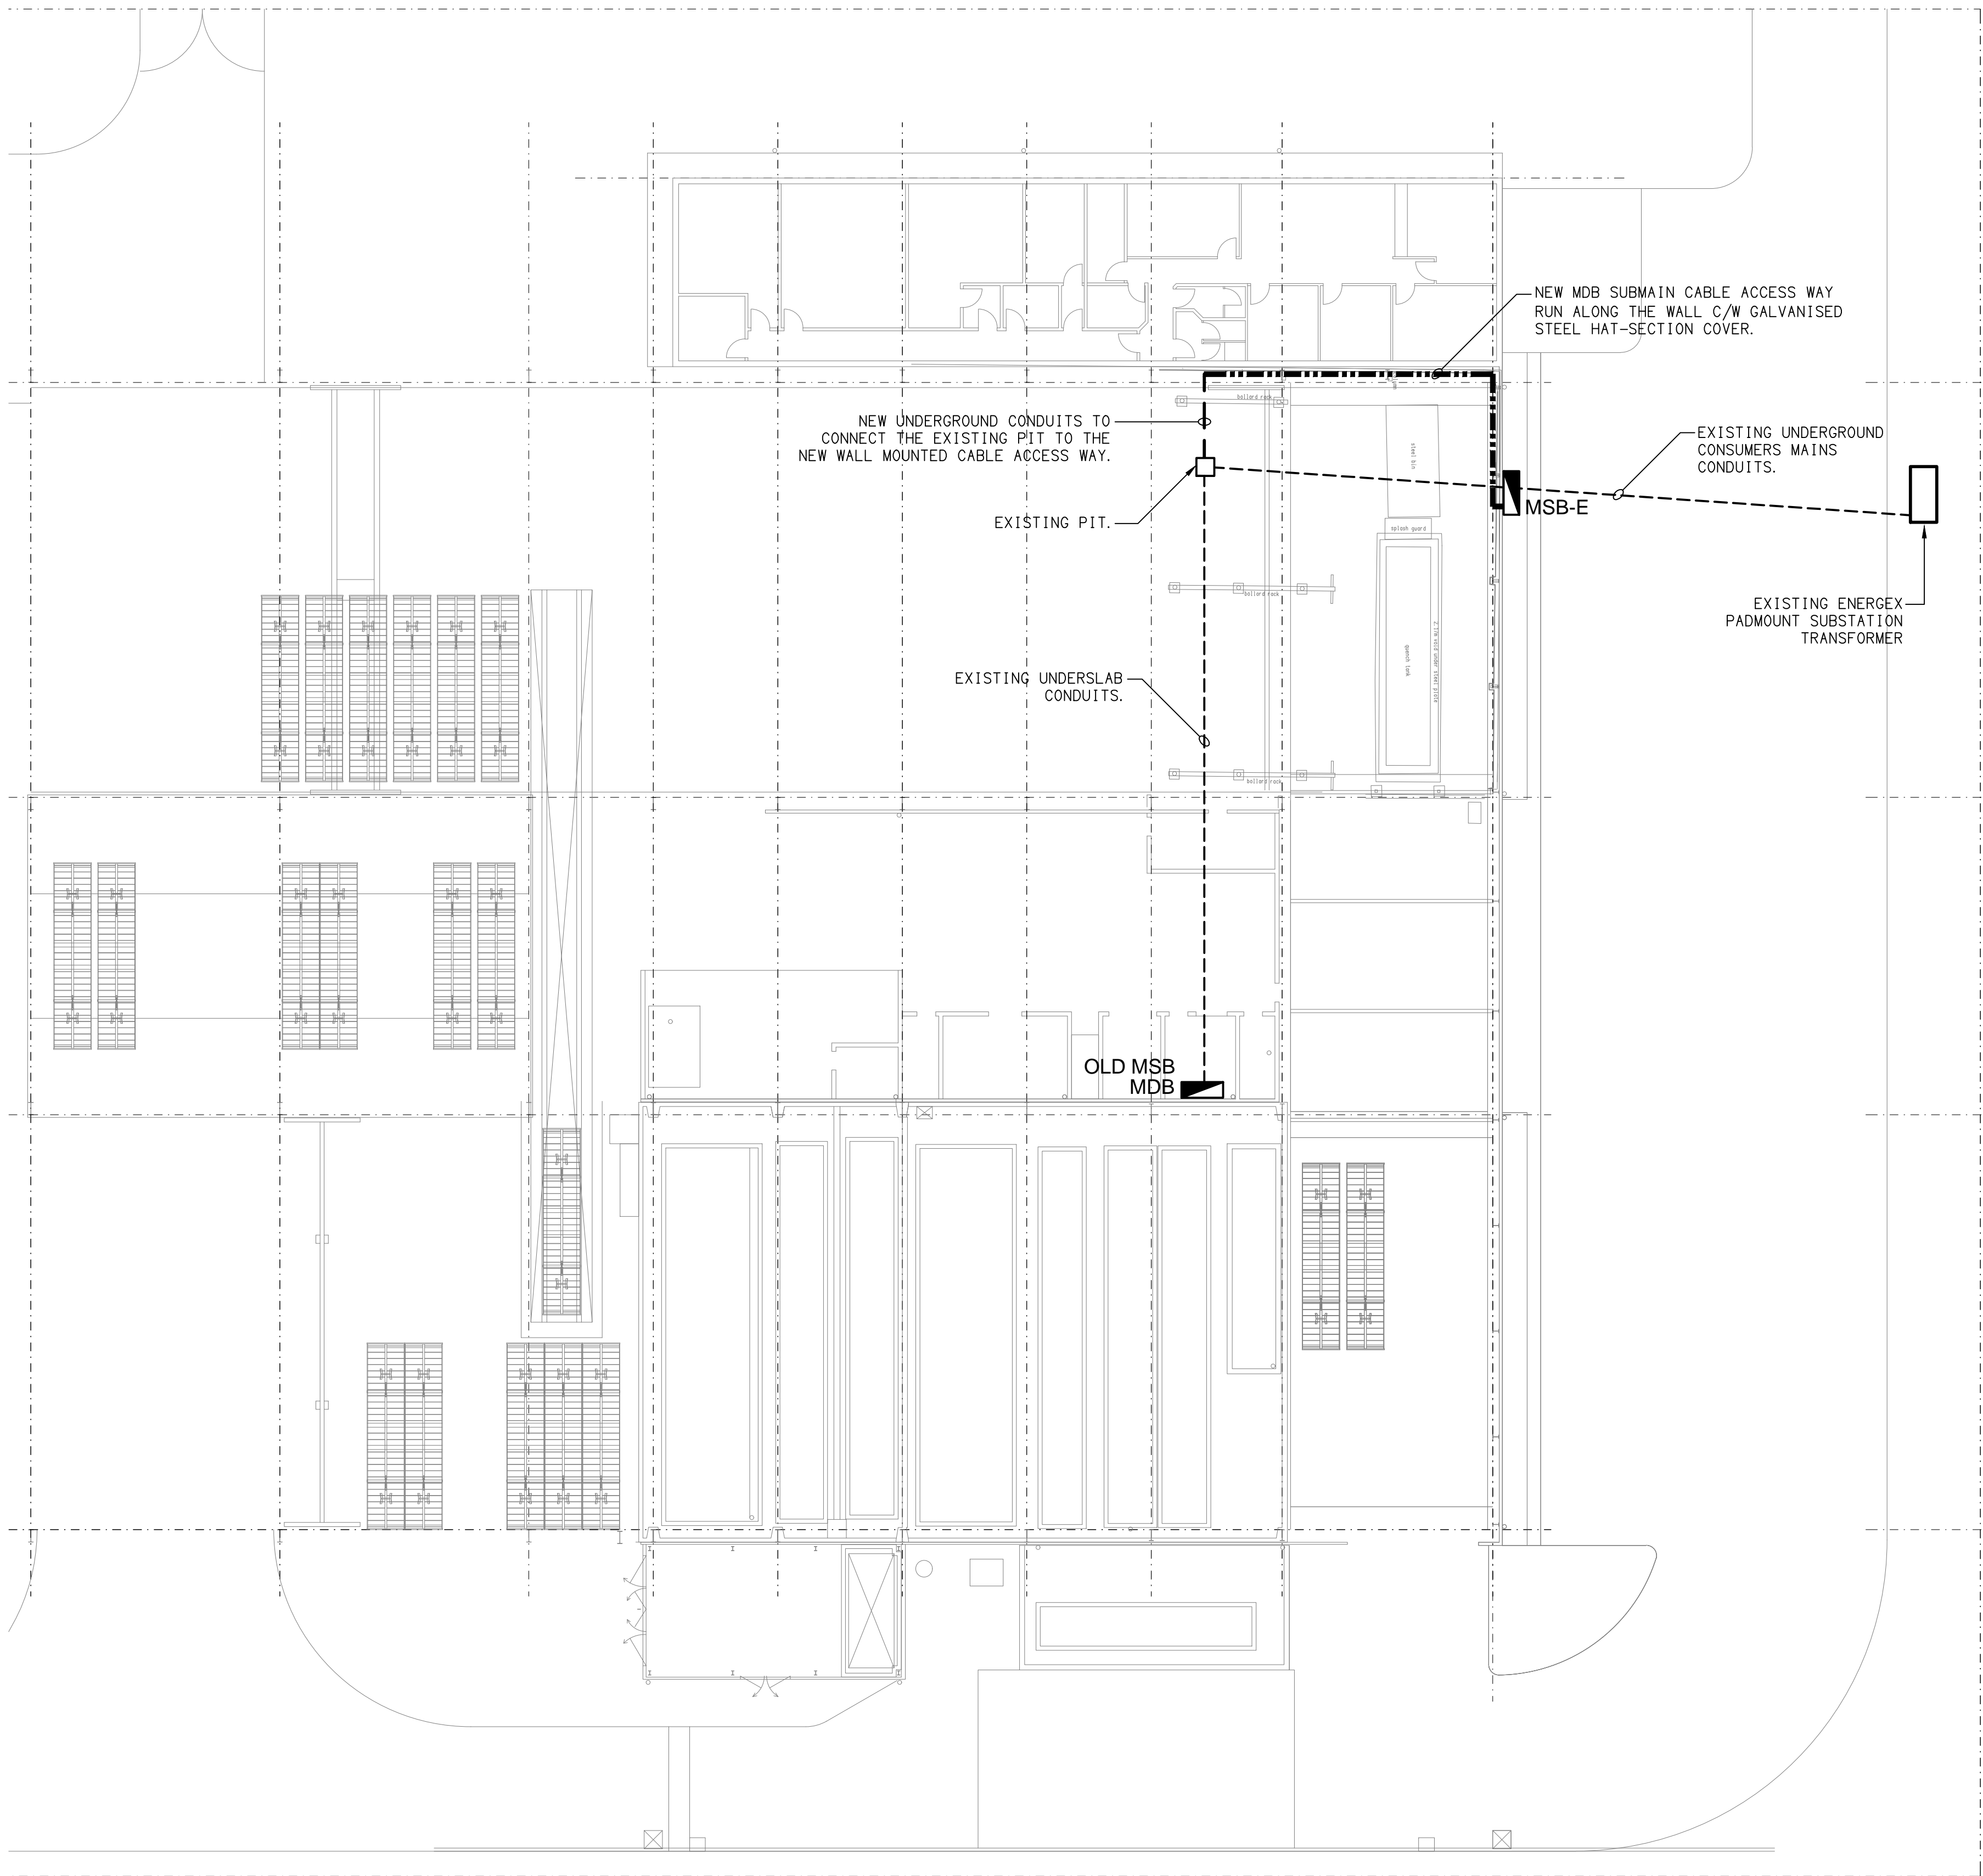

**PART SITE PLAN**  
MSB-E & PIT ARRANGEMENTS  
SCALE 1: 200

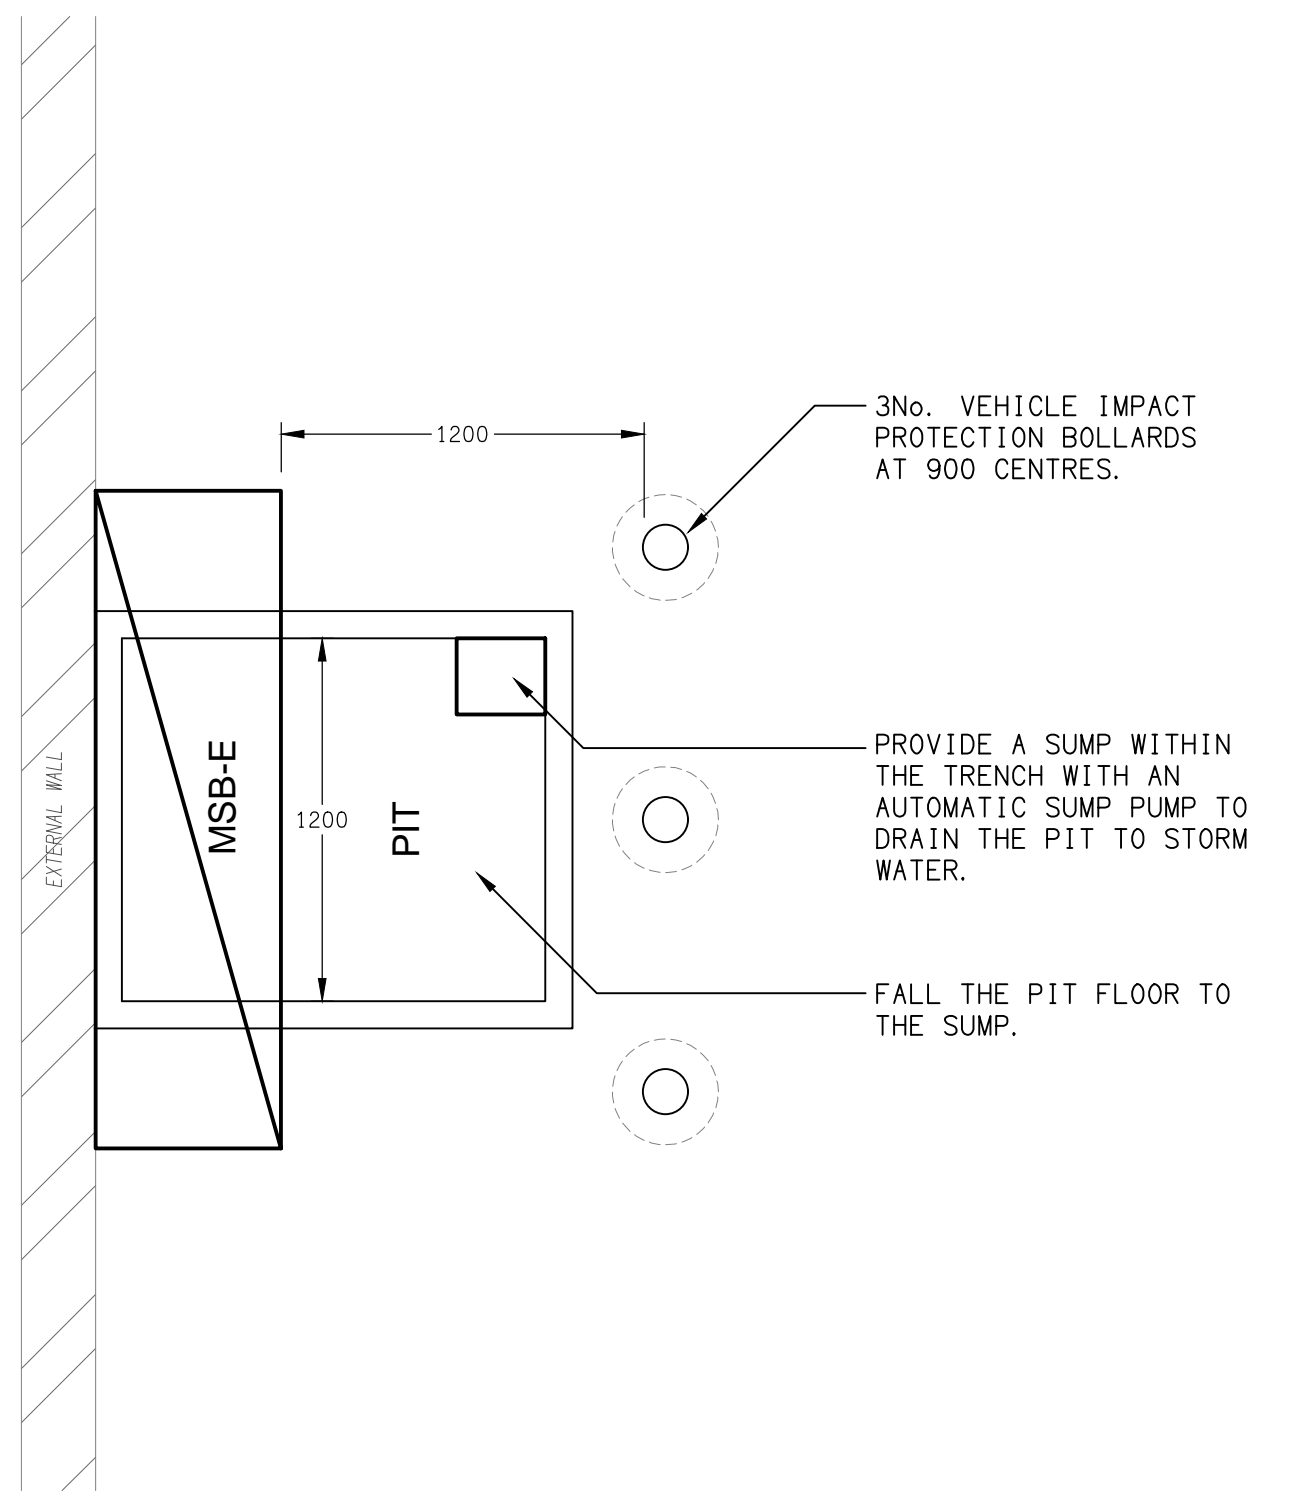

**PLAN VIEW**  
MSB-E & PIT  
SCALE 1: 25

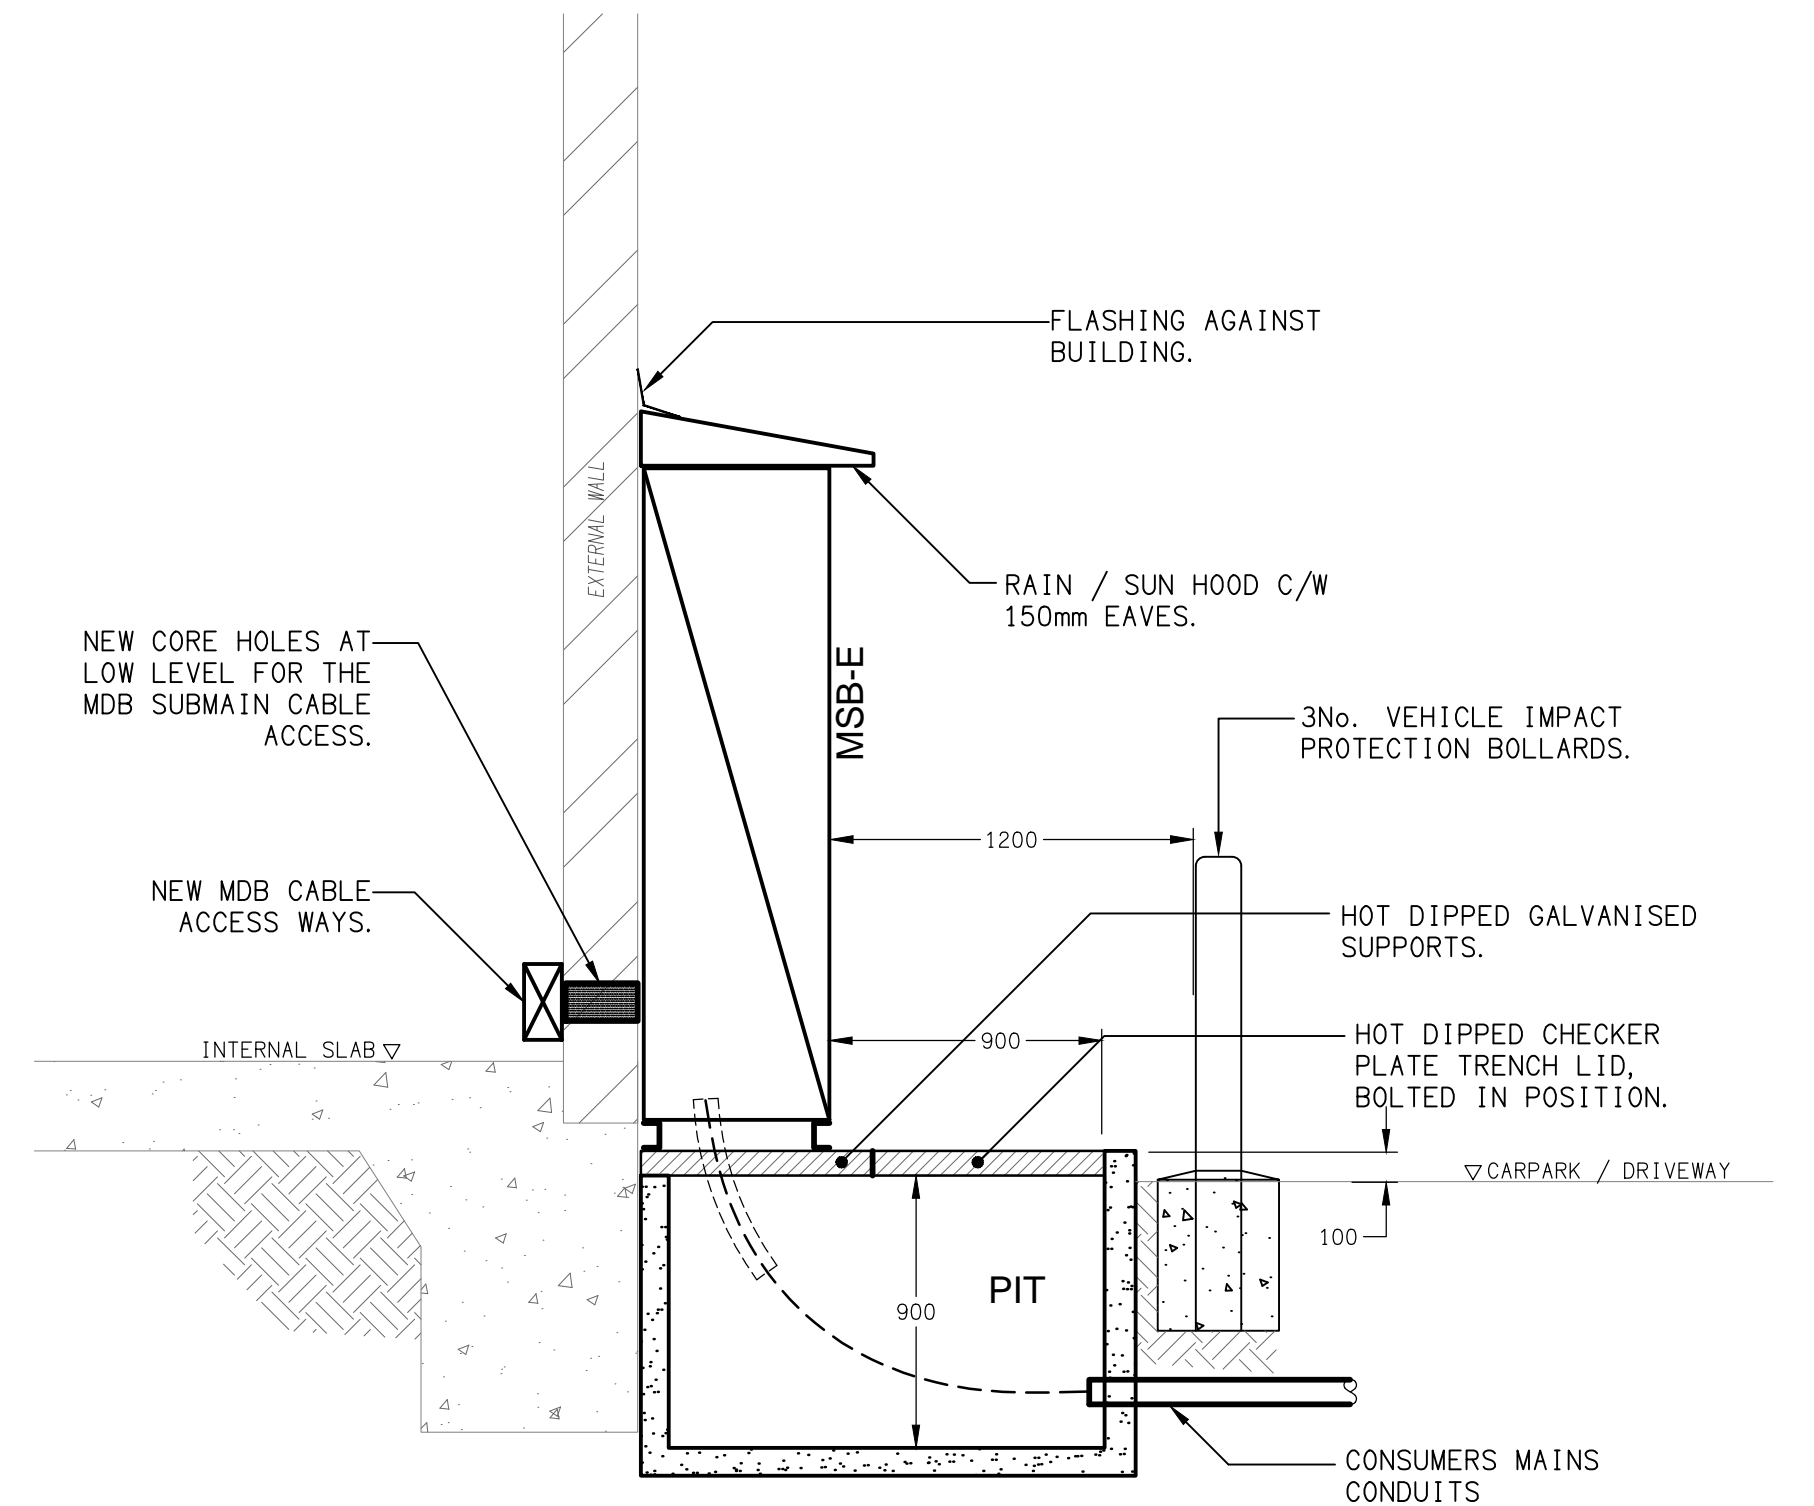

**SECTION VIEW**  
MSB-E & PIT  
SCALE 1: 25

ELECTRICAL DESIGN GROUP BRISBANE  
PTY LTD  
ACN 092 710 793  
TRADING AS:  
ELECTRICAL DESIGN GROUP

THE COPYRIGHT OF THIS DRAWING  
REMAINS THE PROPERTY OF THE  
ELECTRICAL DESIGN GROUP.  
USE FIGURED DIMENSIONS  
IN PREFERENCE TO SCALE.  
ALL DIMENSIONS TO BE  
VERIFIED ONSITE.

**ELECTRICAL DESIGN GROUP**  
ELECTRICAL BUILDING SERVICES CONSULTANTS  
BRISBANE GOLD COAST

P.O.Box 15, Sherwood Q.4075  
Phone: (07) 3278 4375  
Email: brisbane@edg.net.au  
Web: www.edg.net.au

PROJECT:  
661 CURTIN AVENUE EAST, PINKENBA

BRISBANE

B	APPROVAL	02/06/2026
REV:	DESCRIPTION:	DATE:

DRAWING:  
**ELECTRICAL SERVICES  
PART SITE PLAN**

SCALE:  
1:200 UNO AT A1

PROJECT NO:  
**C3712a**

DRAWING NO:  
**E03**

REVISION:  
**B**